

Use one form for each individual who reviews and takes responsibility for design activities with respect to the project.

A. Project Information					
Building number, street name Rideau 1 Loft S42-1B Loft				Lot: Lot/con.	
Municipality Bradford		Postal code	Plan number/ other description		
B. Individual who reviews and takes responsibility for design activities					
Name David DaCosta			Firm gtaDesigns Inc.		
Street address 2985 Drew Road, Suite 202				Unit no.	Lot/con.
Municipality Mississauga		Postal code L4T 0A4	Province Ontario	E-mail dave@gtadesigns.ca	
Telephone number (905) 671-9800		Fax number (647) 494-9643		Cell number (416) 268-6820	
C. Design activities undertaken by individual identified in Section B. [Building Code Table 3.5.2.1 of Division C]					
☐ House ☒ HVAC – House ☐ Building Structural ☐ Small Buildings ☐ Building Services ☐ Plumbing – House ☐ Large Buildings ☐ Detection, Lighting and Power ☐ Plumbing – All Buildings ☐ Complex Buildings ☐ Fire Protection ☐ On-site Sewage Systems					
Description of designer's work			Model Certification		Project #:
					PJ-00204
					Layout #:
					JB-04585
Heating and Cooling Load Calculations		Main	X	Builder	Bayview Wellington
Air System Design		Alternate		Project	Green Valley East
Residential mechanical ventilation Design Summary		Area Sq ft:	2818	Model	Rideau 1 Loft
Residential System Design per CAN/CSA-F280-12					S42-1B Loft
Residential New Construction - Forced Air				SB-12	Package A1
D. Declaration of Designer					
I, <u>David DaCosta</u> declare that (choose one as appropriate): (print name) ☐ I review and take responsibility for the design work on behalf of a firm registered under subsection 3.2.4 Division C of the Building Code. I am qualified, and the firm is registered, in the appropriate classes/categories. Individual BCIN: _____ Firm BCIN: _____ ☒ I review and take responsibility for the design and am qualified in the appropriate category as an "other designer" under subsection 3.2.5 of Division C, of the Building Code. Individual BCIN: <u>32964</u> Basis for exemption from registration: <u>Division C 3.2.4.1. (4)</u> ☐ The design work is exempt from the registration and qualification requirements of the Building Code. Basis for exemption from registration and qualification:					
I certify that: 1. The information contained in this schedule is true to the best of my knowledge. 2. I have submitted this application with the knowledge and consent of the firm.					
<u>March 23, 2018</u> Date			 Signature of Designer		

NOTE:

- For the purposes of this form, "individual" means the "person" referred to in Clause 3.2.4.7(1) d), of Division C, Article 3.2.5.1. of Division C and all other persons who are exempt from qualifications under Subsections 3.2.4 . and 3.2.5.of Division C.
- Schedule 1 does not require to be completed a holder of a license, temporary license, or a certificate of authorization, issued by the Ontario Association of Architects. Schedule 1 is also not required to be completed by a holder of a license to practise, a limited licence to practise, or a certificate of authorization, issued by the Association of Professional Engineers of Ontario.

Heat loss and gain calculation summary sheet				CSA-F280-M12 Standard Form No. 1	
These documents issued for the use of Bayview Wellington				Layout No.	
and may not be used by any other persons without authorization. Documents for permit and/or construction are signed in red.				JB-04585	
Building Location					
Address (Model): S42-1B Loft			Site: Green Valley East		
Model: Rideau 1 Loft			Lot:		
City and Province: Bradford			Postal code:		
Calculations based on					
Dimensional information based on:			VA3 Design Jan/2018		
Attachment: Detached			Front facing: East/West		Assumed? Yes
No. of Levels: 3		Ventilated? Included	Air tightness: 1961-Present (ACH=3.57)		Assumed? Yes
Weather location: Bradford			Wind exposure: Sheltered		
HRV? LifeBreath		RNC155	Internal shading: Light-translucent		Occupants: 5
Sensible Eff. at -25C 71%		Apparent Effect. at -0C 84%	Units: Imperial		Area Sq ft: 2818
Sensible Eff. at -0C 75%					
Heating design conditions			Cooling design conditions		
Outdoor temp -9.4 Indoor temp: 72 Mean soil temp: 48			Outdoor temp 86 Indoor temp: 75 Latitude: 44		
Above grade walls			Below grade walls		
Style A: As per OBC SB12 Package A1 R 22			Style A: As per OBC SB12 Package A1 R 20ci		
Style B: Existing Walls (When Applicable) R 12			Style B:		
Style C:			Style C:		
Style D:			Style D:		
Floors on soil			Ceilings		
Style A: As per Selected OBC SB12 Package A1			Style A: As per Selected OBC SB12 Package A1 R 60		
Style B:			Style B: As per Selected OBC SB12 Package A1 R 31		
Exposed floors			Style C:		
Style A: As per Selected OBC SB12 Package A1 R 31			Doors		
Style B:			Style A: As per Selected OBC SB12 Package A1 R 4.00		
Windows			Style B:		
Style A: As per Selected OBC SB12 Package A1 R 3.55			Style C:		
Style B: Existing Windows (When Applicable) R 1.99			Skylights		
Style C:			Style A: As per Selected OBC SB12 Package A1 R 2.03		
Style D:			Style B:		
Attached documents: As per Shedule 1		Heat Loss/Gain Caculations based on CSA-F280-12 Effective R-Values			
Notes: Residential New Construction - Forced Air					
Calculations performed by					
Name: David DaCosta			Postal code: L4T 0A4		
Company: gtaDesigns Inc.			Telephone: (905) 671-9800		
Address: 2985 Drew Road, Suite 202			Fax: (416) 268-6820		
City: Mississauga			E-mail dave@gtadesigns.ca		

SB-12 Package A1			
Builder: Bayview Wellington	Date: March 23, 2018	System 1	
Project: Green Valley East	Model: Rideau 1 Loft S42-1B Loft		
		I review and take responsibility for the design work and am qualified in the appropriate category as an "other designer" under Division C subsection 3.2.5. of the Building Code. Individual BCIN: 32964 <i>David DaCosta</i> David DaCosta	
		Project # PJ-00204 Layout # JB-04584	

DESIGN LOAD SPECIFICATIONS	AIR DISTRIBUTION & PRESSURE	FURNACE/AIR HANDLER DATA:	BOILER/WATER HEATER DATA:	A/C UNIT DATA:
Level 1 Net Load 19,715 btu/h	Equipment External Static Pressure 0.5 "w.c.	Make Amana	Make Type Amana 2.5 Ton	
Level 2 Net Load 24,253 btu/h	Additional Equipment Pressure Drop 0.225 "w.c.	Model AMEC960603BNA	Model Cond.----- 2.5	
Level 3 Net Load 9,880 btu/h	Available Design Pressure 0.275 "w.c.	Input Btu/h 60000	Input Btu/h Coil ----- 2.5	
Level 4 Net Load 0 btu/h	Return Branch Longest Effective Length 300 ft	Output Btu/h 57600	Min.Output Btu/h AWH	
Total Heat Loss 53,848 btu/h	R/A Plenum Pressure 0.138 "w.c.	E.s.p. 0.50 " W.C.		
Total Heat Gain 28,034 btu/h	S/A Plenum Pressure 0.14 "w.c.	Water Temp deg. F.		
Combo System HL + 10% 59,233 Btu/h	Heating Air Flow Proportioning Factor 0.0217 cfm/btuh	AFUE 96%	Blower Speed Selected: W2	Blower Type ECM
Building Volume Vb 38268 ft³	Cooling Air Flow Proportioning Factor 0.0344 cfm/btuh	Aux. Heat		(Brushless DC OBC 12.3.1.5.(2))
Ventilation Load 1,118 Btu/h.	R/A Temp 70 deg. F.	SB-12 Package Package A1	Heating Check 1170 cfm	Cooling Check 963 cfm
Ventilation PVC 79.5 cfm	S/A Temp 116 deg. F.		Selected cfm> 1170 cfm	Cooling Air Flow Rate 963 cfm
Supply Branch and Grill Sizing	Diffuser loss 0.01 "w.c.	Temp. Rise>>> 46 deg. F.		

	Level 1														Level 2													
S/A Outlet No.	1	2	3	4	5	6									7	8	9	10	11	12	13	14	15	16	17	18	19	
Room Use	BASE	BASE	BASE	BASE	BASE	BASE									MAST	MAST	LIV/DIN	LIV/DIN	LIV/DIN	KIT	KIT	LAUN	FOY IB/BED2	IB/BED2	BATH	ENS		
Btu/Outlet	3286	3286	3286	3286	3286	3286									2059	2059	2084	2084	2084	1490	1490	1492	2775	2197	2197	935	1307	
Heating Airflow Rate CFM	71	71	71	71	71	71									45	45	45	45	45	32	32	32	60	48	48	20	28	
Cooling Airflow Rate CFM	14	14	14	14	14	14									57	57	86	86	86	43	43	67	55	54	54	14	22	
Duct Design Pressure	0.13	0.13	0.13	0.13	0.13	0.13	0.13	0.13	0.13	0.13	0.13	0.13	0.13	0.13	0.13	0.13	0.13	0.13	0.13	0.13	0.13	0.13	0.13	0.13	0.13			
Actual Duct Length	45	55	33	26	15	26									58	51	49	56	67	53	46	35	26	34	30	9	24	
Equivalent Length	120	110	90	70	140	90	70	70	70	70	70	70	70	130	90	100	120	100	95	110	140	100	80	70	120			
Total Effective Length	165	165	123	96	155	116	70	70	70	70	70	70	70	188	141	149	176	167	148	156	175	126	114	100	129			
Adjusted Pressure	0.08	0.08	0.11	0.14	0.08	0.11	0.19	0.19	0.19	0.19	0.19	0.19	0.19	0.07	0.09	0.09	0.07	0.08	0.09	0.08	0.07	0.10	0.11	0.13	0.10			
Duct Size Round	6	6	6	6	6	6									5	5	6	6	6	5	5	6	6	5	5	3	4	
Outlet Size	4x10	4x10	4x10	4x10	4x10	4x10	4x10	4x10	4x10	4x10	4x10	4x10	4x10	3x10	3x10	4x10	4x10	4x10	3x10	3x10	4x10	4x10	3x10	3x10	3x10	4x10		
Trunk	C	B	A	A	D	D									C	C	C	B	B	E	E	A	D	D	D	D	A	

	Level 3														Level 4													
S/A Outlet No.	20	21	22	23	24																							
Room Use	BED 3/4	LOFT	LOFT	BED 2/3	BATH 2																							
Btu/Outlet	2092	2355	2355	1968	1111																							
Heating Airflow Rate CFM	45	51	51	43	24																							
Cooling Airflow Rate CFM	38	35	35	36	15																							
Duct Design Pressure	0.13	0.13	0.13	0.13	0.13	0.13	0.13	0.13	0.13	0.13	0.13	0.13	0.13	0.13	0.13	0.13	0.13	0.13	0.13	0.13	0.13	0.13	0.13	0.13	0.13	0.13	0.13	
Actual Duct Length	60	66	54	28	45																							
Equivalent Length	120	105	145	150	100	70	70	70	70	70	70	70	70	70	70	70	70	70	70	70	70	70	70	70	70	70	70	
Total Effective Length	180	171	199	178	145	70	70	70	70	70	70	70	70	70	70	70	70	70	70	70	70	70	70	70	70	70	70	
Adjusted Pressure	0.07	0.08	0.07	0.07	0.09	0.19	0.19	0.19	0.19	0.19	0.19	0.19	0.19	0.19	0.19	0.19	0.19	0.19	0.19	0.19	0.19	0.19	0.19	0.19	0.19	0.19	0.19	
Duct Size Round	6	6	6	6	4																							
Outlet Size	4x10	4x10	4x10	4x10	3x10	4x10	4x10	4x10	4x10	4x10	4x10	4x10	4x10	4x10	4x10	4x10	4x10	4x10	4x10	4x10	4x10	4x10	4x10	4x10	4x10	4x10	4x10	
Trunk	E	E	A	A	A																							

Return Branch And Grill Sizing												Return Trunk Duct Sizing					Supply Trunk Duct Sizing				
Grill Pressure Loss 0.02 "w.c.																					
R/A Inlet No.	1R	2R	3R	4R	5R	6R	7R	8R	9R	10R	11R	Trunk	CFM	Press.	Round	Rect. Size	Trunk	CFM	Press.	Round	Rect. Size
Inlet Air Volume CFM	215	175	400	100	140	140						Drop	1170	0.06	16.5	24x10	A	851	0.07	14.5	24x8 18x10
Duct Design Pressure	0.12	0.12	0.12	0.12	0.12	0.12	0.12	0.12	0.12	0.12	0.12		Z	1170	0.06	16.5	32x8 24x10	B	162	0.07	8.0
Actual Duct Length	17	32	20	21	54	42						Y	530	0.06	12.5	18x8 14x10	C	206	0.07	8.5	8x8
Equivalent Length	110	180	135	135	145	135	50	50	50	50	50	X					D	319	0.08	9.5	10x8
Total Effective Length	127	212	155	156	199	177	50	50	50	50	50	W					E	529	0.07	12.0	16x8 12x10
Adjusted Pressure	0.09	0.06	0.08	0.08	0.06	0.07	0.24	0.24	0.24	0.24	0.24	V					F				
Duct Size Round	8.0	8.5	10.5	6.0	7.5	7.5						U					G				
Inlet Size	FLC	8	8	8	8	8						T					H				
" "	x	x	x	x	x	x	x	x	x	x	x	S					I				
Inlet Size	9x6	14	30	14	14	14						R					J				
												Q					K				
Trunk	Y	Y	Z	Z	Y	Z															

2012 OBC

Builder: Bayview Wellington

Date: March 23, 2018

Project: Green Valley East

Model: Rideau 1 Loft S42-1B Loft

System 1

Weather Data Bradford 44 -9.4 86 22 48.2

Heat Loss ^T 81.4 deg. F Ht gain ^T 11 deg. F GTA: 2818

Project # PJ-00204
Layout # JB-04585

Level 1

Run ft. exposed wall A	206 A	A	A	A	A	A	A	A	A	A	A	A	A
Run ft. exposed wall B	B	B	B	B	B	B	B	B	B	B	B	B	B
Ceiling height	3.8 AG	3.8 AG	3.8 AG	3.8 AG	3.8 AG	3.8 AG	3.8 AG	3.8 AG	3.8 AG	3.8 AG	3.8 AG	3.8 AG	3.8 AG
Floor area	1626 Area	Area	Area	Area	Area	Area	Area	Area	Area	Area	Area	Area	Area
Exposed Ceilings A	A	A	A	A	A	A	A	A	A	A	A	A	A
Exposed Ceilings B	B	B	B	B	B	B	B	B	B	B	B	B	B
Exposed Floors	Flr	Flr	Flr	Flr	Flr	Flr	Flr	Flr	Flr	Flr	Flr	Flr	Flr
Gross Exp Wall A	779												
Gross Exp Wall B													

Components	R-Values	Loss	Gain	Loss	Gain	Loss	Gain	Loss	Gain	Loss	Gain	Loss	Gain	Loss	Gain	Loss	Gain
North Shaded	3.55	22.93	10.91														
East/West	3.55	22.93	27.35	41	940	1121											
South	3.55	22.93	20.89	6	138	125											
WOB Windows	3.15	25.84	28.32														
Skylight	2.03	40.10	88.23														
Doors	4.00	20.35	2.75	21	427	58											
Net exposed walls A	21.12	3.85	0.52	711		370											
Net exposed walls B	14.49	5.62	0.76														
Exposed Ceilings A	59.22	1.37	0.64														
Exposed Ceilings B	22.86	3.56	1.66														
Exposed Floors	29.80	2.73	0.17														
Foundation Conductive Heatloss	On Grade () or Above																
Total Conductive	Heat Loss																
	Heat Gain																
Air Leakage	Heat Loss/Gain	0.9042	0.0453														
Ventilation	Case 1	0.05	0.07														
	Case 2	14.07	11.88														
	Case 3	x	0.03	0.07													
Heat Gain People			239														
Appliances Loads	1 = .25 percent		5305														
Duct and Pipe loss			10%														
Level 1 HL Total	19,715		Total HL for per room	19715													
Level 1 HG Total	2,428		Total HG per room x 1.3		2428												

Level 2

Run ft. exposed wall A	35 A	MAST	38 A	LIV/DIN	36 A	KIT	15 A	LAUN	17 A	FOY	42 A	LIB/BED2	10 A	BATH	14 A	ENS	A	A	A
Run ft. exposed wall B	B		B		B		B		B		B		B		B		B	B	B
Ceiling height	11.0		13.0		10.0		11.0		13.0		10.0		10.0		10.0		10.0	10.0	10.0
Floor area	286 Area		300 Area		535 Area		52 Area		68 Area		151 Area		67 Area		154 Area		Area	Area	Area
Exposed Ceilings A	163 A		258 A		A		A		68 A		151 A		29 A		A		A	A	A
Exposed Ceilings B	B		B		B		B		B		B		B		B		B	B	B
Exposed Floors	Flr		Flr		Flr		Flr		Flr		Flr		Flr		Flr		Flr	Flr	Flr
Gross Exp Wall A	385		494		360		165		221		420		100		140				
Gross Exp Wall B																			

Components	R-Values	Loss	Gain	Loss	Gain	Loss	Gain	Loss	Gain	Loss	Gain	Loss	Gain	Loss	Gain	Loss	Gain	Loss	Gain
North Shaded	3.55	22.93	10.91																
East/West	3.55	22.93	27.35	56	1284	1532				33	757	903	59	1353	1614				
South	3.55	22.93	20.89											10	229	209	17	390	355
Existing Windows	1.99	40.90	22.15																
Skylight	2.03	40.10	88.23																
Doors	4.00	20.35	2.75																
Net exposed walls A	17.03	4.78	0.65	329	1573	213	386	1845	249	332	1587	214	144	688	93	21	427	58	
Net exposed walls B	8.50	9.58	1.29																
Exposed Ceilings A	59.22	1.37	0.64	163	224	105	258	355	166				68	93	44	151	208	97	29
Exposed Ceilings B	22.86	3.56	1.66																
Exposed Floors	29.80	2.73	0.17																
Foundation Conductive Heatloss	On Grade () or Above																		
Total Conductive	Heat Loss																		
	Heat Gain																		
Air Leakage	Heat Loss/Gain	0.3044	0.0453																
Ventilation	Case 1	0.02	0.07																
	Case 2	14.07	11.88																
	Case 3	x	0.03	0.07															
Heat Gain People			239																
Appliances Loads	1 = .25 percent		5305																
Duct and Pipe loss			10%																
Level 2 HL Total	24,253		Total HL for per room	4119															
Level 2 HG Total	20,978		Total HG per room x 1.3		3302														

I review and take responsibility for the design work and am qualified in the appropriate category as an "other designer" under

Division C subsection 3.2.5. of the Building Code. Individual BCIN:

32964

Dave DaCosta

Dave DaCosta

SB-12 Package

Package A1

Site Copy

I review and take responsibility for the design work and am qualified in the appropriate category as an "other designer" under Division C subsection 3.2.5. of the Building Code.

Individual BCIN: 32964



David DaCosta

Package:
Package A1
Project:
Bradford
Model:
S42-1B Loft
RESIDENTIAL MECHANICAL VENTILATION DESIGN SUMMARY

For systems serving one dwelling unit & conforming to the Ontario Building Code, O.reg 332/12

Location of Installation

Lot #	Plan #
Township	Bradford
Roll #	Permit #
Address	

Builder

Name	Bayview Wellington
Address	
City	
Tel	Fax

Installing Contractor

Name	
Address	
City	
Tel	Fax

Combustion Appliances 9.32.3.1(1)

- | | | |
|----|-------------------------------------|--|
| a) | ☒ | Direct vent (sealed combustion) only |
| b) | ☐ | Positive venting induced draft (except fireplaces) |
| c) | ☐ | Natural draft, B-vent or induced draft fireplaces |
| d) | ☐ | Solid fuel (including fireplaces) |
| e) | ☐ | No combustion Appliances |

Heating System

- | | |
|-------------------------------------|--|
| ☒ | Forced air |
| ☐ | Non forced air |
| ☐ | Electric space heat (if over 10% of heat load) |

House Type 9.32.3.1(2)

- | | | |
|-------|-------------------------------------|---|
| I | ☒ | Type a) or b) appliances only, no solid fuel |
| II | ☐ | Type I except with solid fuel (including fireplace) |
| III | ☐ | Any type c) appliance |
| IV | ☐ | Type I or II either electric space heat |
| Other | ☐ | Type I, II or IV no forced air |

System Design Option

- | | | |
|---|-------------------------------------|---|
| 1 | ☐ | Exhaust only / forced air system |
| 2 | ☐ | HRV WITH DUCTING / forced air system |
| 3 | ☒ | HRV simplified connection to forced air system |
| 4 | ☐ | HRV full ducting/not coupled to forced air system |
| | ☐ | Part 6 design |

Total Ventilation Capacity 9.32.3.3(1)

Bsmt & Master Bdrm	2 @ 21.2 cfm	42.4 cfm
Other Bedrooms	3 @ 10.6 cfm	31.8 cfm
Bathrooms & Kitchen	4 @ 10.6 cfm	42.4 cfm
Other rooms	6 @ 10.6 cfm	63.6 cfm
Total		<u>180.2</u>

Principal Ventilation Capacity 9.32.3.4(1)

Master bedroom	1 @ 31.8 cfm	31.8 cfm
Other bedrooms	3 @ 15.9 cfm	47.7 cfm
Total		<u>79.5</u>

Principal Exhaust Fan Capacity

Make	Model	Location
LifeBreath	RNC155	Base
132 cfm		Sones or Equiv.

Heat Recovery Ventilator

Make	LifeBreath
Model	RNC155
	132 cfm high 80 cfm low
Sensible efficiency @ -25 deg C	71%
Sensible efficiency @ 0 deg C	75%

Note: Installer to balance HRV/ERV to within 10 percent of PVC

Supplemental Ventilation Capacity

Total ventilation capacity	180.2
Less principal exhaust capacity	79.5
REQUIRED supplemental vent. Capacity	<u>100.7</u> cfm

Supplemental Fans 9.32.3.5.

Location	cfm	Model	Sones
Ens	50	XB50	0.3
Bath	50	XB50	0.3
Bath 2	50	XB50	0.3

all fans HVI listed Make Broan or Equiv.

Designer Certification

I hereby certify that this ventilation system has been designed in accordance with the Ontario Building Code.

Name David DaCosta

Signature



HRAI #

5190

BCIN #

32964

Date

March 23, 2018



2985 Drew Road, Suite 202, Mississauga, Ontario
 L4T 0A4 Tel: 905-671-9800 Fax: 647-494-9643
 e-mail dave@gtadesigns.ca

Energy Efficiency Design Summary: Prescriptive Method (Building Code Part 9, Residential)

Page 7
 Project # PJ-00204
 Layout # JB-04585

This form is used by a designer to demonstrate that the energy efficiency design of a house complies with the building code using the prescriptive method described in Subsection 3.1.1. of SB-12. This form is applicable where the ratio of gross area of windows/sidelights/skylights/glazing in doors and sliding glass doors to the gross area of peripheral walls is not more than 22%.

For use by Principal Authority

Application No:

Model/Certification Number

A. Project Information

Building number, street name	Rideau 1 Loft S42-1B Loft	Unit number	Lot/Con
Municipality	Bradford	Postal code	Reg. Plan number / other description

B. Prescriptive Compliance [indicate the building code compliance package being employed in the house design]

SB-12 Prescriptive (input design package):

Package A1

Table: 3.1.1.2.A

C. Project Design Conditions

Climatic Zone (SB-1):	Heat. Equip. Efficiency	Space Heating Fuel Source
☒ Zone 1 (< 5000 degree days) ☐ Zone 2 (≥ 5000 degree days)	☒ ≥ 92% AFUE ☐ ≥ 84% < 92% AFUE	☒ Gas ☐ Propane ☐ Solid Fuel ☐ Oil ☐ Electric ☐ Earth Energy
Ratio of Windows, Skylights & Glass (W, S & G) to Wall Area	Other Building Characteristics	
Area of Walls = <u>352.25</u> m ² or <u>3791.6</u> ft ²	W, S & G % = <u>11%</u>	☐ Log/Post&Beam ☐ ICF Above Grade ☐ ICF Basement ☐ Slab-on-ground ☐ Walkout Basement ☒ Air Conditioning ☐ Combo Unit
Area of W, S & G = <u>39.575</u> m ² or <u>426.0</u> ft ²	Utilize Window ☐ Yes Averaging ☒ No	☐ Air Sourced Heat Pump (ASHP) ☐ Ground Source Heat Pump (GSHP)

D. Building Specifications [provide values and ratings of the energy efficiency components proposed]

Energy Efficiency Substitutions			
☐ ICF (3.1.1.2.(5) & (6) / 3.1.1.3.(5)) ☐ Combined space heating and domestic water heating systems (3.1.1.2(7) / 3.1.1.3.(7))			
☐ Airtightness substitution(s) Airtightness test required (Refer to Design Guide Attached)	☐ Table 3.1.1.4.B Required:		Permitted Substitution:
	☐ Table 3.1.1.4.C Required:		Permitted Substitution:
Building Component	Minimum RSI/R-Values or Maximum U-Value ¹		Efficiency Ratings
Thermal Insulation	Nominal	Effective	Windows & Doors Provide U-Value ⁽¹⁾ or ER rating
Ceiling with Attic Space	60		Windows/Sliding Glass Doors 1.6
Ceiling without Attic Space	31		Skylights 2.8
Exposed Floor	31		Mechanicals
Walls Above Grade	22		Heating Equip.(AFUE) 96%
Basement Walls	20.0ci		HRV Efficiency (SRE% at 0°C) 75%
Slab (all >600mm below grade)	x		DHW Heater (EF) 0.80
Slab (edge only ≤600mm below grade)	10		DWHR (CSA B55.1 (min. 42% efficiency)) #Showers 2
Slab (all ≤600mm below grade, or heated)	10		Combined Heating System

(1) U value to be provided in either W/(m²·K) or Btu/(h·ft²·°F) but not both.

E. Designer(s) [name(s) & BCIN(s), if applicable, of person(s) providing information herein to substantiate that design meets building code]

Name	BCIN	Signature
David DaCosta	32964	

Package: **Package A1** System: **System 1**
Project: **Bradford** Model: **S42-1B Loft**

Air Leakage Calculations

Building Air Leakage Heat Loss				
B	LRairh	Vb	HL ^Δ T	HL _{leak}
0.018	0.328	38268	81.4	18408

Building Air Leakage Heat Gain				
B	LRairh	Vb	HG ^Δ T	HG _{Leak}
0.018	0.081	38268	11	612

Air Leakage Heat Loss/Gain Multiplier Table (Section 11)				
Level	Level Factor (LF)	Building Air	Level Conductive Heat Loss	Air Leakage Heat Loss Multiplier
Level 1	0.5	18408	10179	0.9042
Level 2	0.3		18140	0.3044
Level 3	0.2		6003	0.6133
Level 4	0		0	0.0000

Levels			
1	2	3	4
(LF)	(LF)	(LF)	(LF)
1.0	0.6	0.5	0.4
	0.4	0.3	0.3
		0.2	0.2
			0.1

HG LEAK		Air Leakage Heat Gain	
	612		0.0453
BUILDING CONDUCTIVE HEAT GAIN		13509	

Levels this Dwelling	
3	

Ventilation Calculations

Vent	Ventilation Heat Loss					Ventilation Heat Gain				Vent	
	Ventilation Heat Loss					Ventilation Heat Gain					
	C	PVC	HL^T	(1-E) HRV	HLbvent	C	PVC	HG^T	HGbvent		
	1.08	79.5	81.4	0.16	1118	1.1	79.5	11	944		
Case 1						Case 1					
Case 1	Ventilation Heat Loss (Exhaust only Systems)					Ventilation Heat Gain (Exhaust Only Systems)					Case 1
	Case 1 - Exhaust Only					Case 1 - Exhaust Only		Multiplier			
	Level	LF	HLbvent	LVL Cond. HL	Multiplier	HGbvent	944	0.07			
	Level 1	0.5	1118	10179	0.05	Building	13509				
	Level 2	0.3		18140	0.02						
	Level 3	0.2		6003	0.04						
Level 4	0	0		0.00							
Case 2						Case 2					
Case 2	Ventilation Heat Loss (Direct Ducted Systems)					Ventilation Heat Gain (Direct Ducted Systems)					Case 2
				Multiplier				Multiplier			
	C	HL^T	(1-E) HRV	14.07		C	HG^T	11.88			
	1.08	81.4	0.16			1.08	11				
Case 3						Case 3					
Case 3	Ventilation Heat Loss (Forced Air Systems)					Ventilation Heat Gain (Forced Air Systems)					Case 3
			HLbvent	Multiplier				Vent Heat Gain	Multiplier		
	Total Ventilation Load		1118	0.03		HGbvent	HG*1.3	944	0.07		
						944	1				

Foundation Conductive Heatloss Level 1

2542 Watts 8674 Btu/h

Foundation Conductive Heatloss Level 2

Watts Btu/h

I review and take responsibility for the design work and am qualified in the appropriate category as an "other designer" under Division C subsection 3.2.5. of the Building Code. Individual BCIN: 32964

David DaCosta


Envelope Air Leakage Calculator


Supplemental tool for CAN/CSA-F280


Weather Station Description				
Province:	Ontario ▼			
Region:	Bradford ▼			
Weather Station Location:	Open flat terrain, grass ▼			
Anemometer height (m):	10			
Local Shielding				
Building Site:	Suburban, forest ▼			
Walls:	Heavy ▼			
Flue:	Heavy ▼			
Highest Ceiling Height (m):	6.64			
Building Configuration				
Type:	Detached			
Number of Stories:	One & Half			
Foundation:	Full			
House Volume (m ³):	1083.75			
Air Leakage/Ventilation				
Air Tightness Type:	Present (1961-) (ACH=3.57)			
Custom BDT Data:	ELA @ 10 Pa. ▼	322.44 cm ²		
	3.57	ACH @ 50 Pa		
Mechanical Ventilation (L/s):	Total Supply:	Total Exhaust:		
	39.75	39.75		
Flue #:	#1	#2	#3	#4
Diameter (mm):	0	0	0	0
Heating Air Leakage Rate (ACH/H): 0.328				
Cooling Air Leakage Rate (ACH/H): 0.081				

Residential Foundation Thermal Load Calculator

Supplemental tool for CAN/CSA-F280

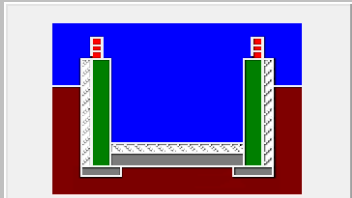Weather Station Description		
Province:	Ontario ▼	
Region:	Bradford ▼	
Site Description		
Soil Conductivity:	High conductivity: moist soil ▼	
Water Table:	Normal (7-10 m, 23-33 Ft) ▼	
Foundation Dimensions		
Floor Length (m):	25.46	 Insulation Configuration
Floor Width (m):	5.93	
Exposed Perimeter (m):	62.79	
Wall Height (m):	2.74	
Depth Below Grade (m):	1.59	
Window Area (m ²):	4.37	
Door Area (m ²):	1.95	
Radiant Slab		
Heated Fraction of the Slab:	0	
Fluid Temperature (°C):	33	
Design Months		
Heating Month	1	
Foundation Loads		
Heating Load (Watts):		2542

 	FLEX DUCT		LOW/HIGH WALL/KICK SUPPLY DIFFUSER		DUCT CONNECTION TO JOIST LINING		RETURN AIR GRILLE (SIZE INDICATED ON DRAWING)	S.A.	SUPPLY AIR
	RIGID ROUND DUCT		HRV EXHAUST GRILLE		RETURN AIR PIPE RISER		RETURN AIR RISER UP TO FLOOR ABOVE	R.A.	RETURN AIR
	SUPPLY DIFFUSER		SUPPLY AIR PIPE RISER		RETURN ROUND DUCT		RETURN AIR FROM BASEMENT SECOND FLOOR		THERMOSTAT
			VOLUME DAMPER						PRINCIPAL EXHAUST FAN SWITCH
									W/R & PRINCIPAL EXHAUST FAN

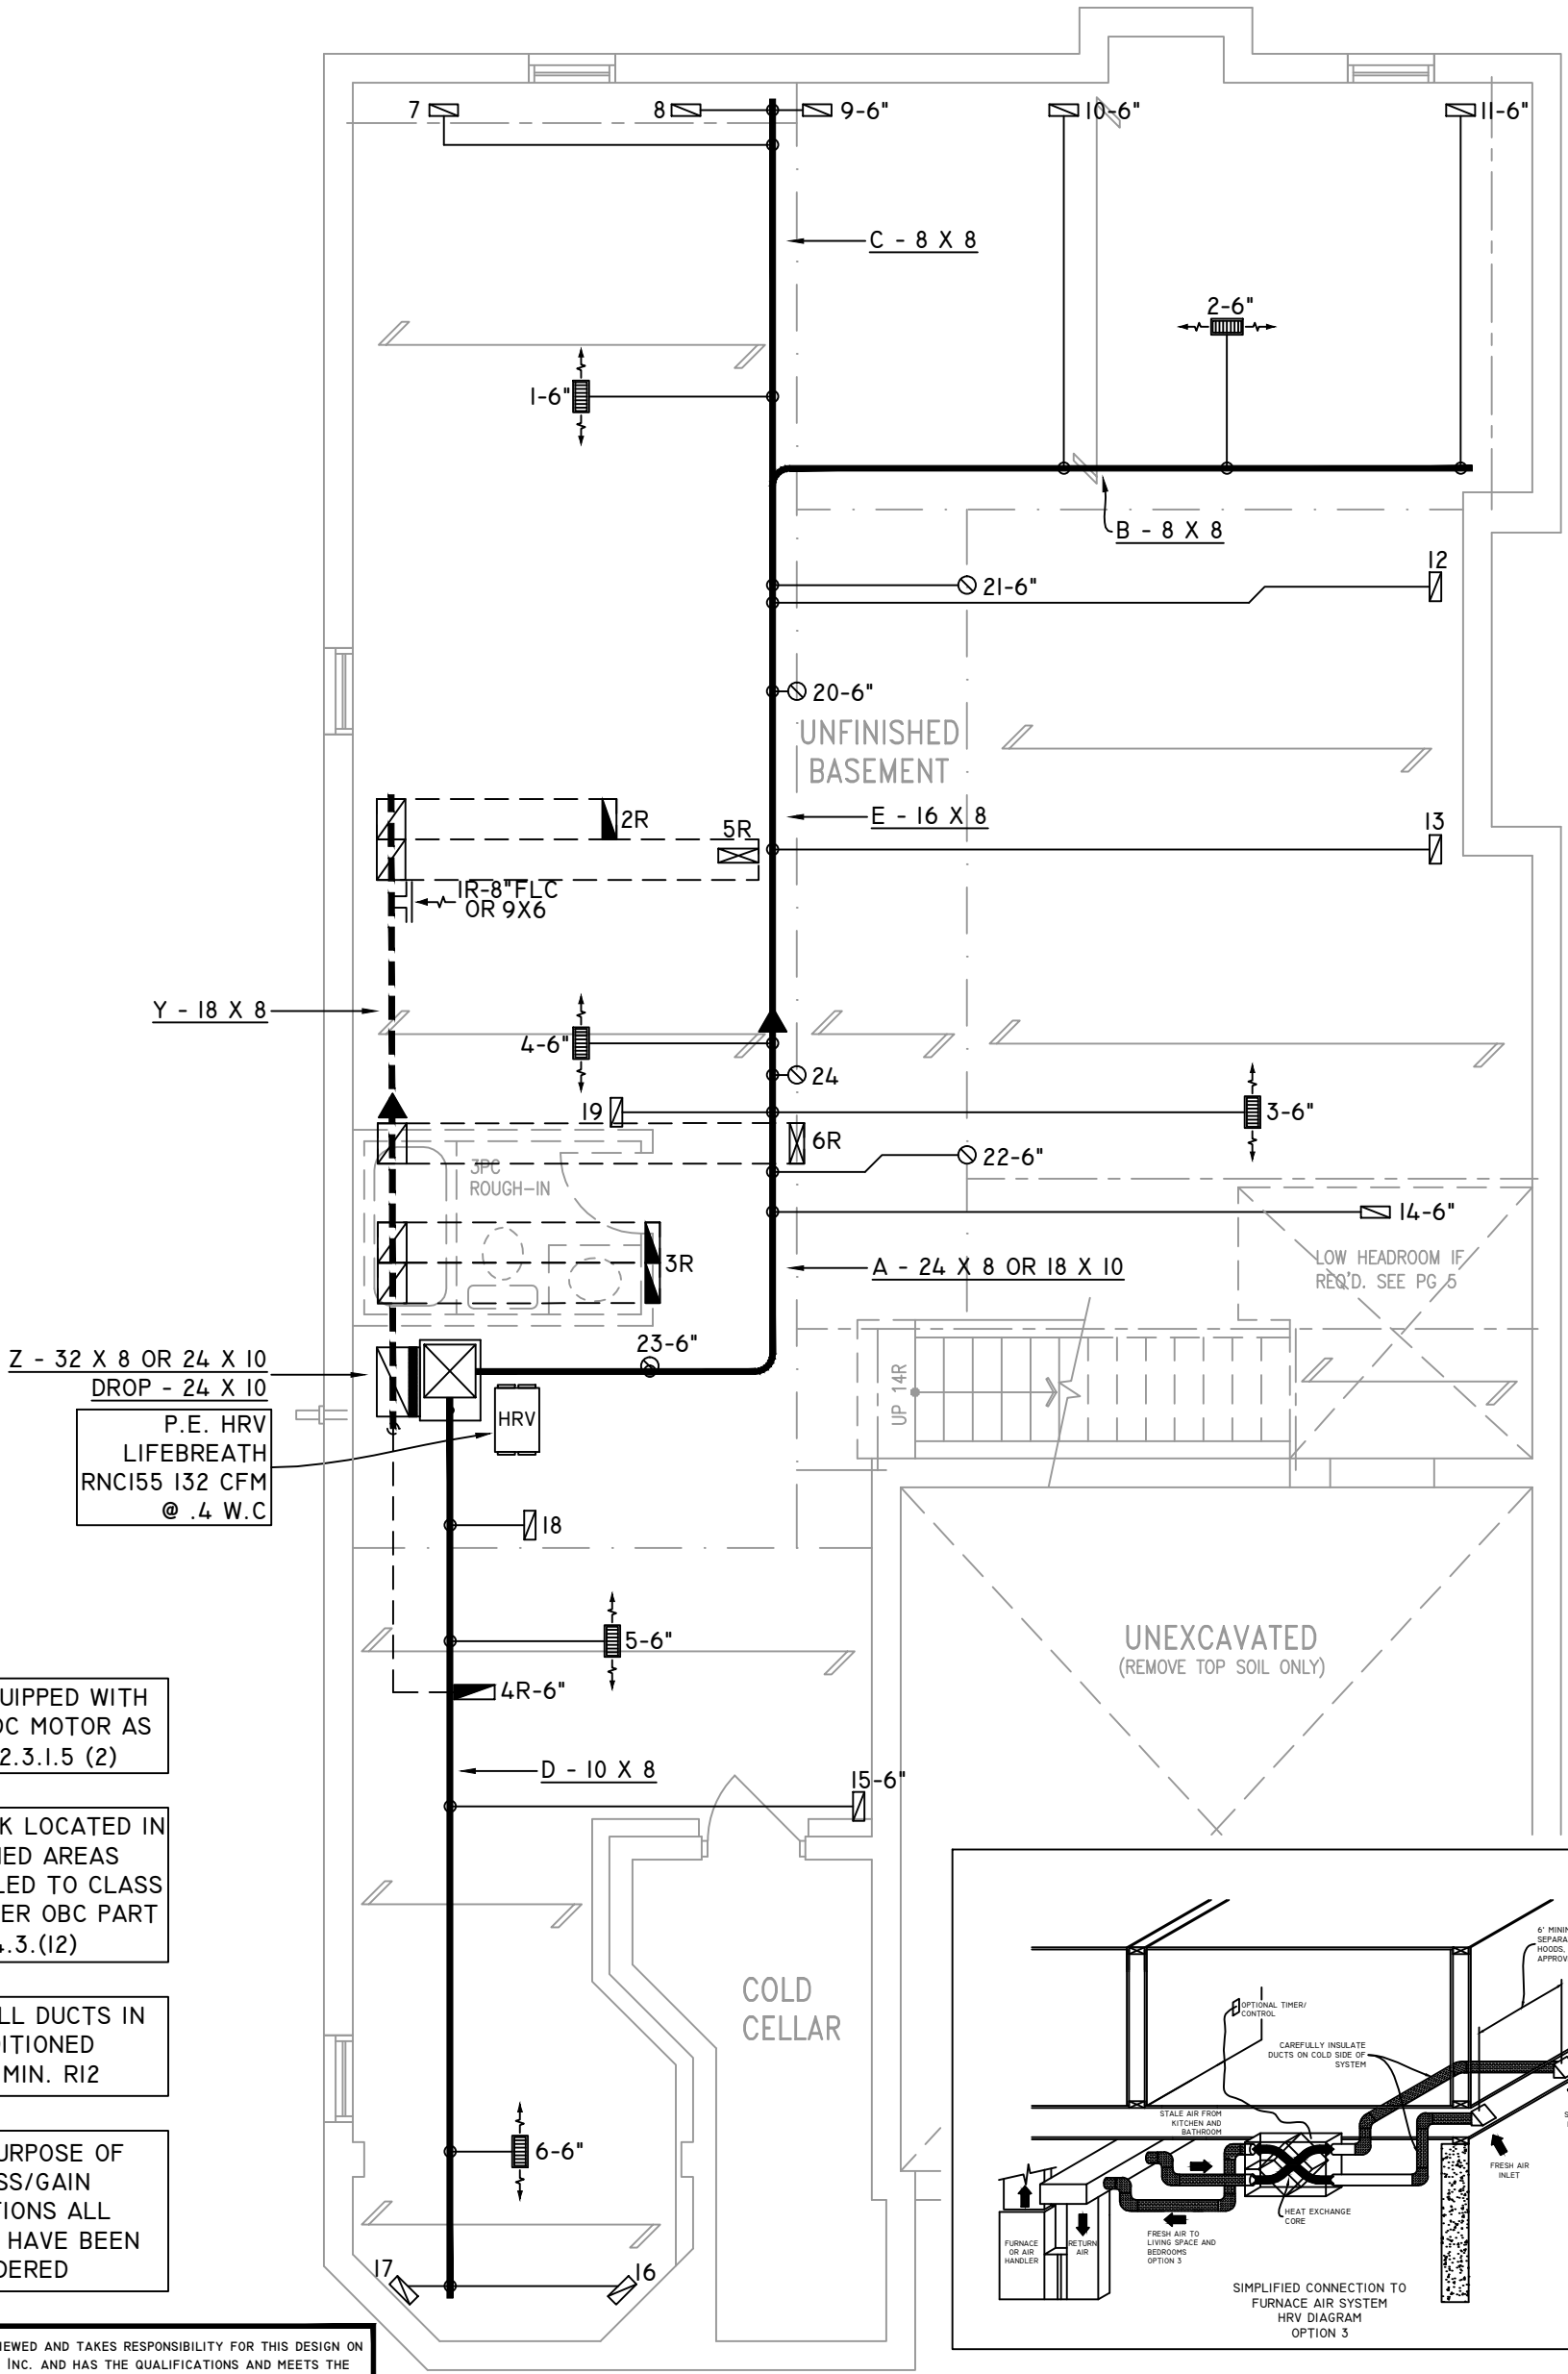

FURNACE EQUIPPED WITH
BRUSHLESS DC MOTOR AS
PER OBC 12.3.1.5 (2)

ALL DUCTWORK LOCATED IN
CONDITIONED AREAS
MUST BE SEALED TO CLASS
C LEVEL AS PER OBC PART
6-6.2.4.3.(12)

INSULATE ALL DUCTS IN
UNCONDITIONED
SPACES MIN. R12

FOR THE PURPOSE OF
HEATLOSS/GAIN
CALCULATIONS ALL
ELEVATIONS HAVE BEEN
CONSIDERED

THE UNDERSIGNED HAS REVIEWED AND TAKES RESPONSIBILITY FOR THIS DESIGN ON
BEHALF OF GTA DESIGNS INC. AND HAS THE QUALIFICATIONS AND MEETS THE
REQUIREMENTS SET OUT IN THE BUILDING CODE TO BE A DESIGNER

QUALIFICATION INFORMATION

REQUIRED UNLESS DESIGN IS EXEMPT UNDER DIVISION C 3.2.5.1 OF THE
ONTARIO BUILDING CODE

DAVID DA COSTA  B.C.I.N. 32964
SIGNATURE OF DESIGNER

BASEMENT PLAN 'A'

OBC 2012

ZONE I COMPLIANCE
PACKAGE "A1" REF. TABLE 3.1.1.2.A

NOTES

INSTALLATION TO COMPLY WITH THE LATEST ONTARIO BUILDING CODE.

ALL SUPPLY OUTLETS TO BE 5" DIA. UNLESS OTHERWISE SPECIFIED.

PROVIDE BALANCING DAMPERS ON ALL BRANCHES.

ALL R/A PARTITIONS 6" (FIRST FLOOR ONLY)

INSULATE DUCTS IN UNCONDITIONED SPACES R12 UNDERCUT ALL DOORS 1" MIN.

CONTRACTOR MUST WORK FROM APPROVED PLANS.

ANY ALTERATIONS TO THIS ORIGINAL PLAN ARE NOT THE RESPONSIBILITY OF GTA DESIGNS.

GTA DESIGNS MUST BE CONSULTED IF KITCHEN EXHAUST FAN EXCEEDS 700 CFM DEPRESSURIZATION MAY OCCUR WITH IN THE DWELLING.



2985 DREW ROAD
SUITE 202,
MISSISSAUGA, ONT.
L4T 0A4 TEL: 905-671-9800
EMAIL: DAVE@GTADESIGNS.CA
WEB: WWW.GTADESIGNS.CA



HEAT-LOSS	53,848	BTU/HR.
UNIT MAKE	AMANA	OR EQUAL.
UNIT MODEL	AMEC960603BNA	OR EQUAL.
UNIT HEATING INPUT	60,000	BTU/HR.
UNIT HEATING OUTPUT	57,600	BTU/HR.
A/C COOLING CAPACITY	2.5	TONS.
FAN SPEED	1170	CFM


# OF RUNS	S/A	R/A	FANS
3RD FLOOR			
2ND FLOOR	5	2	1
1ST FLOOR	13	3	4
BASEMENT	6	1	

FLOOR PLAN:	BASEMENT
DRAWN BY:	AM
CHECKED:	DD
LAYOUT NO.	JB-04585
SQFT	2818
DRAWING NO.	MI

DATE:	MARCH 23, 2018
CLIENT:	BAYVIEW WELLINGTON
MODEL:	S42-IB LOFT RIDEAU I LOFT
PROJECT:	GREEN VALLEY EAST BRADFORD,ONT.
SCALE:	3/16" = 1'-0"

  Site Copy

	FLEX DUCT		LOW/HIGH WALL/KICK SUPPLY DIFFUSER		DUCT CONNECTION TO JOIST LINING		RETURN AIR GRILLE (SIZE INDICATED ON DRAWING)	S.A.	SUPPLY AIR
	RIGID ROUND DUCT		HRV EXHAUST GRILLE		RETURN AIR PIPE RISER		RETURN AIR RISER UP TO FLOOR ABOVE	R.A.	RETURN AIR
	SUPPLY DIFFUSER		SUPPLY AIR PIPE RISER		RETURN ROUND DUCT		RETURN AIR FROM BASEMENT SECOND FLOOR		THERMOSTAT
			VOLUME DAMPER						PRINCIPAL EXHAUST FAN SWITCH W/R & PRINCIPAL EXHAUST FAN

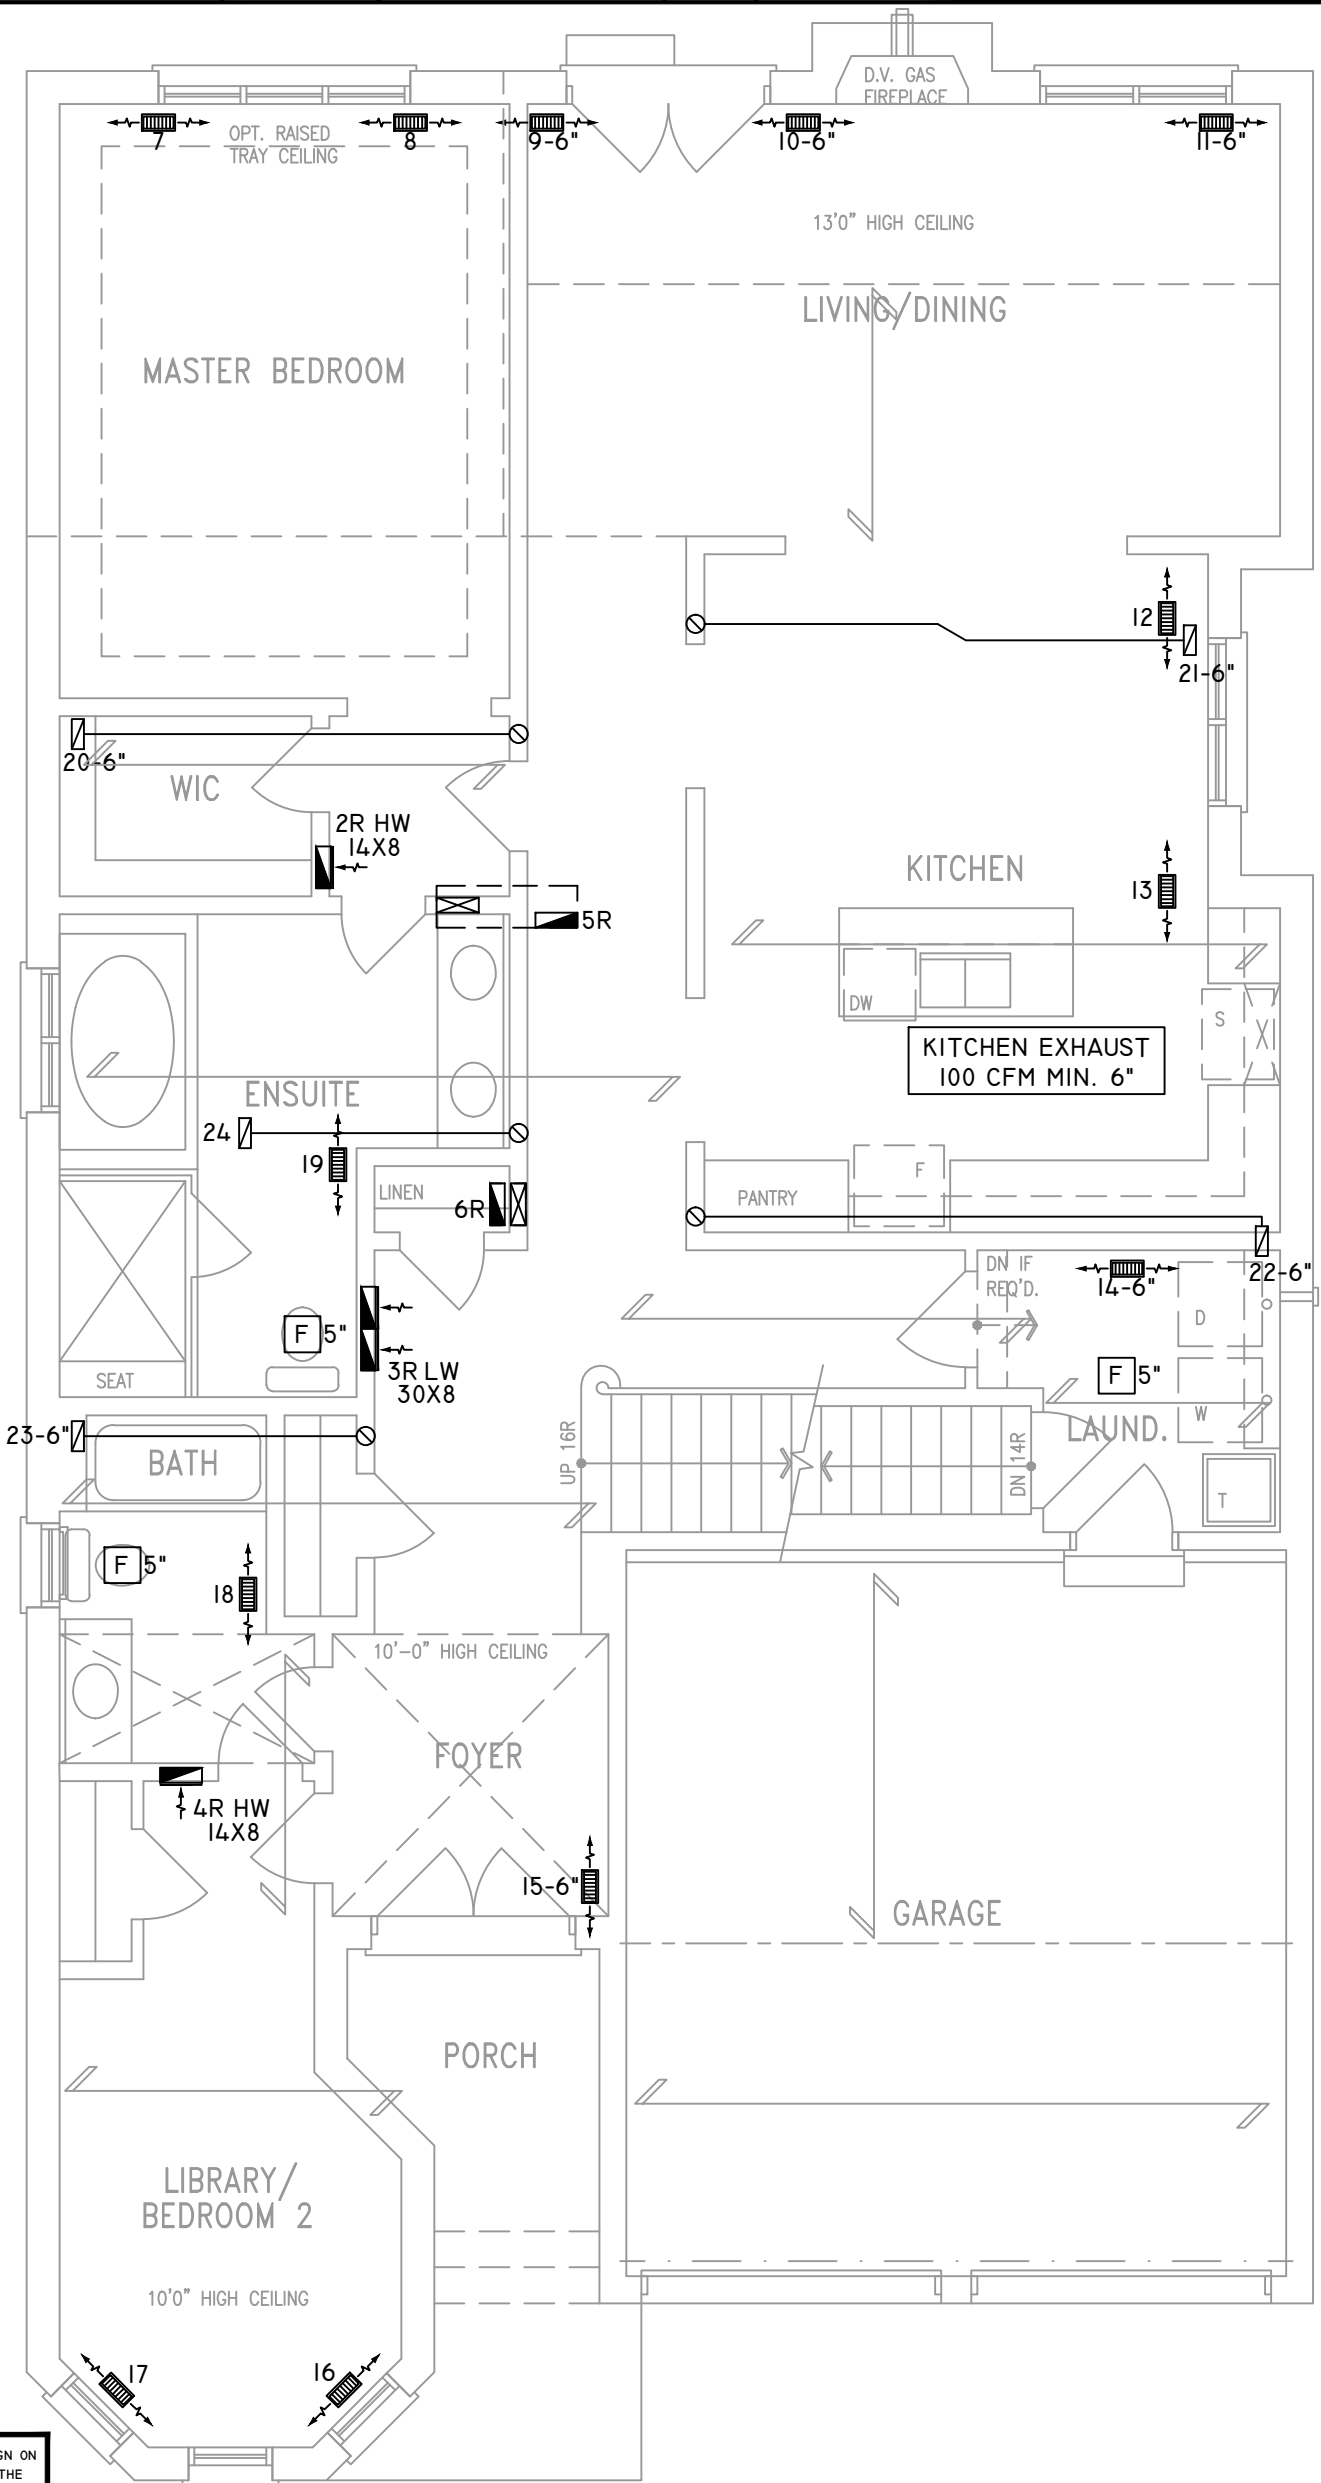


- CIRCULATION PRINCIPAL FAN SWITCH TO BE CENTRALLY LOCATED
- ALL DUCTWORK LOCATED IN CONDITIONED AREAS MUST BE SEALED TO CLASS C LEVEL AS PER OBC PART 6-6.2.4.3.(12)
- INSULATE ALL DUCTS IN UNCONDITIONED SPACES MIN. R12
- FOR THE PURPOSE OF HEATLOSS/GAIN CALCULATIONS ALL ELEVATIONS HAVE BEEN CONSIDERED

THE UNDERSIGNED HAS REVIEWED AND TAKES RESPONSIBILITY FOR THIS DESIGN ON BEHALF OF GTA DESIGNS INC. AND HAS THE QUALIFICATIONS AND MEETS THE REQUIREMENTS SET OUT IN THE BUILDING CODE TO BE A DESIGNER

QUALIFICATION INFORMATION

 REQUIRED UNLESS DESIGN IS EXEMPT UNDER DIVISION C 3.2.5.1 OF THE ONTARIO BUILDING CODE

DAVID DA COSTA  B.C.I.N. 32964

SIGNATURE OF DESIGNER

GROUND FLOOR PLAN 'A'

OBC 2012

ZONE I COMPLIANCE
PACKAGE "A1" REF. TABLE 3.1.1.2.A

NOTES
INSTALLATION TO COMPLY WITH THE LATEST ONTARIO BUILDING CODE.
ALL SUPPLY OUTLETS TO BE 5" DIA. UNLESS OTHERWISE SPECIFIED.
PROVIDE BALANCING DAMPERS ON ALL BRANCHES.
ALL R/A PARTITIONS 6" (FIRST FLOOR ONLY)
INSULATE DUCTS IN UNCONDITIONED SPACES R12 UNDERCUT ALL DOORS 1" MIN.
CONTRACTOR MUST WORK FROM APPROVED PLANS.
ANY ALTERATIONS TO THIS ORIGINAL PLAN ARE NOT THE RESPONSIBILITY OF GTA DESIGNS.
GTA DESIGNS MUST BE CONSULTED IF KITCHEN EXHAUST FAN EXCEEDS 700 CFM DEPRESSURIZATION MAY OCCUR WITH IN THE DWELLING.




2985 DREW ROAD
SUITE 202,
MISSISSAUGA, ONT.
L4T 0A4 TEL: 905-671-9800
EMAIL: DAVE@GTADISIGNS.CA
WEB: WWW.GTADISIGNS.CA


HEAT-LOSS	53,848	BTU/HR.
UNIT MAKE	AMANA	OR EQUAL.
UNIT MODEL	AMEC960603BNA	OR EQUAL.
UNIT HEATING INPUT	60,000	BTU/HR.
UNIT HEATING OUTPUT	57,600	BTU/HR.
A/C COOLING CAPACITY	2.5	TONS.
FAN SPEED	1170	CFM

# OF RUNS	S/A	R/A	FANS
3RD FLOOR			
2ND FLOOR	5	2	1
1ST FLOOR	13	3	4
BASEMENT	6	1	

FLOOR PLAN: GROUND FLOOR	
DRAWN BY: AM	CHECKED: DD
LAYOUT NO. JB-04585	DRAWING NO. M2

 DATE:	MARCH 23, 2018
CLIENT:	BAYVIEW WELLINGTON
MODEL:	S42-IB LOFT RIDEAU I LOFT
PROJECT:	GREEN VALLEY EAST BRADFORD,ONT.
SCALE:	3/16" = 1'-0"

	FLEX DUCT		LOW/HIGH WALL/KICK SUPPLY DIFFUSER		DUCT CONNECTION TO JOIST LINING		RETURN AIR GRILLE (SIZE INDICATED ON DRAWING)	S.A. R.A. T \$ F PE	SUPPLY AIR RETURN AIR THERMOSTAT PRINCIPAL EXHAUST FAN SWITCH W/R & PRINCIPAL EXHAUST FAN
	RIGID ROUND DUCT		HRV EXHAUST GRILLE		RETURN AIR PIPE RISER		RETURN AIR RISER UP TO FLOOR ABOVE		
	SUPPLY DIFFUSER		SUPPLY AIR PIPE RISER		RETURN ROUND DUCT		RETURN AIR FROM BASEMENT SECOND FLOOR		

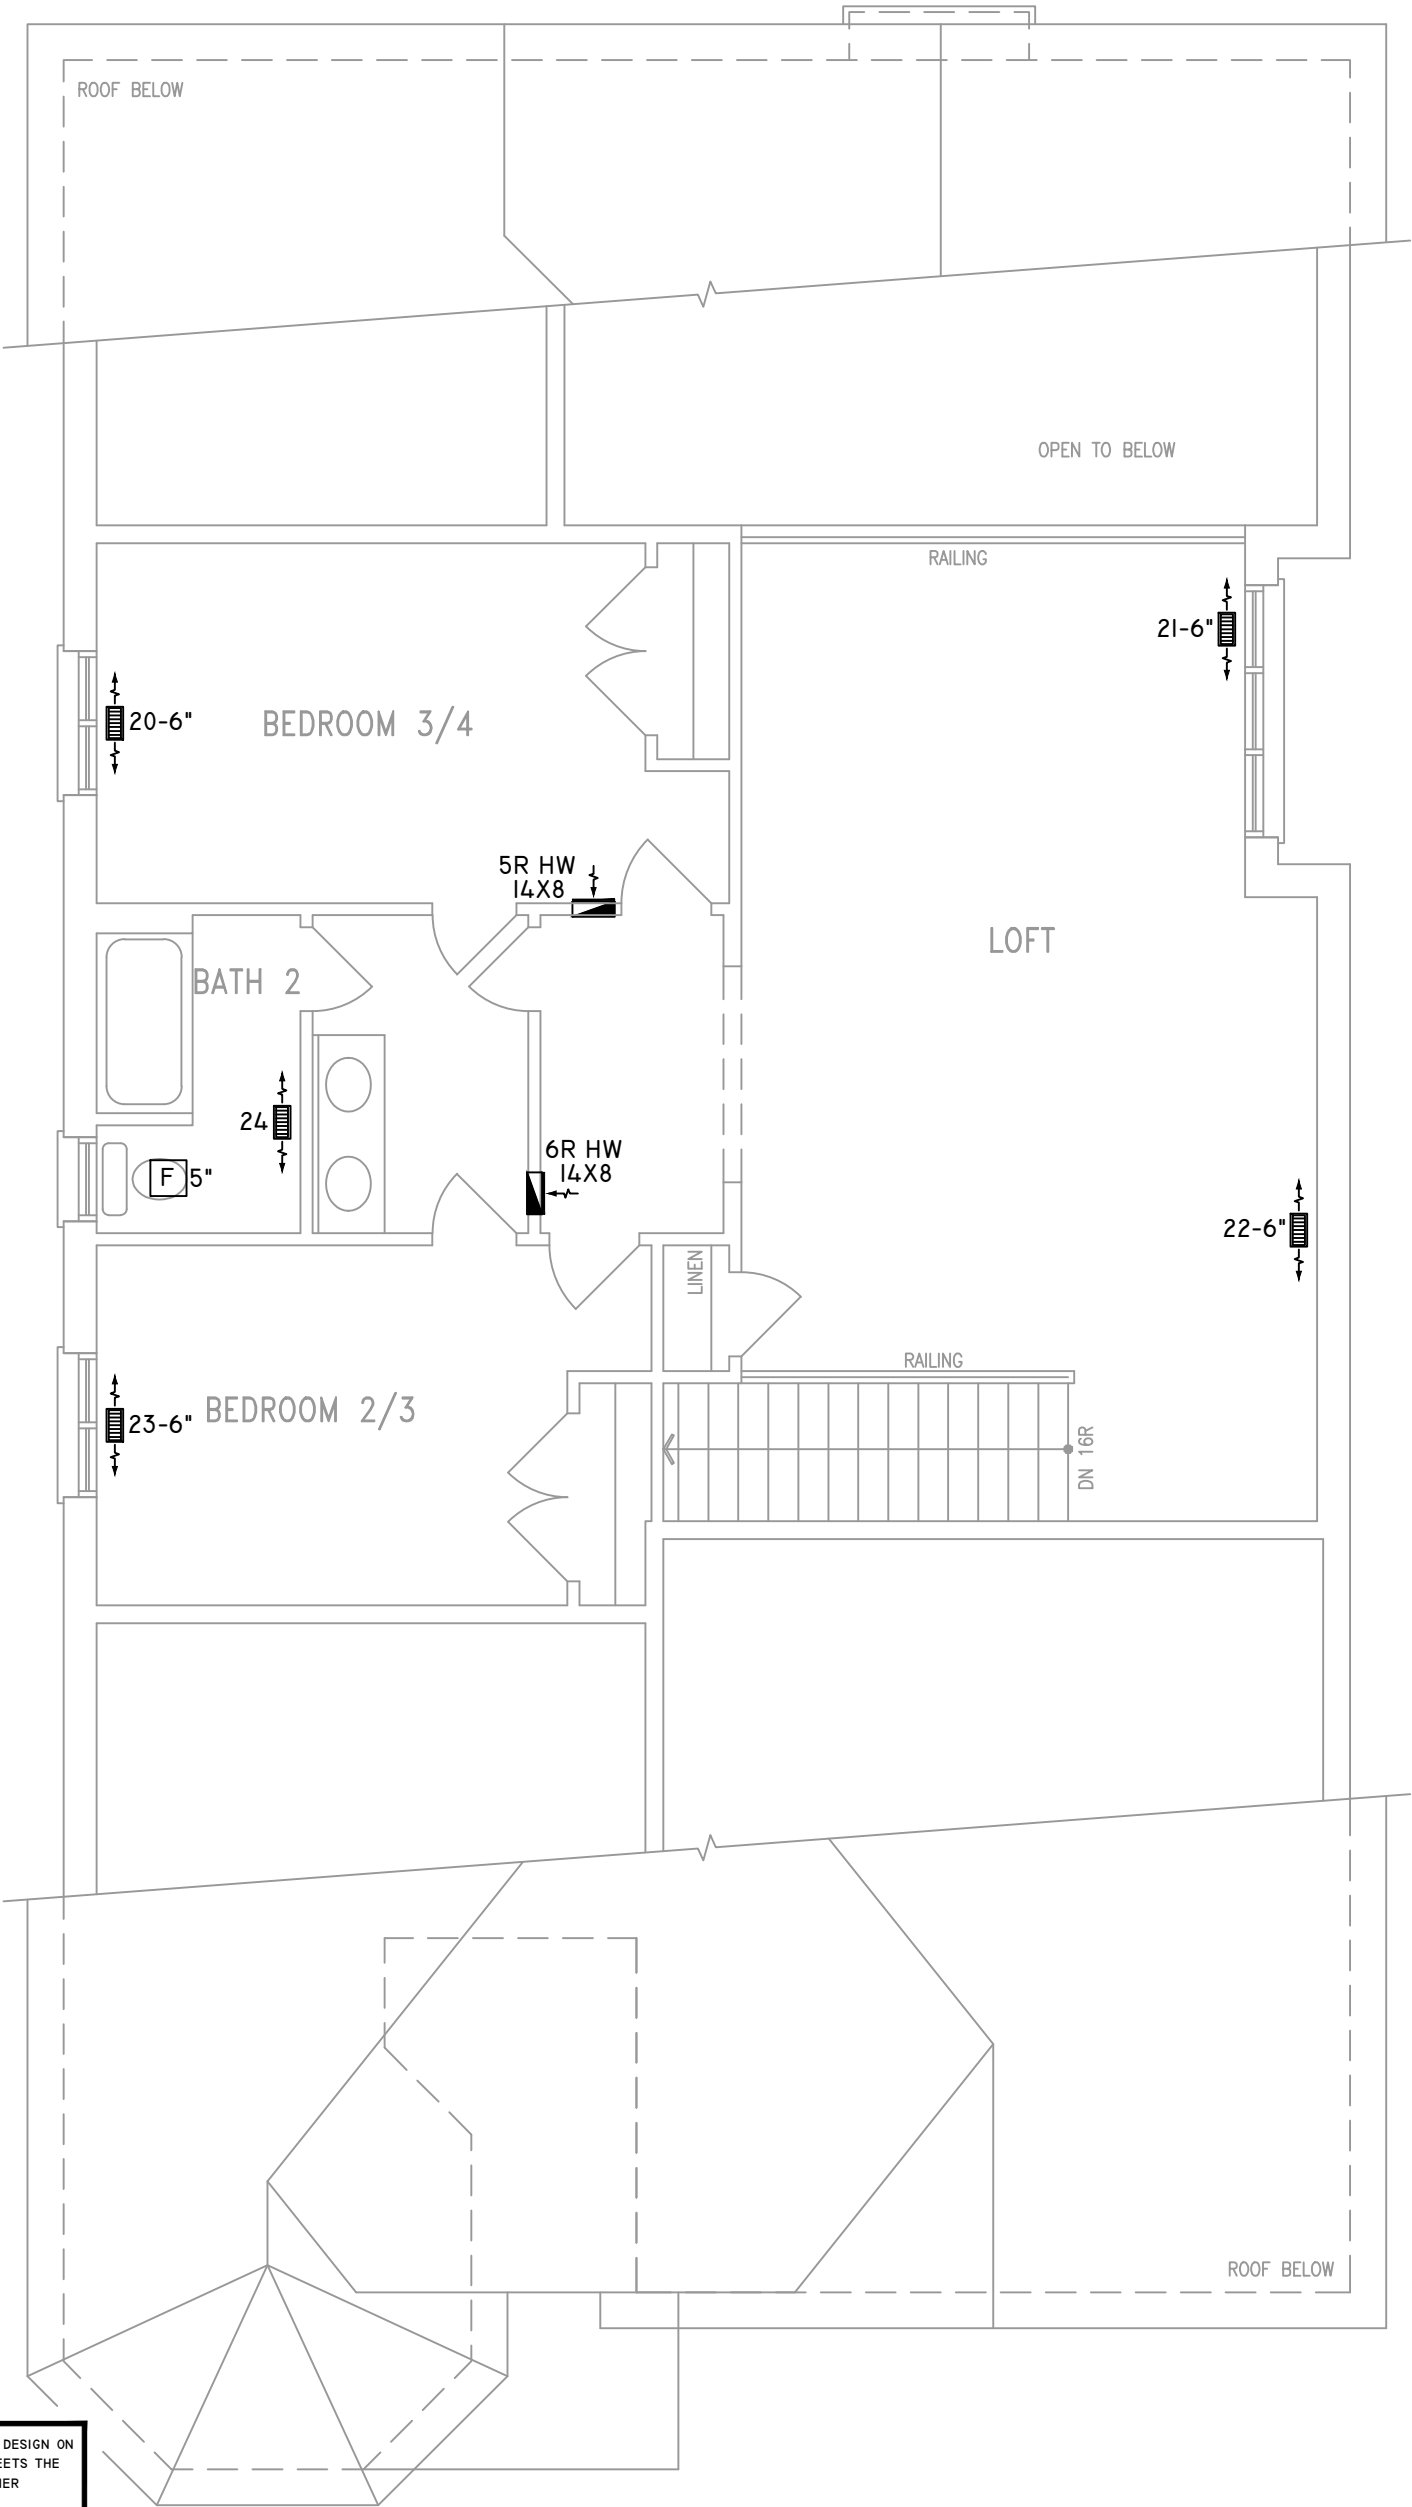

ALL DUCTWORK LOCATED IN
CONDITIONED AREAS
MUST BE SEALED TO CLASS
C LEVEL AS PER OBC PART
6-6.2.4.3.(12)

INSULATE ALL DUCTS IN
UNCONDITIONED
SPACES MIN. R12

FOR THE PURPOSE OF
HEATLOSS/GAIN
CALCULATIONS ALL
ELEVATIONS HAVE BEEN
CONSIDERED

THE UNDERSIGNED HAS REVIEWED AND TAKES RESPONSIBILITY FOR THIS DESIGN ON
BEHALF OF GTA DESIGNS INC. AND HAS THE QUALIFICATIONS AND MEETS THE
REQUIREMENTS SET OUT IN THE BUILDING CODE TO BE A DESIGNER

QUALIFICATION INFORMATION

REQUIRED UNLESS DESIGN IS EXEMPT UNDER DIVISION C 3.2.5.1 OF THE
ONTARIO BUILDING CODE

DAVID DA COSTA  B.C.I.N. 32964
SIGNATURE OF DESIGNER

LOFT FLOOR PLAN – EL. 'A'

OBC 2012

ZONE I COMPLIANCE
PACKAGE "A1" REF. TABLE 3.1.1.2.A

NOTES

INSTALLATION TO COMPLY WITH THE LATEST ONTARIO
BUILDING CODE.

ALL SUPPLY OUTLETS TO BE 5" DIA. UNLESS OTHERWISE
SPECIFIED.

PROVIDE BALANCING DAMPERS ON ALL BRANCHES.

ALL R/A PARTITIONS 6" (FIRST FLOOR ONLY)

INSULATE DUCTS IN UNCONDITIONED SPACES R12 UNDERCUT
ALL DOORS 1" MIN.

CONTRACTOR MUST WORK FROM APPROVED PLANS.

ANY ALTERATIONS TO THIS ORIGINAL PLAN ARE NOT THE
RESPONSIBILITY OF GTA DESIGNS.

GTA DESIGNS MUST BE CONSULTED IF KITCHEN EXHAUST
FAN EXCEEDS 700 CFM DEPRESSURIZATION MAY OCCUR
WITH IN THE DWELLING.



2985 DREW ROAD
SUITE 202,
MISSISSAUGA, ONT.
L4T 0A4 TEL: 905-671-9800
EMAIL: DAVE@GTADESIGNS.CA
WEB: WWW.GTADESIGNS.CA


HEAT-LOSS	53,848	BTU/HR.
UNIT MAKE	AMANA	OR EQUAL.
UNIT MODEL	AMEC960603BNA	OR EQUAL.
UNIT HEATING INPUT	60,000	BTU/HR.
UNIT HEATING OUTPUT	57,600	BTU/HR.
A/C COOLING CAPACITY	2.5	TONS.
FAN SPEED	1170	CFM


# OF RUNS	S/A	R/A	FANS
3RD FLOOR			
2ND FLOOR	5	2	1
1ST FLOOR	13	3	4
BASEMENT	6	1	

FLOOR PLAN: SECOND FLOOR		
DRAWN BY: AM	CHECKED: DD	SQFT 2818
LAYOUT NO. JB-04585	DRAWING NO. M3	

DATE: MARCH 23, 2018
CLIENT: BAYVIEW WELLINGTON
MODEL: S42-IB LOFT RIDEAU I LOFT
PROJECT: GREEN VALLEY EAST BRADFORD,ONT.
SCALE: 3/16" = 1'-0"

 
Site Copy

	FLEX DUCT		LOW/HIGH WALL/KICK SUPPLY DIFFUSER		DUCT CONNECTION TO JOIST LINING		RETURN AIR GRILLE (SIZE INDICATED ON DRAWING)	S.A.	SUPPLY AIR
	RIGID ROUND DUCT		HRV EXHAUST GRILLE		RETURN AIR PIPE RISER		RETURN AIR RISER UP TO FLOOR ABOVE	R.A.	RETURN AIR
	SUPPLY DIFFUSER		SUPPLY AIR PIPE RISER		RETURN ROUND DUCT		RETURN AIR FROM BASEMENT SECOND FLOOR		THERMOSTAT
			VOLUME DAMPER						PRINCIPAL EXHAUST FAN SWITCH
									W/R & PRINCIPAL EXHAUST FAN

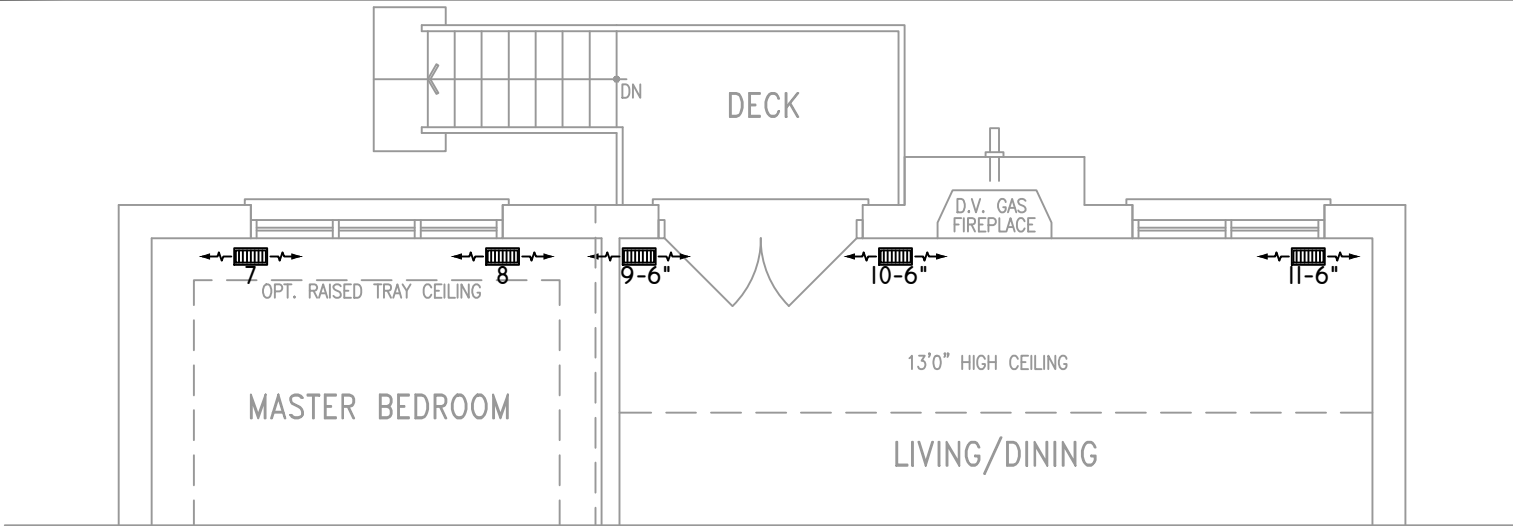


PART GROUND FLOOR PLAN 'A' – W.O.D. CONDITION

ELEVS 'B' & 'C' SIMILAR

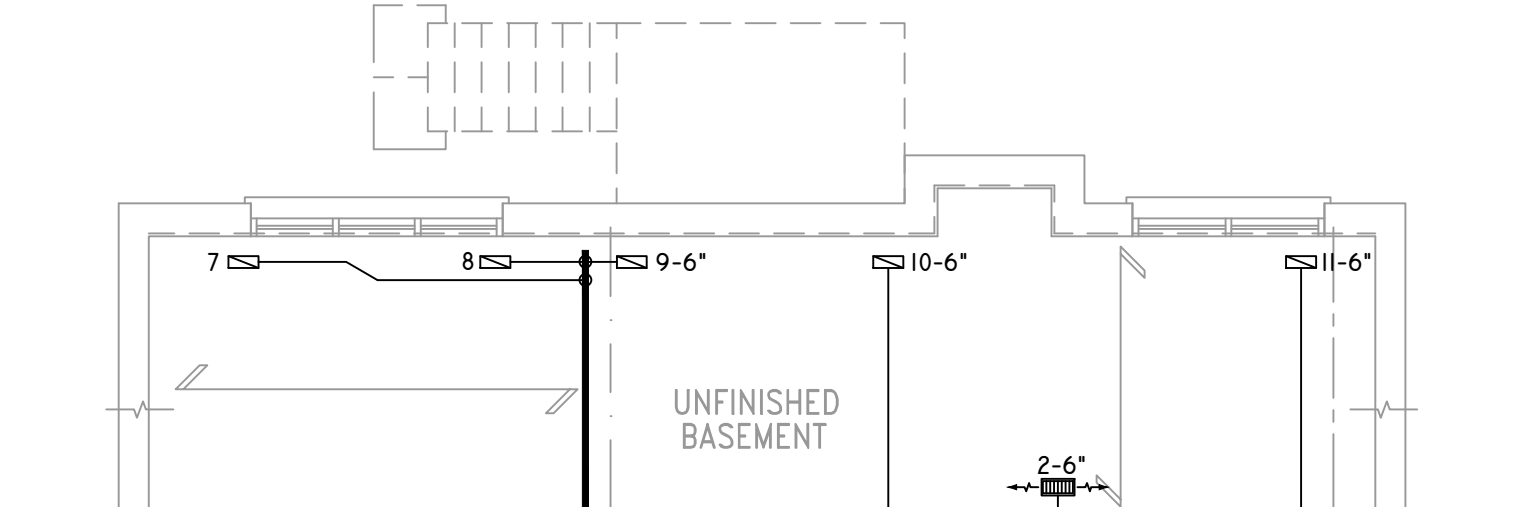


PART. BASEMENT PLAN 'A' – W.O.D. CONDITION

ELEVS 'B' & 'C' SIMILAR

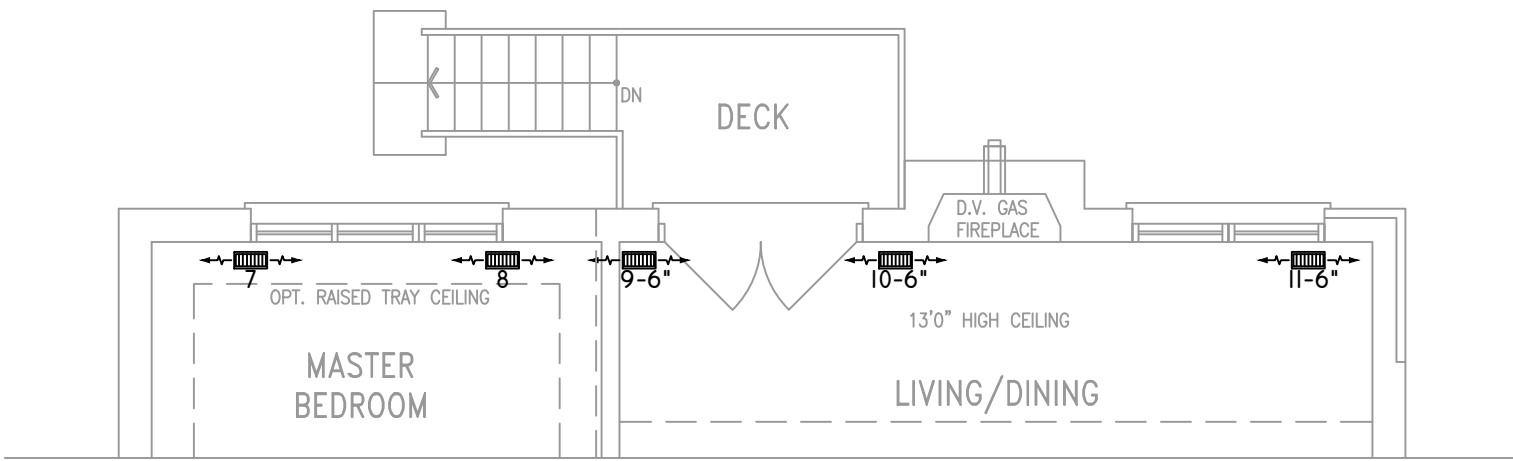

PARTIAL GROUND FLOOR PLAN ELEVATION 'C'
REAR UPGRADE WOD COND.

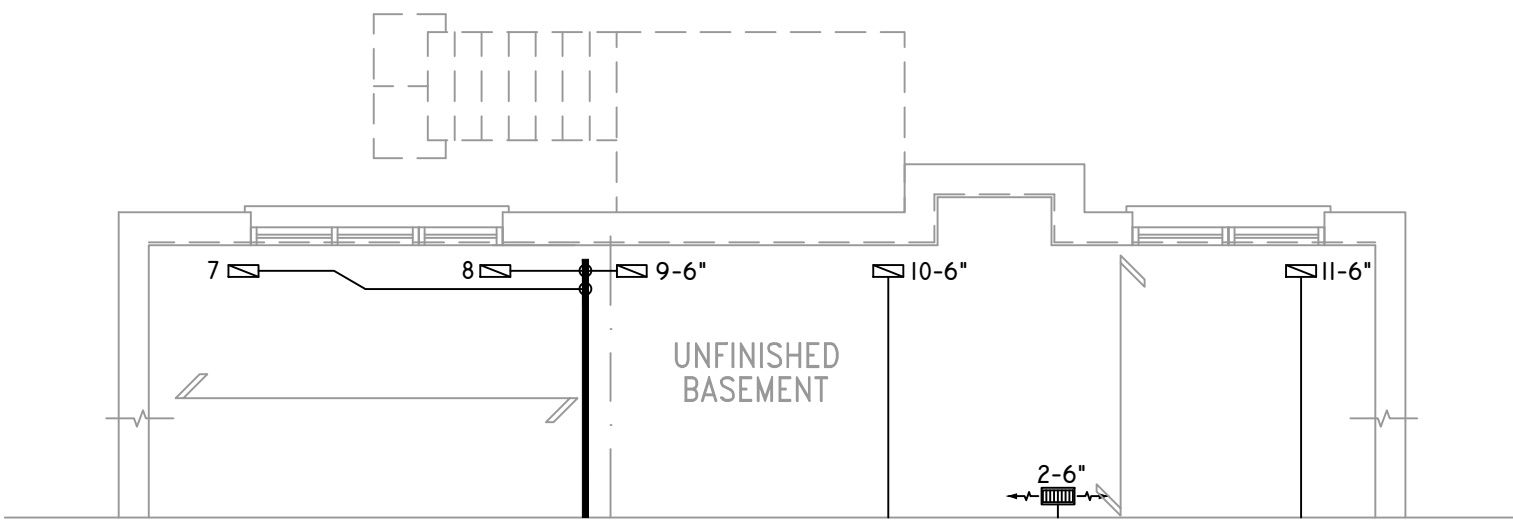

PART. BASEMENT PLAN ELEVATION 'C'
REAR UPG W.O.D. CONDITION

THE UNDERSIGNED HAS REVIEWED AND TAKES RESPONSIBILITY FOR THIS DESIGN ON BEHALF OF GTA DESIGNS INC. AND HAS THE QUALIFICATIONS AND MEETS THE REQUIREMENTS SET OUT IN THE BUILDING CODE TO BE A DESIGNER

QUALIFICATION INFORMATION

REQUIRED UNLESS DESIGN IS EXEMPT UNDER DIVISION C 3.2.5.1 OF THE ONTARIO BUILDING CODE

DAVID DA COSTA



B.C.I.N. 32964

SIGNATURE OF DESIGNER

OBC 2012

ZONE I COMPLIANCE
PACKAGE "A1" REF. TABLE 3.1.1.2.A

NOTES
INSTALLATION TO COMPLY WITH THE LATEST ONTARIO BUILDING CODE.
ALL SUPPLY OUTLETS TO BE 5" DIA. UNLESS OTHERWISE SPECIFIED.
PROVIDE BALANCING DAMPERS ON ALL BRANCHES.
ALL R/A PARTITIONS 6" (FIRST FLOOR ONLY)
INSULATE DUCTS IN UNCONDITIONED SPACES R12 UNDERCUT ALL DOORS 1" MIN.
CONTRACTOR MUST WORK FROM APPROVED PLANS.
ANY ALTERATIONS TO THIS ORIGINAL PLAN ARE NOT THE RESPONSIBILITY OF GTA DESIGNS.
GTA DESIGNS MUST BE CONSULTED IF KITCHEN EXHAUST FAN EXCEEDS 700 CFM DEPRESSURIZATION MAY OCCUR WITH IN THE DWELLING.



2985 DREW ROAD
SUITE 202,
MISSISSAUGA, ONT.
L4T 0A4 TEL: 905-671-9800
EMAIL: DAVE@GTADESIGNS.CA
WEB: WWW.GTADESIGNS.CA


HEAT-LOSS	53,848	BTU/HR.
UNIT MAKE	AMANA	OR EQUAL.
UNIT MODEL	AMEC960603BNA	OR EQUAL.
UNIT HEATING INPUT	60,000	BTU/HR.
UNIT HEATING OUTPUT	57,600	BTU/HR.
A/C COOLING CAPACITY	2.5	TONS.
FAN SPEED	1170	CFM


# OF RUNS	S/A	R/A	FANS
3RD FLOOR			
2ND FLOOR	5	2	1
1ST FLOOR	13	3	4
BASEMENT	6	1	

FLOOR PLAN: PARTIAL PLAN(S)	
DRAWN BY: AM	CHECKED: DD
LAYOUT NO. JB-04585	SQFT 2818
DRAWING NO. M4	


DATE:	MARCH 23, 2018
CLIENT:	BAYVIEW WELLINGTON
MODEL:	S42-IB LOFT RIDEAU I LOFT
PROJECT:	GREEN VALLEY EAST BRADFORD,ONT.
SCALE:	3/16" = 1'-0"

 Site Copy

	FLEX DUCT		LOW/HIGH WALL/KICK SUPPLY DIFFUSER		DUCT CONNECTION TO JOIST LINING		RETURN AIR GRILLE (SIZE INDICATED ON DRAWING)	S.A.	SUPPLY AIR
	RIGID ROUND DUCT		HRV EXHAUST GRILLE		RETURN AIR PIPE RISER		RETURN AIR RISER UP TO FLOOR ABOVE	R.A.	RETURN AIR
	SUPPLY DIFFUSER		SUPPLY AIR PIPE RISER		RETURN ROUND DUCT		RETURN AIR FROM BASEMENT SECOND FLOOR		THERMOSTAT
			VOLUME DAMPER						PRINCIPAL EXHAUST FAN SWITCH
									W/R & PRINCIPAL EXHAUST FAN

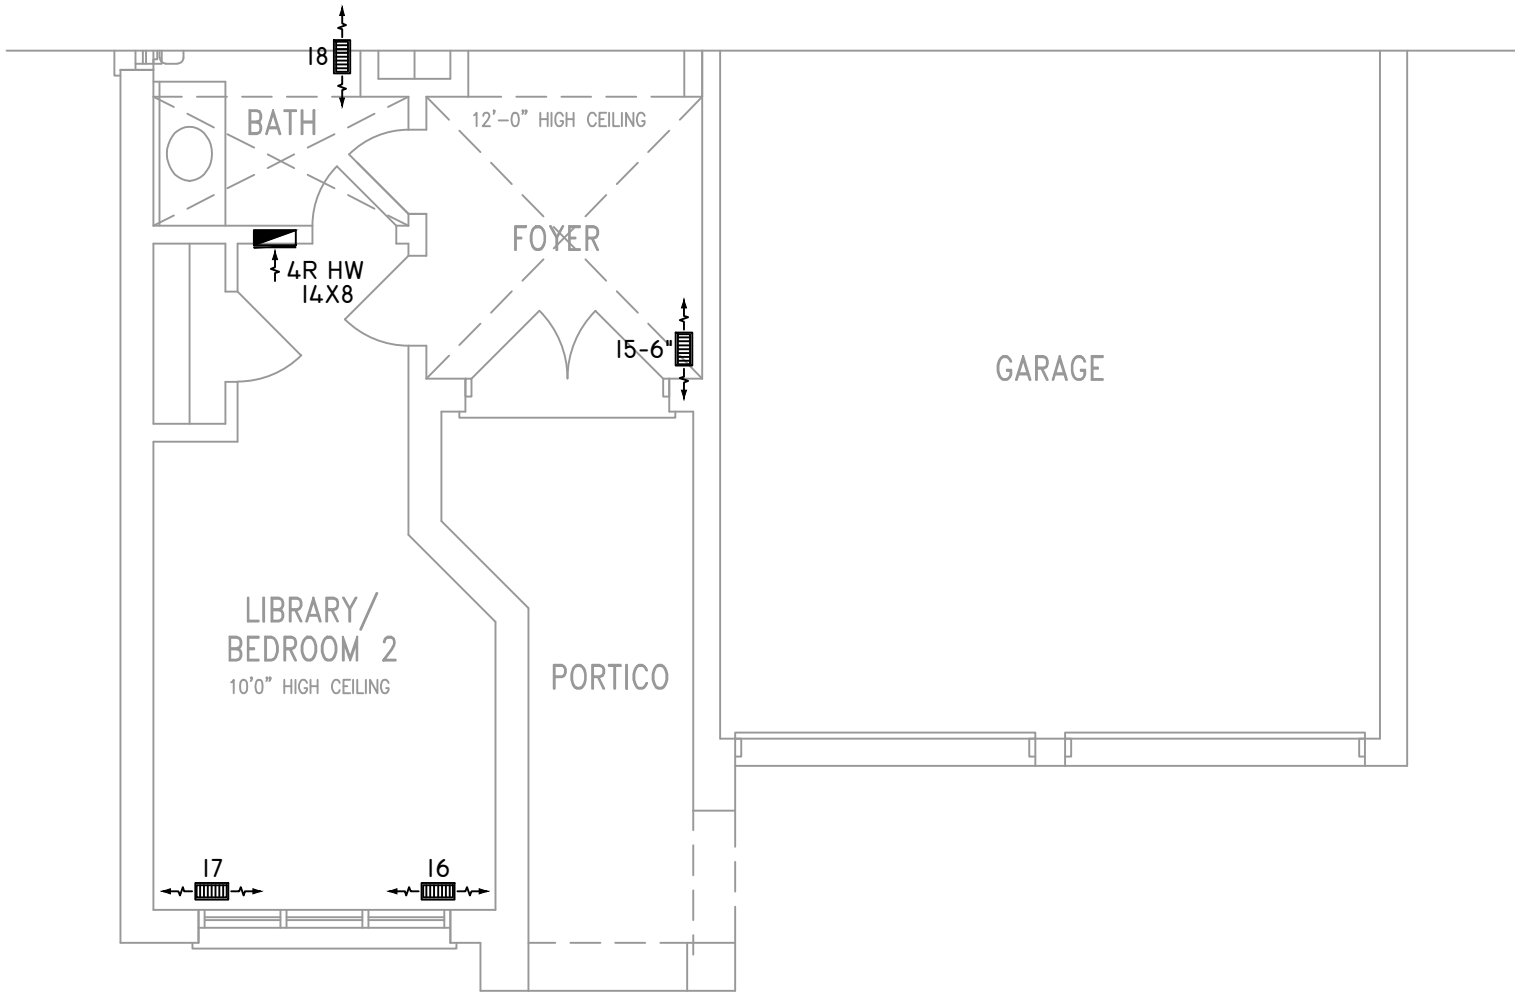

PART. GROUND FLOOR PLAN 'B'

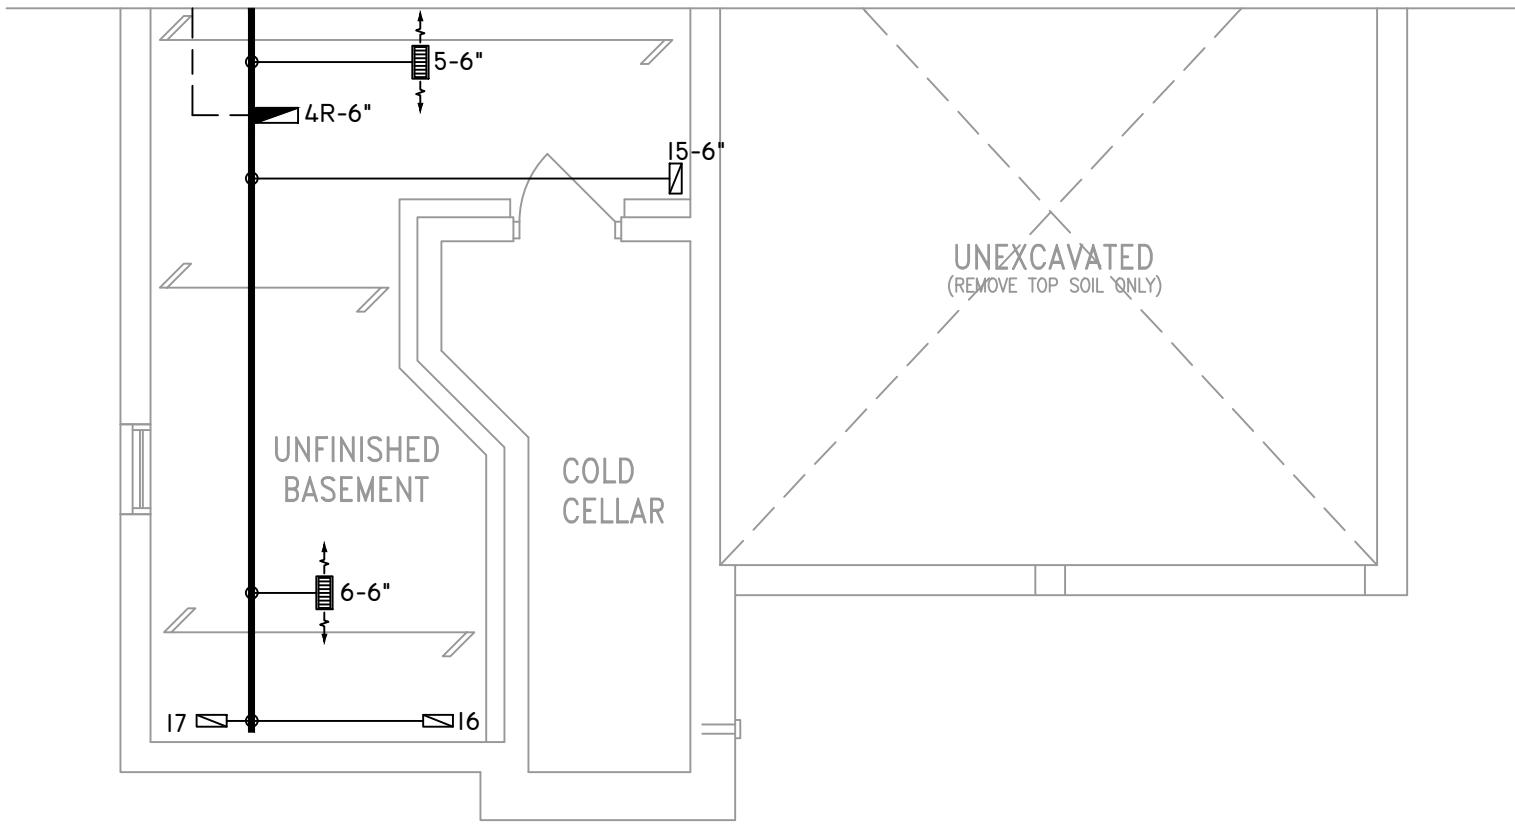

PART. BASEMENT PLAN 'B'

THE UNDERSIGNED HAS REVIEWED AND TAKES RESPONSIBILITY FOR THIS DESIGN ON BEHALF OF GTA DESIGNS INC. AND HAS THE QUALIFICATIONS AND MEETS THE REQUIREMENTS SET OUT IN THE BUILDING CODE TO BE A DESIGNER

QUALIFICATION INFORMATION

REQUIRED UNLESS DESIGN IS EXEMPT UNDER DIVISION C 3.2.5.1 OF THE ONTARIO BUILDING CODE

DAVID DA COSTA  B.C.I.N. 32964
SIGNATURE OF DESIGNER

OBC 2012

ZONE I COMPLIANCE
PACKAGE "A1" REF. TABLE 3.1.1.2.A

NOTES

INSTALLATION TO COMPLY WITH THE LATEST ONTARIO BUILDING CODE.

ALL SUPPLY OUTLETS TO BE 5" DIA. UNLESS OTHERWISE SPECIFIED.

PROVIDE BALANCING DAMPERS ON ALL BRANCHES.

ALL R/A PARTITIONS 6" (FIRST FLOOR ONLY)

INSULATE DUCTS IN UNCONDITIONED SPACES R12 UNDERCUT ALL DOORS 1" MIN.

CONTRACTOR MUST WORK FROM APPROVED PLANS.

ANY ALTERATIONS TO THIS ORIGINAL PLAN ARE NOT THE RESPONSIBILITY OF GTA DESIGNS.

GTA DESIGNS MUST BE CONSULTED IF KITCHEN EXHAUST FAN EXCEEDS 700 CFM DEPRESSURIZATION MAY OCCUR WITH IN THE DWELLING.


2985 DREW ROAD
SUITE 202,
MISSISSAUGA, ONT.
L4T 0A4 TEL: 905-671-9800
EMAIL: DAVE@GTADESIGNS.CA
WEB: WWW.GTADESIGNS.CA


HEAT-LOSS	53,848	BTU/HR.
UNIT MAKE	AMANA	OR EQUAL.
UNIT MODEL	AMEC960603BNA	OR EQUAL.
UNIT HEATING INPUT	60,000	BTU/HR.
UNIT HEATING OUTPUT	57,600	BTU/HR.
A/C COOLING CAPACITY	2.5	TONS.
FAN SPEED	1170	CFM


# OF RUNS	S/A	R/A	FANS
3RD FLOOR			
2ND FLOOR	5	2	1
1ST FLOOR	13	3	4
BASEMENT	6	1	

FLOOR PLAN: PARTIAL PLAN(S)		
DRAWN BY: AM	CHECKED: DD	SQFT 2818
LAYOUT NO. JB-04585	DRAWING NO. M5	


DATE: MARCH 23, 2018
CLIENT: BAYVIEW WELLINGTON
MODEL: S42-IB LOFT RIDEAU I LOFT
PROJECT: GREEN VALLEY EAST BRADFORD,ONT.
SCALE: 3/16" = 1'-0"

 Site Copy

	FLEX DUCT		LOW/HIGH WALL/KICK SUPPLY DIFFUSER		DUCT CONNECTION TO JOIST LINING		RETURN AIR GRILLE (SIZE INDICATED ON DRAWING)	S.A.	SUPPLY AIR
	RIGID ROUND DUCT		HRV EXHAUST GRILLE		RETURN AIR PIPE RISER		RETURN AIR RISER UP TO FLOOR ABOVE	R.A.	RETURN AIR
	SUPPLY DIFFUSER		SUPPLY AIR PIPE RISER		RETURN ROUND DUCT		RETURN AIR FROM BASEMENT SECOND FLOOR		THERMOSTAT
			VOLUME DAMPER						PRINCIPAL EXHAUST FAN SWITCH
									W/R & PRINCIPAL EXHAUST FAN

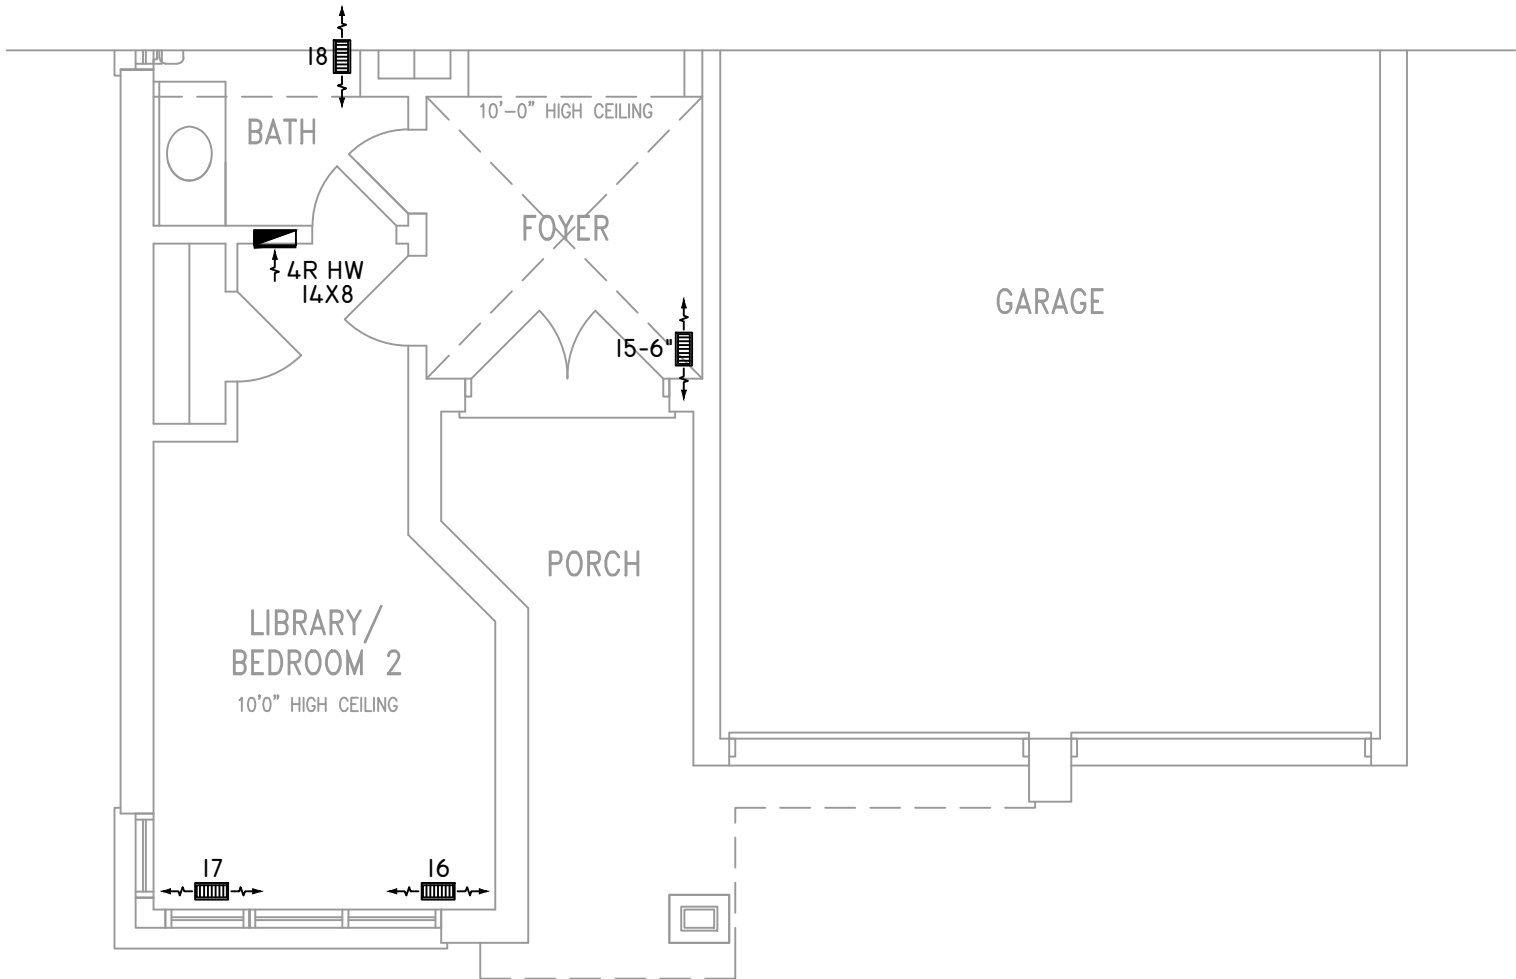

PART. GROUND FLOOR PLAN 'C'

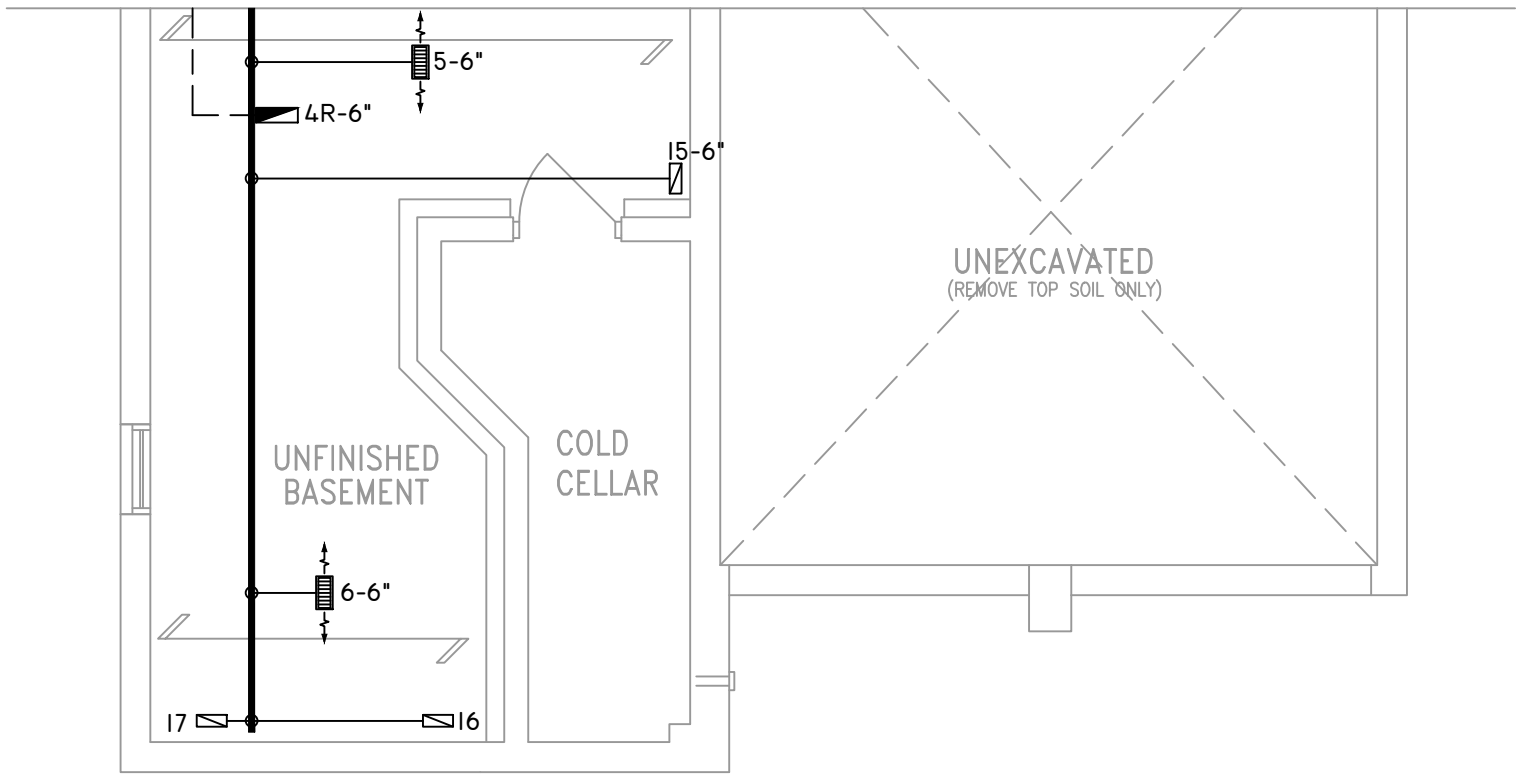

PART. BASEMENT PLAN 'C'

THE UNDERSIGNED HAS REVIEWED AND TAKES RESPONSIBILITY FOR THIS DESIGN ON BEHALF OF GTA DESIGNS INC. AND HAS THE QUALIFICATIONS AND MEETS THE REQUIREMENTS SET OUT IN THE BUILDING CODE TO BE A DESIGNER

QUALIFICATION INFORMATION

REQUIRED UNLESS DESIGN IS EXEMPT UNDER DIVISION C 3.2.5.1 OF THE ONTARIO BUILDING CODE

DAVID DA COSTA  B.C.I.N. 32964

SIGNATURE OF DESIGNER

OBC 2012

ZONE I COMPLIANCE
PACKAGE "A1" REF. TABLE 3.1.1.2.A

NOTES

INSTALLATION TO COMPLY WITH THE LATEST ONTARIO BUILDING CODE.

ALL SUPPLY OUTLETS TO BE 5" DIA. UNLESS OTHERWISE SPECIFIED.

PROVIDE BALANCING DAMPERS ON ALL BRANCHES.

ALL R/A PARTITIONS 6" (FIRST FLOOR ONLY)

INSULATE DUCTS IN UNCONDITIONED SPACES R12 UNDERCUT ALL DOORS 1" MIN.

CONTRACTOR MUST WORK FROM APPROVED PLANS.

ANY ALTERATIONS TO THIS ORIGINAL PLAN ARE NOT THE RESPONSIBILITY OF GTA DESIGNS.

GTA DESIGNS MUST BE CONSULTED IF KITCHEN EXHAUST FAN EXCEEDS 700 CFM DEPRESSURIZATION MAY OCCUR WITH IN THE DWELLING.



2985 DREW ROAD
SUITE 202,
MISSISSAUGA, ONT.
L4T 0A4 TEL: 905-671-9800
EMAIL: DAVE@GTADESIGNS.CA
WEB: WWW.GTADESIGNS.CA



HEAT-LOSS	53,848	BTU/HR.
UNIT MAKE	AMANA	OR EQUAL.
UNIT MODEL	AMEC960603BNA	OR EQUAL.
UNIT HEATING INPUT	60,000	BTU/HR.
UNIT HEATING OUTPUT	57,600	BTU/HR.
A/C COOLING CAPACITY	2.5	TONS.
FAN SPEED	1170	CFM


# OF RUNS	S/A	R/A	FANS
3RD FLOOR			
2ND FLOOR	5	2	1
1ST FLOOR	13	3	4
BASEMENT	6	1	

FLOOR PLAN:	
PARTIAL PLAN(S)	
DRAWN BY: AM	CHECKED: DD
LAYOUT NO. JB-04585	DRAWING NO. M6


DATE:	MARCH 23, 2018
CLIENT:	BAYVIEW WELLINGTON
MODEL:	S42-IB LOFT RIDEAU I LOFT
PROJECT:	GREEN VALLEY EAST BRADFORD,ONT.
SCALE:	3/16" = 1'-0"

  Site Copy


	FLEX DUCT		LOW/HIGH WALL/KICK SUPPLY DIFFUSER		DUCT CONNECTION TO JOIST LINING		RETURN AIR GRILLE (SIZE INDICATED ON DRAWING)	S.A.	SUPPLY AIR
	RIGID ROUND DUCT		HRV EXHAUST GRILLE		RETURN AIR PIPE RISER		RETURN AIR RISER UP TO FLOOR ABOVE	R.A.	RETURN AIR
	SUPPLY DIFFUSER		SUPPLY AIR PIPE RISER		RETURN ROUND DUCT		RETURN AIR FROM BASEMENT SECOND FLOOR		THERMOSTAT
			VOLUME DAMPER						PRINCIPAL EXHAUST FAN SWITCH
									W/R & PRINCIPAL EXHAUST FAN

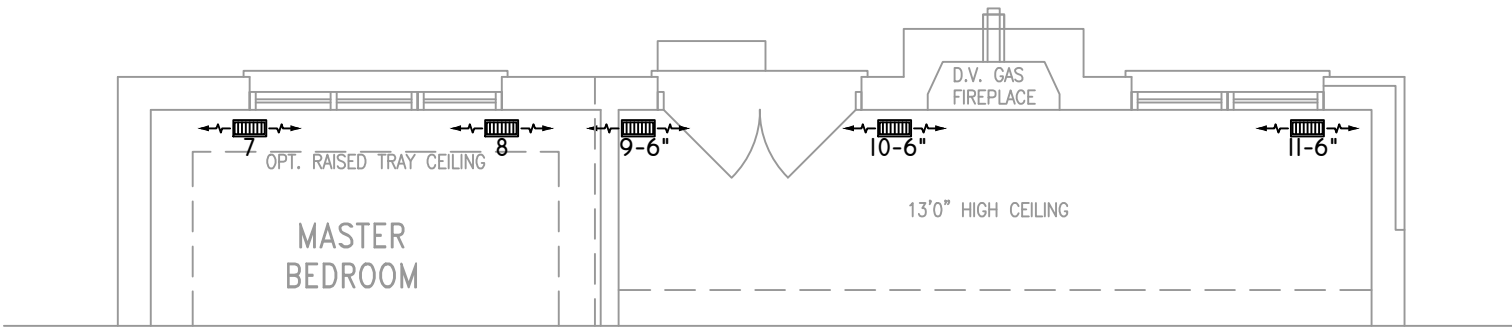

PARTIAL GROUND FLOOR PLAN ELEVATION 'C' REAR UPGRADE

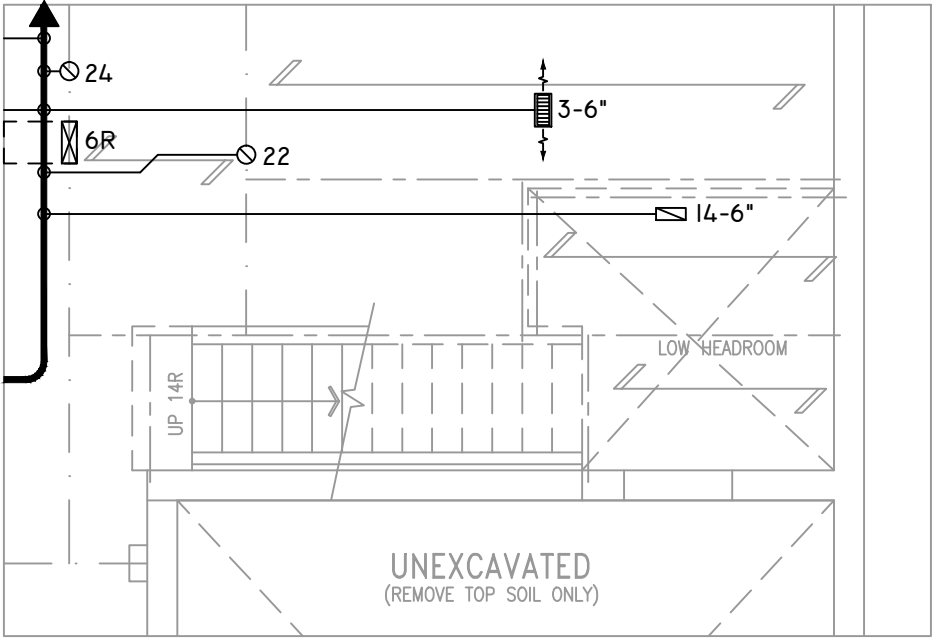

PARTIAL BASEMENT PLAN
W/ 1R SUNKEN MUD AREA ABOVE

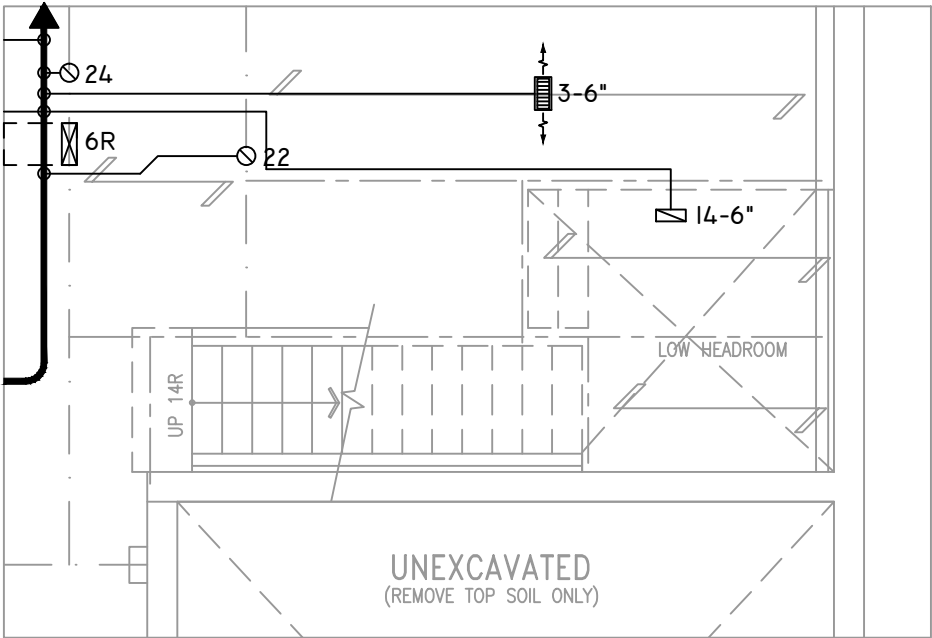

PARTIAL BASEMENT PLAN
W/ 2R OR MORE SUNKEN MUD
AREA ABOVE

THE UNDERSIGNED HAS REVIEWED AND TAKES RESPONSIBILITY FOR THIS DESIGN ON BEHALF OF GTA DESIGNS INC. AND HAS THE QUALIFICATIONS AND MEETS THE REQUIREMENTS SET OUT IN THE BUILDING CODE TO BE A DESIGNER

QUALIFICATION INFORMATION

REQUIRED UNLESS DESIGN IS EXEMPT UNDER DIVISION C 3.2.5.1 OF THE ONTARIO BUILDING CODE

DAVID DA COSTA



B.C.I.N. 32964

SIGNATURE OF DESIGNER

OBC 2012

ZONE I COMPLIANCE
PACKAGE "A1" REF. TABLE 3.1.1.2.A

NOTES
INSTALLATION TO COMPLY WITH THE LATEST ONTARIO BUILDING CODE.
ALL SUPPLY OUTLETS TO BE 5" DIA. UNLESS OTHERWISE SPECIFIED.
PROVIDE BALANCING DAMPERS ON ALL BRANCHES.
ALL R/A PARTITIONS 6" (FIRST FLOOR ONLY)
INSULATE DUCTS IN UNCONDITIONED SPACES R12 UNDERCUT ALL DOORS 1" MIN.
CONTRACTOR MUST WORK FROM APPROVED PLANS.
ANY ALTERATIONS TO THIS ORIGINAL PLAN ARE NOT THE RESPONSIBILITY OF GTA DESIGNS.
GTA DESIGNS MUST BE CONSULTED IF KITCHEN EXHAUST FAN EXCEEDS 700 CFM DEPRESSURIZATION MAY OCCUR WITH IN THE DWELLING.



2985 DREW ROAD
SUITE 202,
MISSISSAUGA, ONT.
L4T 0A4 TEL: 905-671-9800
EMAIL: DAVE@GTADESIGNS.CA
WEB: WWW.GTADESIGNS.CA

HEAT-LOSS	53,848	BTU/HR.
UNIT MAKE	AMANA	OR EQUAL.
UNIT MODEL	AMEC960603BNA	OR EQUAL.
UNIT HEATING INPUT	60,000	BTU/HR.
UNIT HEATING OUTPUT	57,600	BTU/HR.
A/C COOLING CAPACITY	2.5	TONS.
FAN SPEED	1170	CFM

# OF RUNS	S/A	R/A	FANS
3RD FLOOR			
2ND FLOOR	5	2	1
1ST FLOOR	13	3	4
BASEMENT	6	1	

FLOOR PLAN:		
PARTIAL PLAN(S)		
DRAWN BY:	CHECKED:	SQFT
AM	DD	2818
LAYOUT NO.	DRAWING NO.	
JB-04585	M7	

DATE:	MARCH 23, 2018
CLIENT:	BAYVIEW WELLINGTON
MODEL:	S42-IB LOFT RIDEAU I LOFT
PROJECT:	GREEN VALLEY EAST BRADFORD,ONT.
SCALE:	3/16" = 1'-0"

Site Copy