




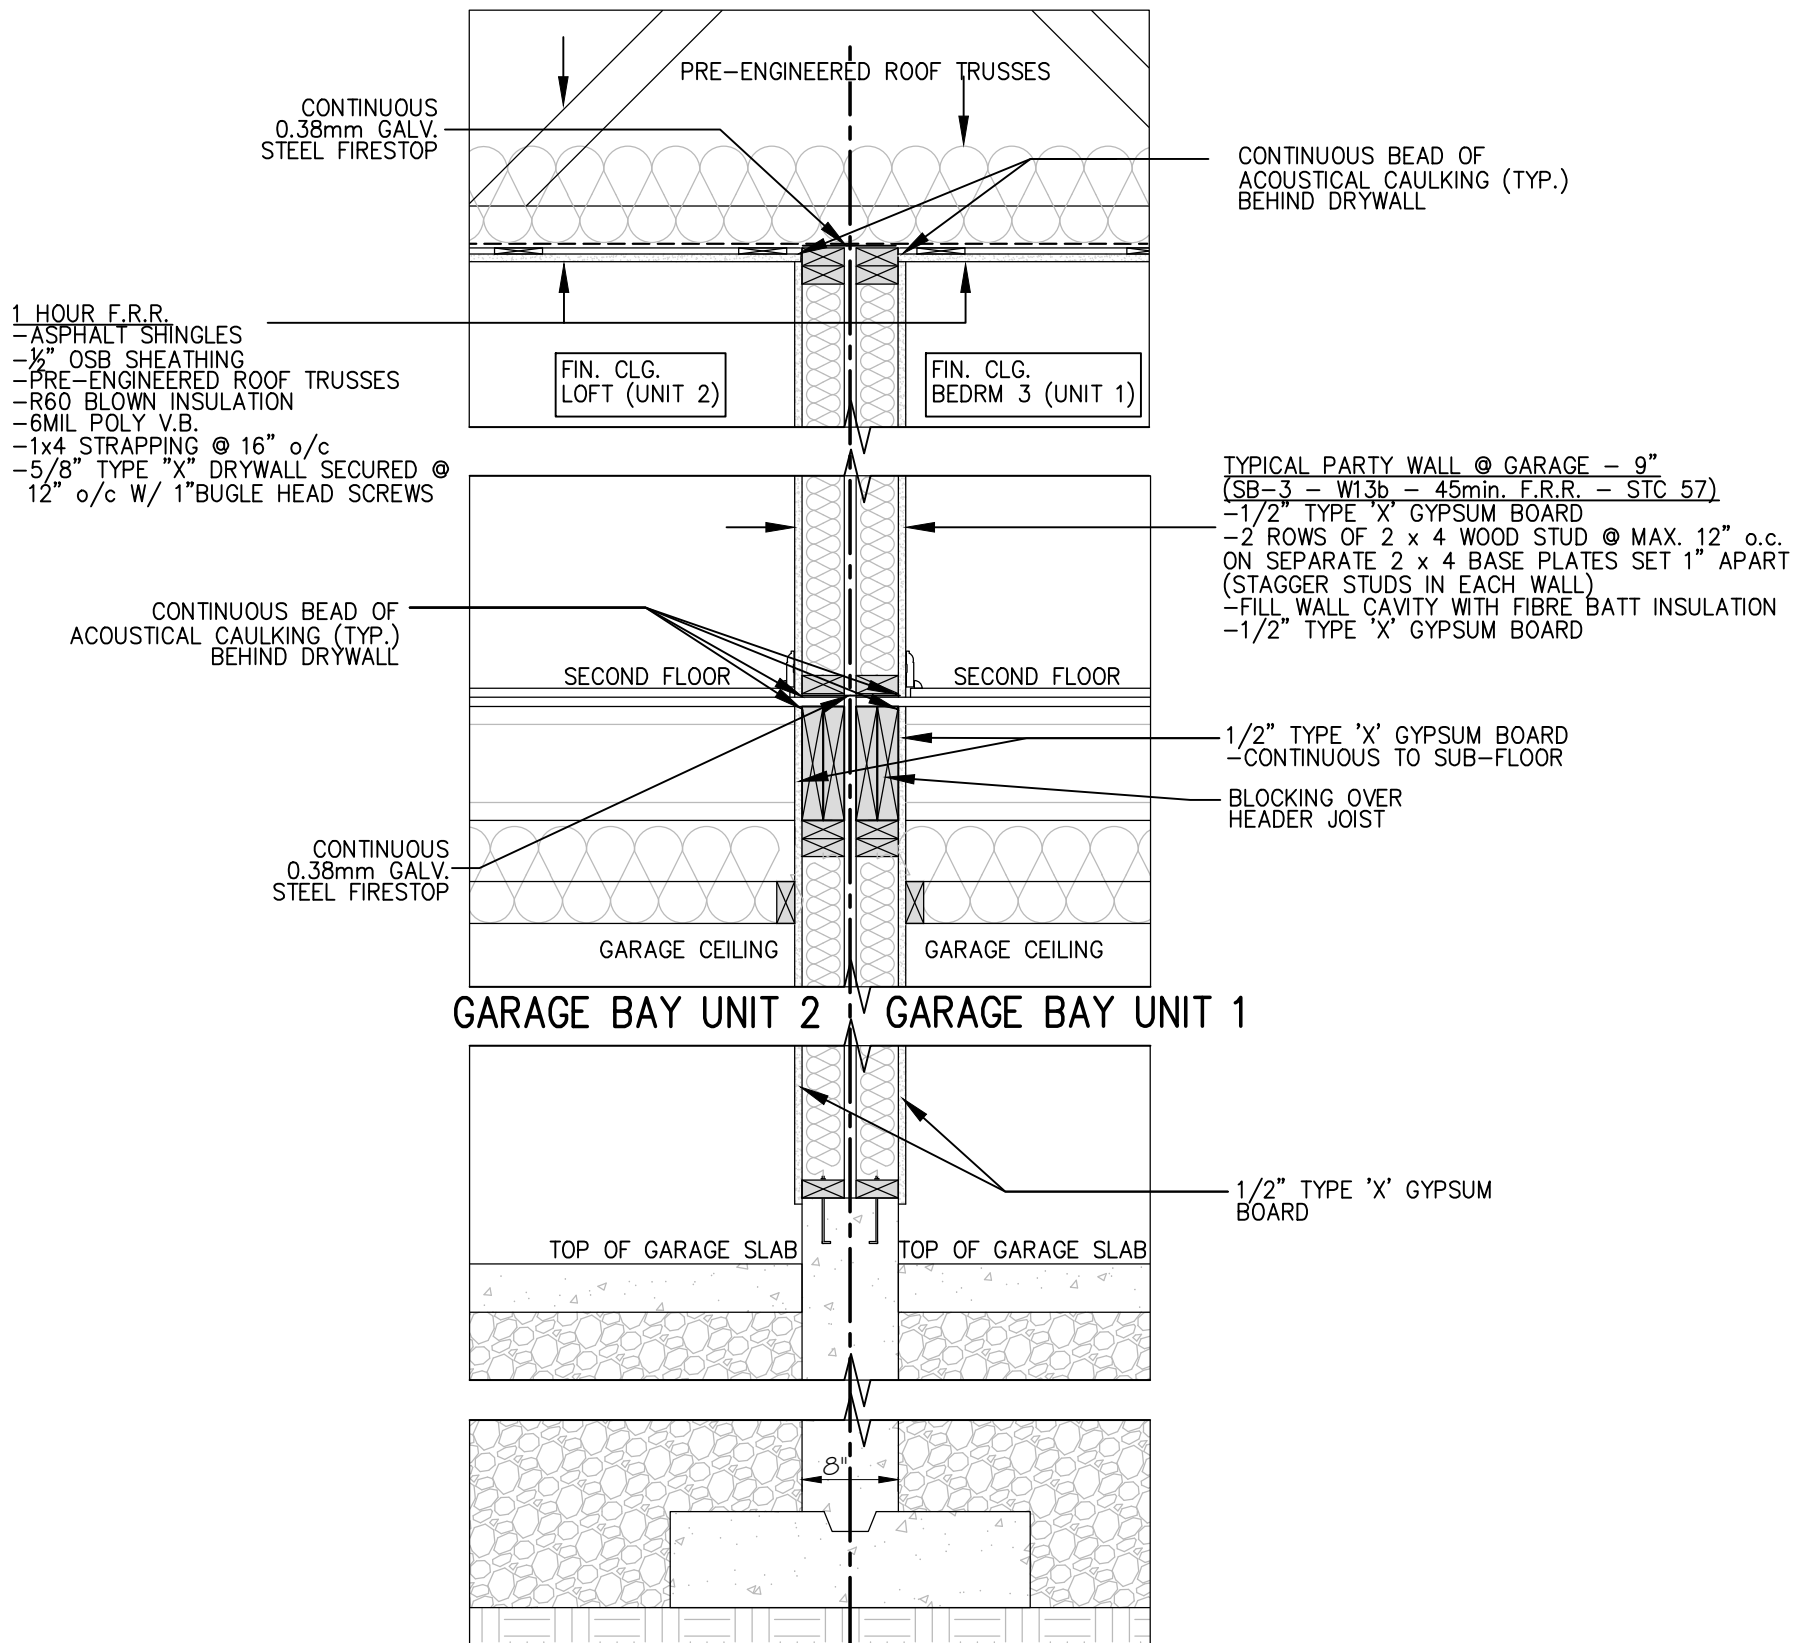


1 PARTY WALL DETAIL @ GARAGE  
FD-1 SCALE: 3/4"=1'

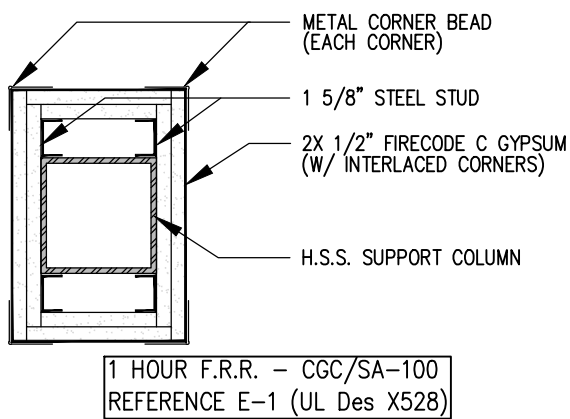

2 SECTION THRU SUPPORT POST  
FD-1 SCALE: N.T.S.

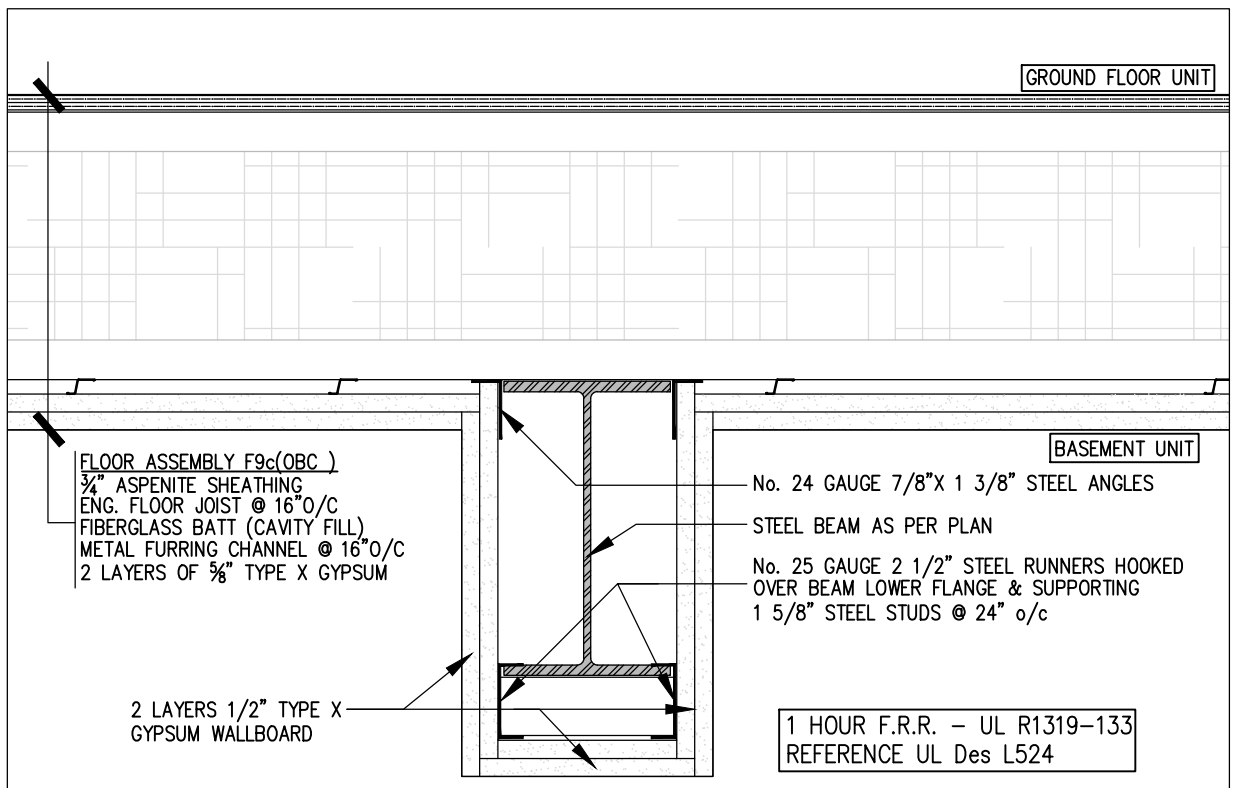

3 SECTION THRU FLOOR BETWEEN UNITS & SUPPORT BEAM  
FD-1 SCALE: N.T.S.

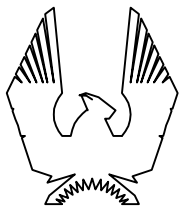

PHOENIX HOMES

KLONDIKE — M

FIRE PROTECTION DETAILS

|           |                         |          |    |
|-----------|-------------------------|----------|----|
| 3         |                         |          |    |
| 2         | REVISION TO DETAIL 1    | 24/05/18 | SP |
| 1         | FIRE PROTECTION DETAILS | 15/05/18 | SP |
| No.       | Description             | dd/mm/yy | By |
| REVISIONS |                         |          |    |

footprint:  
designed by: SP  
drawn by: SP  
date: MAY/18  
scale: AS SHOWN

sheet #:

FD-1