



E. & O. E. / FOR REFERENCE ONLY
SUBJECT TO CHANGES

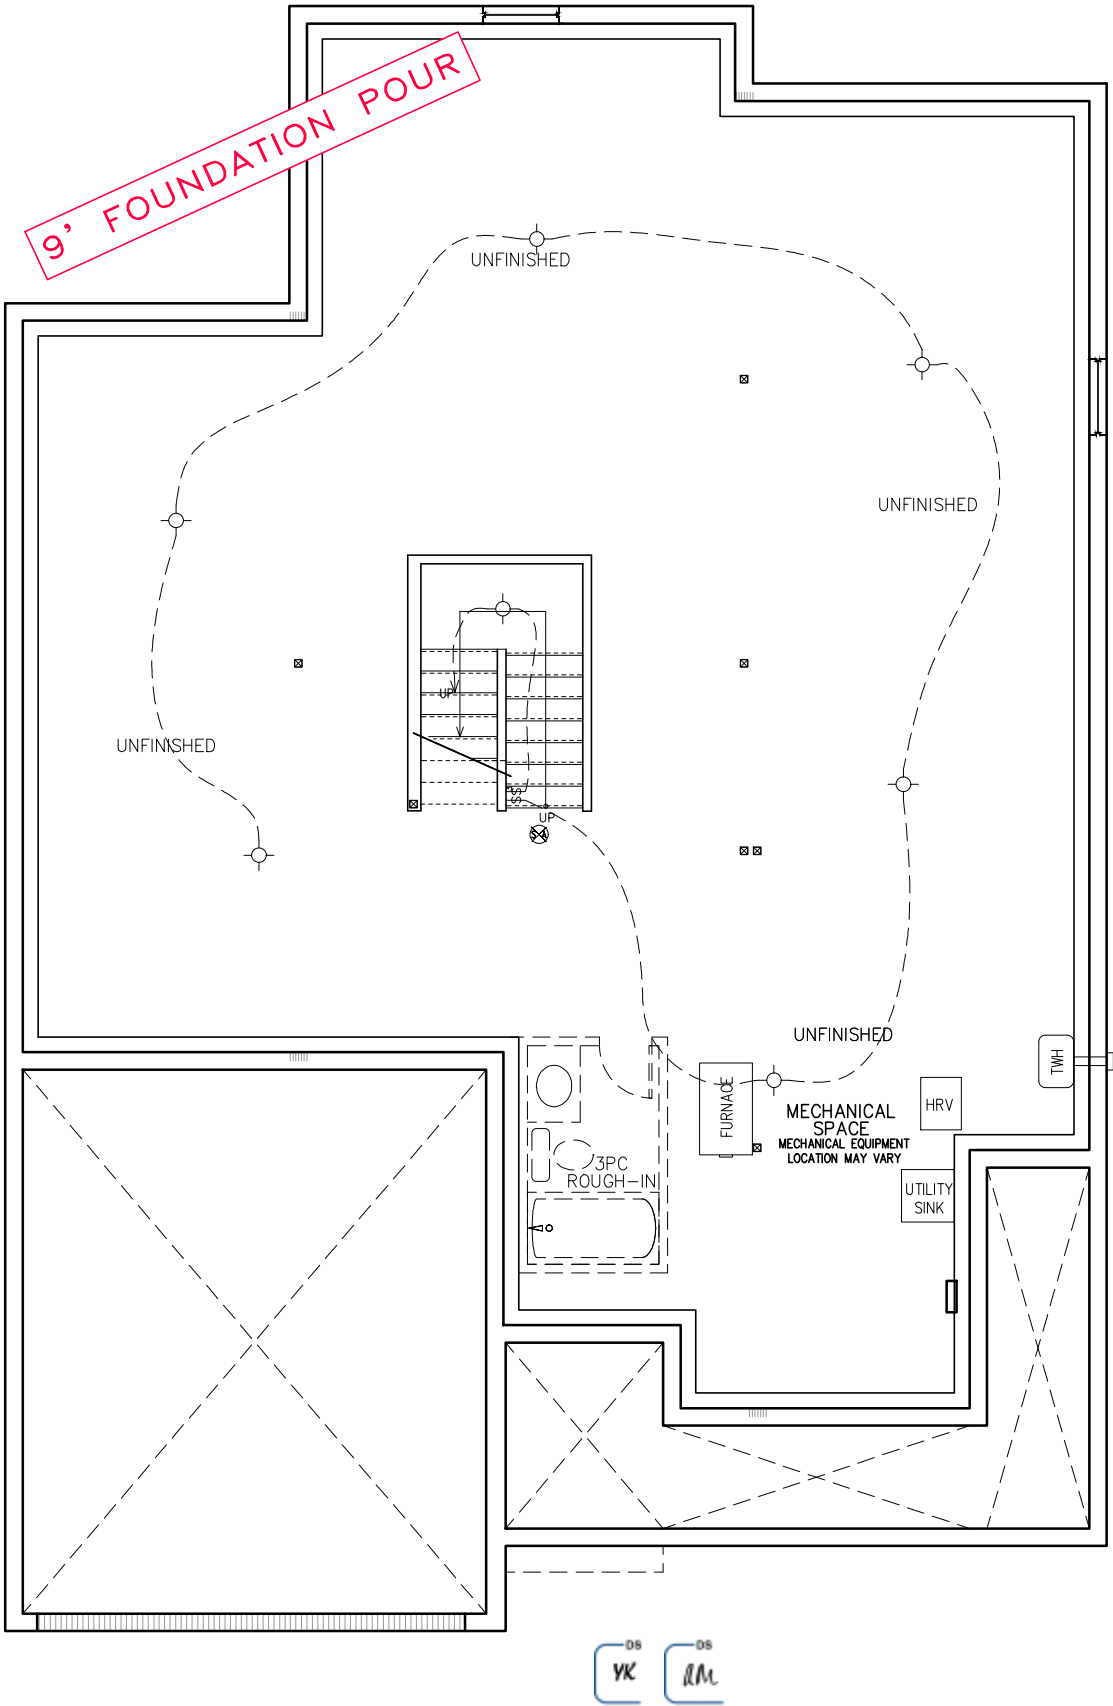

FOUNDATION PLAN (ALL ELEVATIONS)

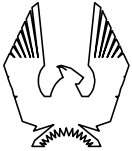

PHOENIX HOMES

NEWINGTON M – 2021

SITE: DIAMONDVIEW ESTATES

LOT NUMBER:

83

CIVIC ADDRESS:
96 CHANDELLE PRIVATE

12	FINAL BLACKLINES – REVISED	25/01/24	CB
11	FINAL BLACKLINES – REVISED	17/01/24	CB
10	FINAL BLACKLINES	10/01/24	CB
9	BEP BLACKLINES REVISED – 9' FND & 9' 2ND	03/11/23	CB
8	ISSUED FOR MECHANICAL LAYOUT	13/10/23	CB
7	BEP BLACKLINES	28/09/23	CB
No.	Description	dd/mm/yy	By
REVISIONS			

footprint: 518

drawn by: SP

date: JUN 12/16

scale: 3/16"=1'-0"


D.C.L. – A10

sheet no:

2M of


14

E. & O.E. / FOR REFERENCE ONLY
SUBJECT TO CHANGES

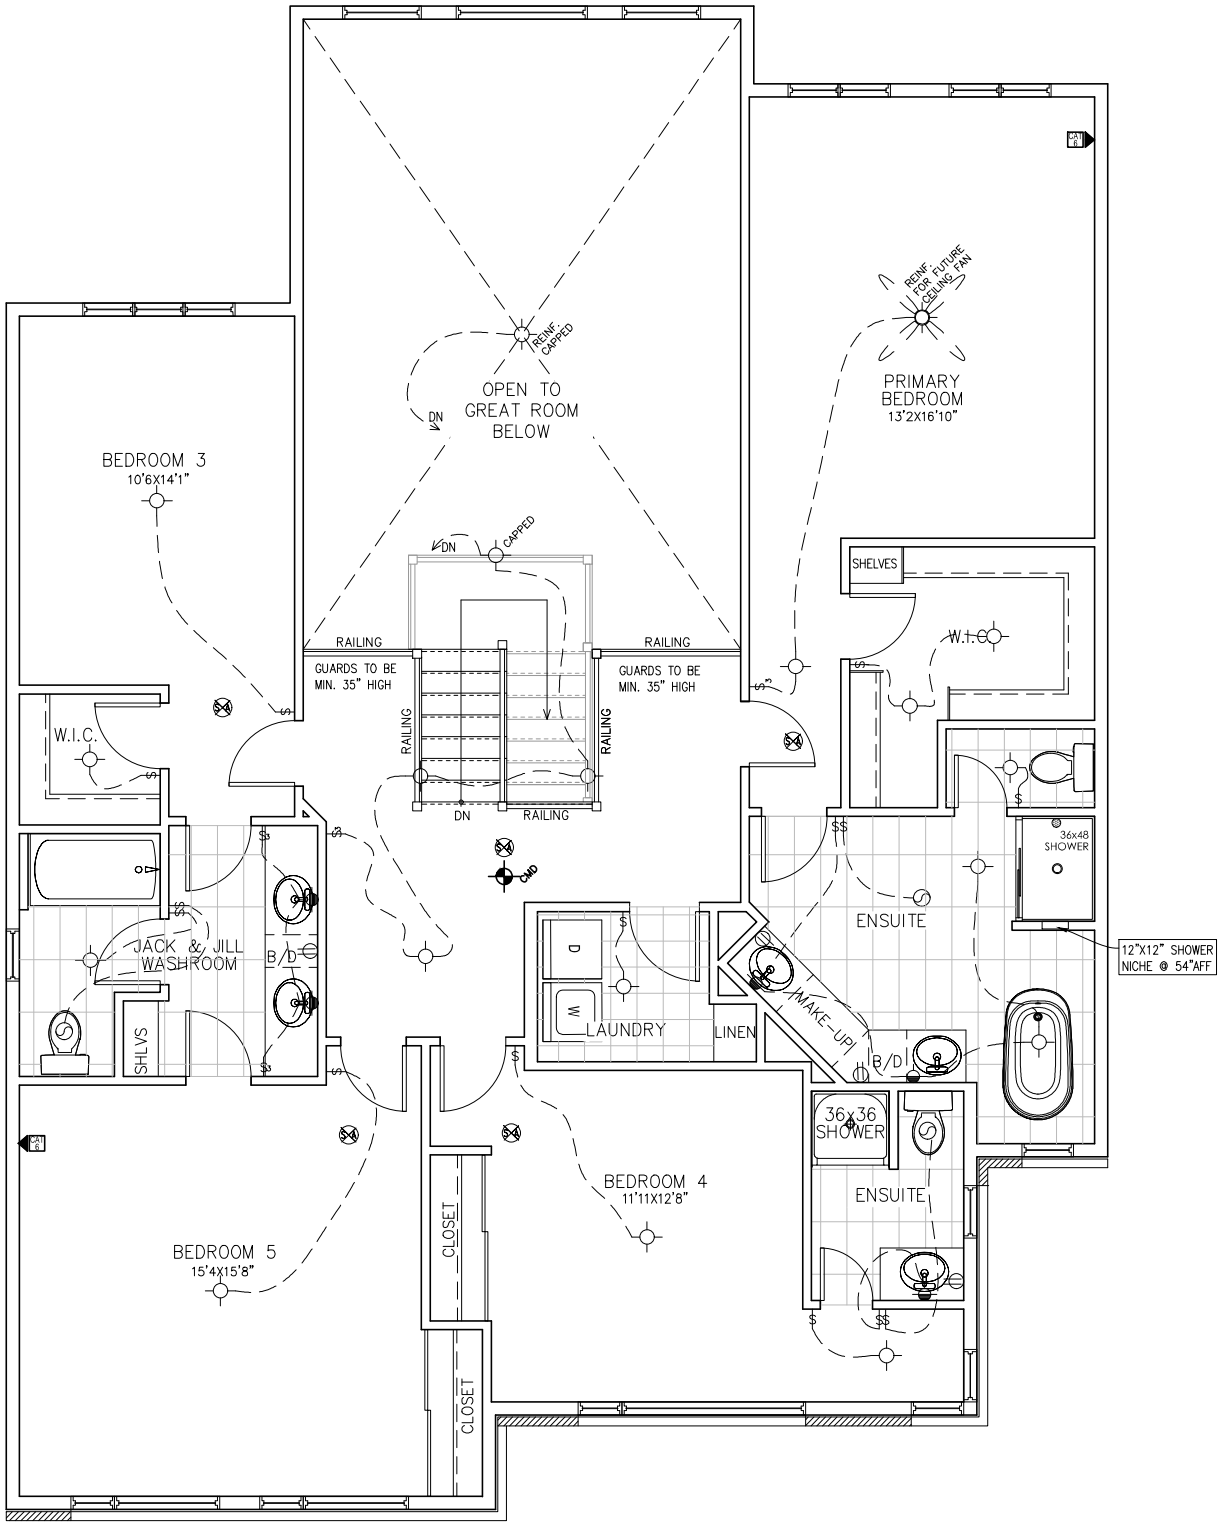

SECOND FLOOR PLAN (ELEVATION M)

 9' SECOND FLOOR



NEWINGTON M – 2021

SITE: DIAMONVIEW ESTATES

LOT NUMBER: 83

CIVIC ADDRESS:
96 CHANDELLE PRIVATE

12	FINAL BLACKLINES – REVISED	25/01/24	CB
11	FINAL BLACKLINES – REVISED	17/01/24	CB
10	FINAL BLACKLINES	10/01/24	CB
9	BEP BLACKLINES REVISED – 9' FND & 9' 2ND	03/11/23	CB
8	ISSUED FOR MECHANICAL LAYOUT	13/10/23	CB
7	BEP BLACKLINES	28/09/23	CB
No. Description		dd/mm/yy	By
REVISIONS			


footprint:	518
drawn by:	SP
date:	JUN 12/16
scale:	3/16"=1'-0"
D.C.L. – A10	4M of 14
sheet no:	

E. & O. E. / FOR REFERENCE ONLY
SUBJECT TO CHANGES




16'x7' O/H GARAGE DOOR

9' SECOND FLOOR

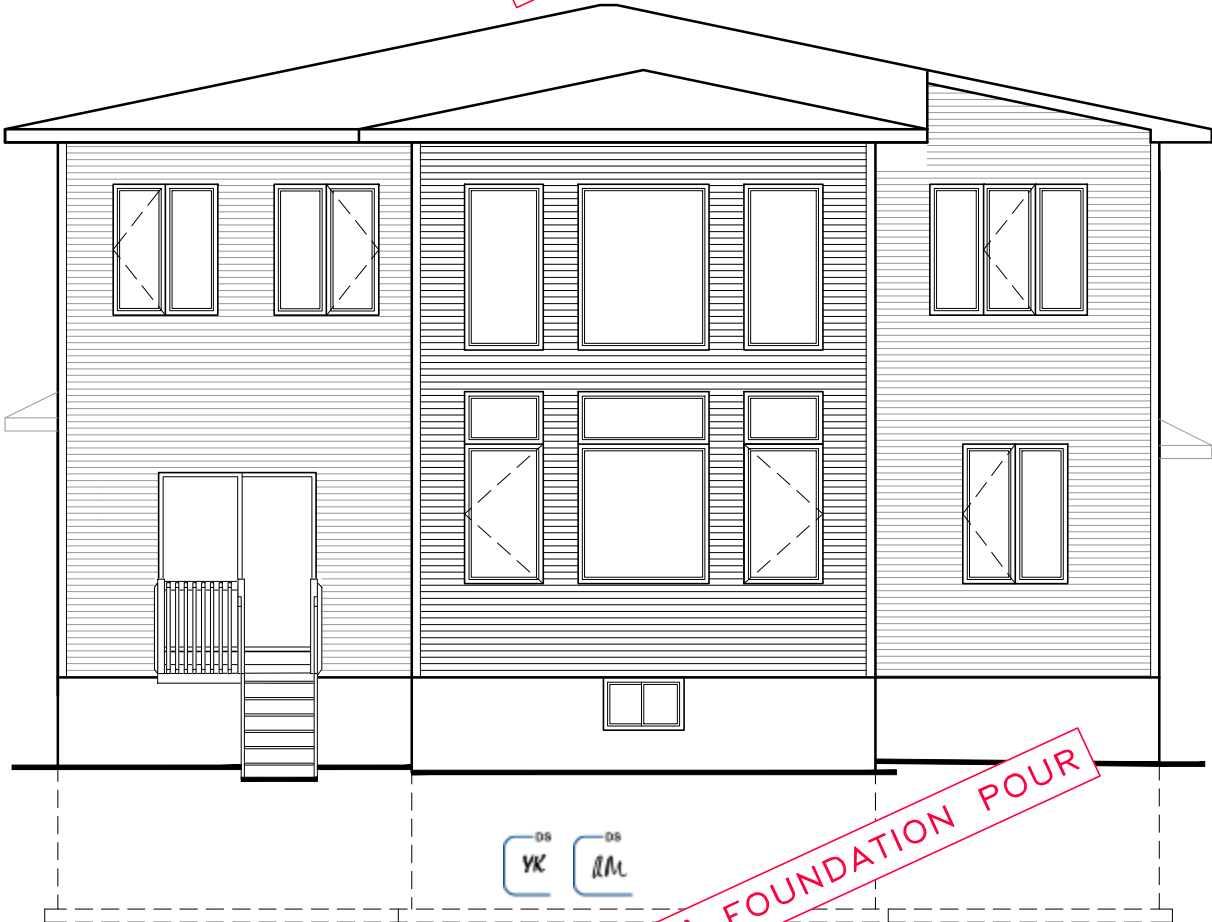

9' FOUNDATION POUR

ELEVATION M

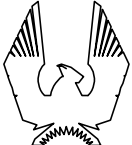

PHOENIX HOMES

NEWINGTON M – 2021

SITE: DIAMONDVIEW ESTATES

LOT NUMBER: 83

CIVIC ADDRESS: 96 CHANDELLE PRIVATE

12	FINAL BLACKLINES – REVISED	25/01/24	CB
11	FINAL BLACKLINES – REVISED	17/01/24	CB
10	FINAL BLACKLINES	10/01/24	CB
9	BEP BLACKLINES REVISED – 9' FND & 9' 2ND	03/11/23	CB
8	ISSUED FOR MECHANICAL LAYOUT	13/10/23	CB
7	BEP BLACKLINES	28/09/23	CB
No.	Description	dd/mm/yy	By
REVISIONS			

footprint: 518

drawn by: SP

date: JUN 12/16

scale: 3/16"=1'-0"

D.C.L. – A10

sheet no: 5M of 14

PHOENIX HOMES

NEWINGTON M – 2021

SITE: DIAMONDVIEW ESTATES

LOT NUMBER: 83

CIVIC ADDRESS: 96 CHANDELLE PRIVATE

No.	Description	dd/mm/yy	By
12	FINAL BLACKLINES – REVISED	25/01/24	CB
11	FINAL BLACKLINES – REVISED	17/01/24	CB
10	FINAL BLACKLINES	10/01/24	CB
9	BEP BLACKLINES REVISED – 9' FND & 9' 2ND	03/11/23	CB
8	ISSUED FOR MECHANICAL LAYOUT	13/10/23	CB
7	BEP BLACKLINES	28/09/23	CB

footprint: 518

drawn by: SP


date: JUN 12/16

scale: 3/16"=1'-0"

D.C.L. – A10

sheet no:

6M of 14

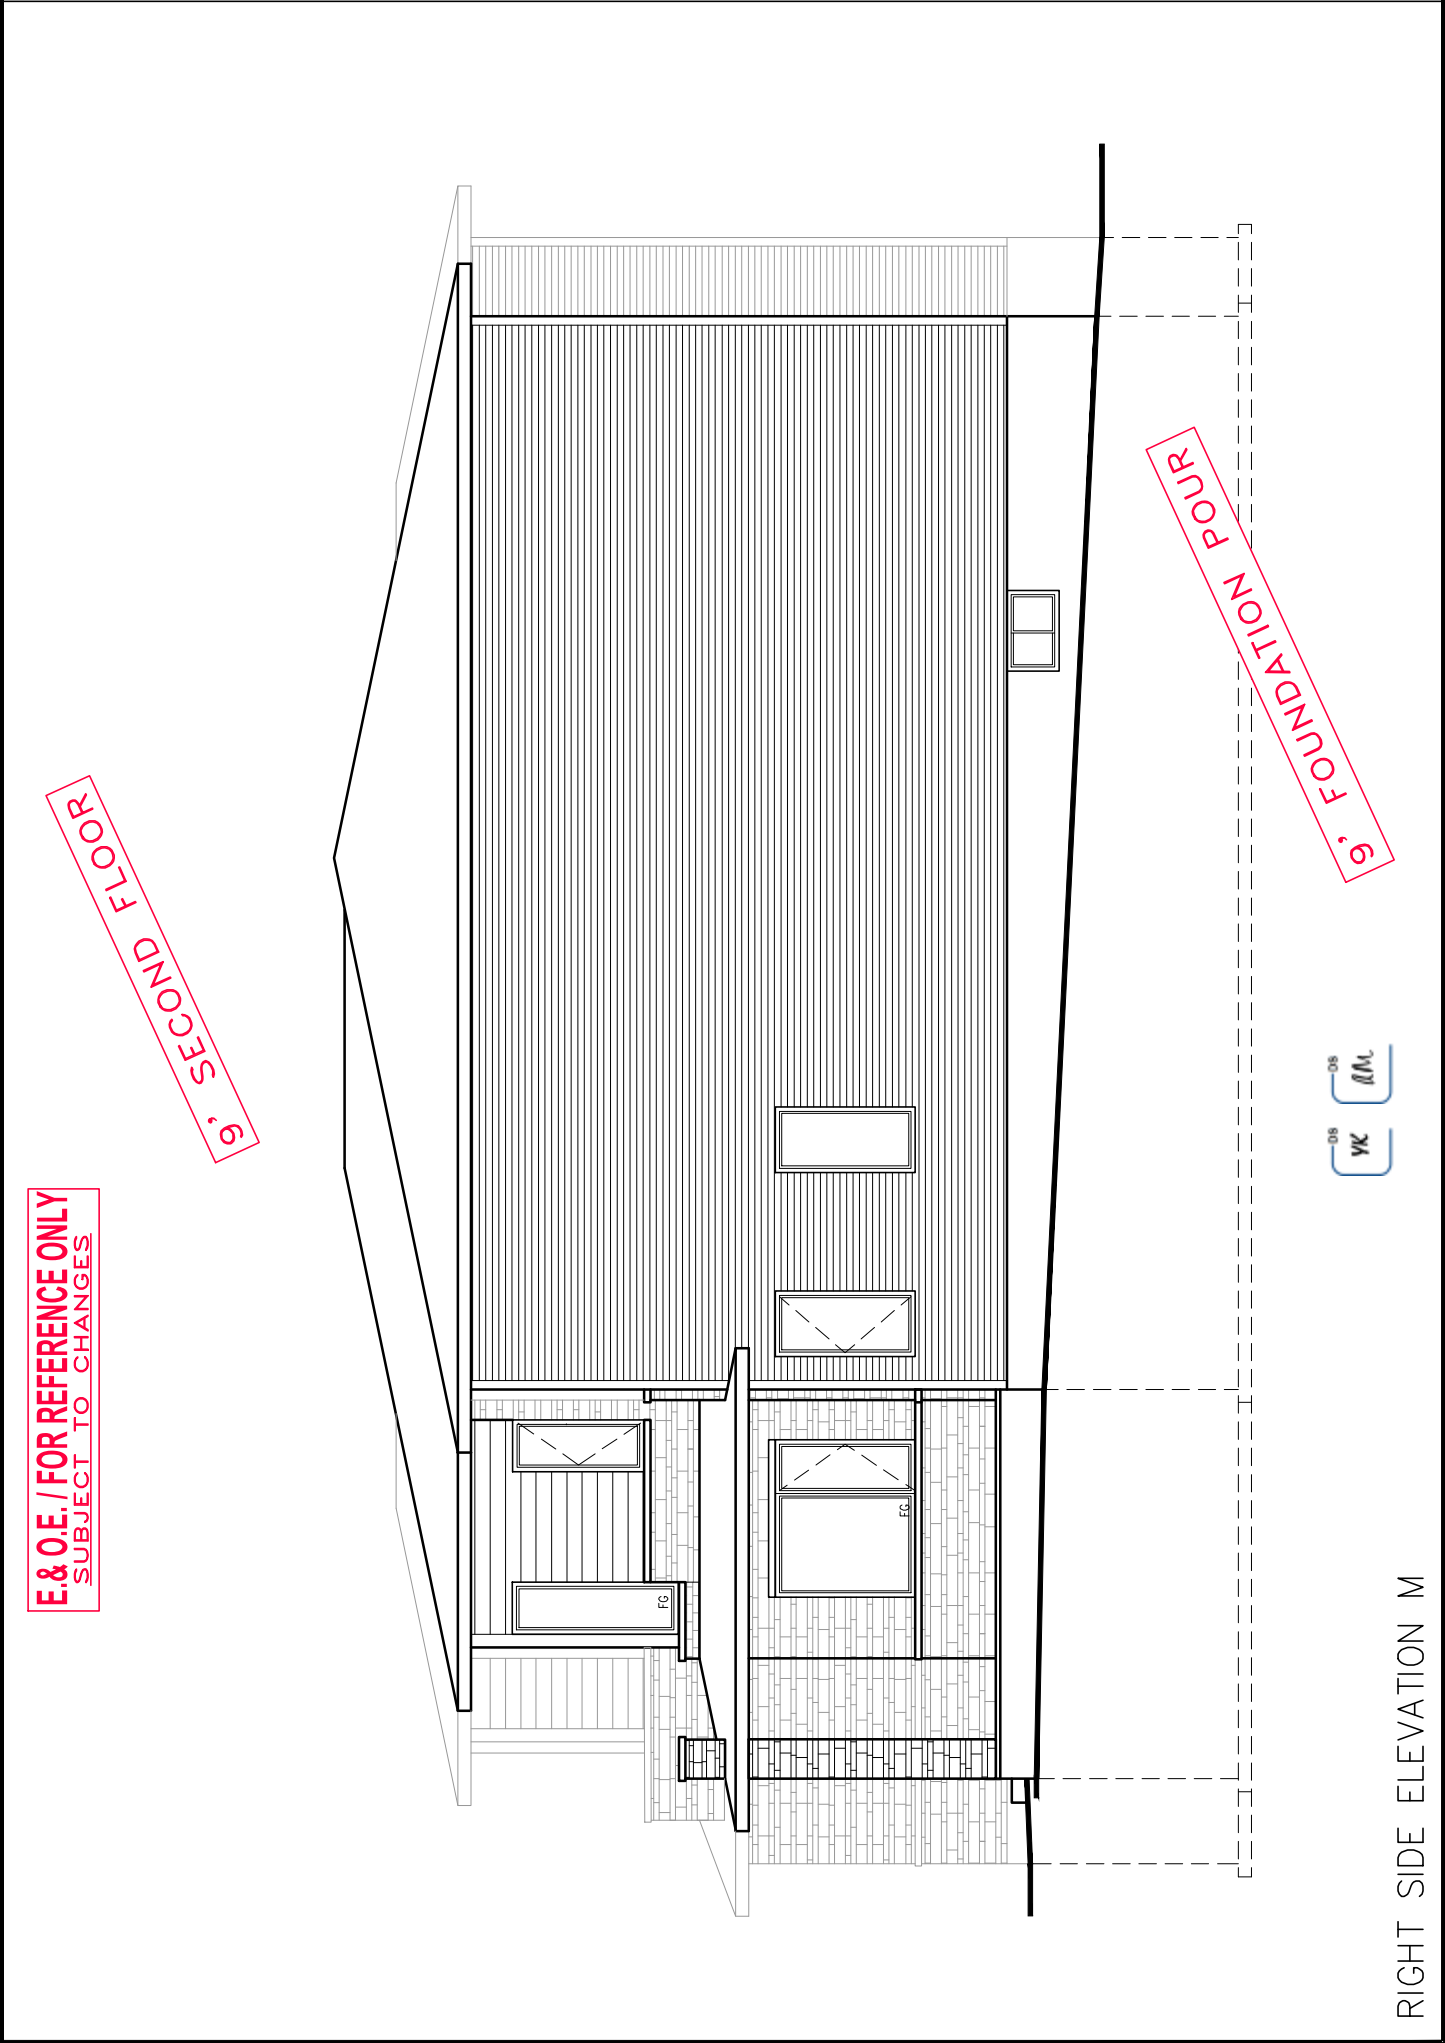

PHOENIX HOMES

NEWINGTON M – 2021

SITE: DIAMONDVIEW ESTATES

LOT NUMBER: 83

CIVIC ADDRESS: 96 CHANDELLE PRIVATE

No.	Description	dd/mm/yy	By
12	FINAL BLACKLINES – REVISED	25/01/24	CB
11	FINAL BLACKLINES – REVISED	17/01/24	CB
10	FINAL BLACKLINES	10/01/24	CB
9	BEP BLACKLINES REVISED – 9' FND & 9' 2ND	03/11/23	CB
8	ISSUED FOR MECHANICAL LAYOUT	13/10/23	CB
7	BEP BLACKLINES	28/09/23	CB

footprint: 518

drawn by: SP

date: JUN 12/16

scale: 3/16"=1'-0"

D.C.L. – A10

sheet no:

7M of 14

