



UNITED ENGINEERING INC
Mechanical and Electrical Consulting Engineers

3645 Keele St. #105
Toronto, ON, M3J 1M6
Email: info@u-eng.ca
T: (416) 398-1999
F: (416) 398-1933

SITE SUPPLEMENTAL INSTRUCTION

PROJECT: Forestside Estates
Attmar & Palleschi Drive
Brampton, Ontario

PROJECT NO.: 18-017

CONTRACT: Electrical

DATE: Aug. 09, 2021

SITE SI NO. E-7

THIS SITE SUPPLEMENTAL INSTRUCTION IS NOT TO BE CONSTRUED AS A CHANGE IN THE CONTRACT PRICE, BUT IS ISSUED FOR CLARIFICATION ONLY. IF A CHANGE IN CONTRACT PRICE IS PERCEIVED, PROVIDE AN ITEMIZED BREAKDOWN OF ANY EXTRAS OR CREDITS WITHIN SEVEN (7) WORKING DAYS.

PURPOSE: Revised as per Mech S SI M-4 and clarification.


1.0 Reference Drawing E-3 (Ground Floor - Electrical) Issued

- 1.1 Add: Electric heaters for service room and drive way ceiling as shown.
- 1.2 Revise: Service room electrical layout as shown.

PREPARED BY: *Susan Pan*
Susan Pan
Electrical Department

ISSUED TO ROYAL PINE HOMES,
Cinzia Caruso, Cinzia@royalpinehomes.com;
Vince Staffieri, vince@royalpinehomes.com;
FOR DISTRIBUTION TO ALL AFFECTED PARTIES.

- ✓ INTERPHONE PANEL, C/W THE INTERBUILDING CCTV SYSTEM, CARD READER, SYSTEM FAN/DRIVER, CONFIRM EXACT LOCATION ON DATE, WEATHER PROOF
- ✓ JUNCTION BOX FOR TR-SORT CABLE GARBAGE SYSTEM
- ✓ TOP OF STAIR
- ✓ SMOKE DETECTOR AND SPEAKER C/W FIRE ALARM ZONE
- ✓ FIRE ALARM ANNUNCIATOR (ALL FIRE ALARM ANNUNCIATOR TO BE STAINLESS STEEL - TYPICAL)
- ✓ 0/1H DOOR CONTROL PANELS TO BE INTERCONNECTED TO FIRE ALARM SYSTEM TO OPEN UPON ACTIVATION OF FIRE ALARM
- ✓ 0/1H DOOR OPERATOR FEED FROM DPZ1
- ✓ 'DO NOT ENTER' SIGNAGE INTERCONNECTED TO FIRE ALARM FEED FROM 1H-10
- ✓ WIRELESS SMOKE RECEPTOR TO ACTIVATE 0/1H DOOR AND/OR GATEWAYS, WEATHER PROOF
- ✓ FOR CEILING LIGHTING LIGHT/FIRE ALARM REFLECT TO 2ND FLOOR
- ✓ 20W NON FREEZE HOSE END SPRING FROM BELOW COMPLETE WITH ELECTRICAL TRIPPING, TRIPPING AND INSULATION
- ✓ RED PUMP PANE, 10"
- ✓ 120W ELECTRIC, 1H-1
- ✓ TRIPLE FLOW FAN HEATER
- ✓ CIGARET AS SHOWN
- ✓ NOT USED
- ✓ BUILDING STATUS ANNUNCIATOR
- ✓ FIRE DET APPROVED FIRE SMOKE LIGHTS TO BE INTERCONNECTED TO FIRE ALARM SYSTEM TO IDENT ACTIVATED BUILDING
- ✓ START BONES FOR SPECIAL MEASURES
- ✓ CIGARETS: 01-34/ 02-34/ 03-30/ 04-30
- ✓ SMOKE DETECTOR C/W RELAY FOR ELEVATOR RELAY

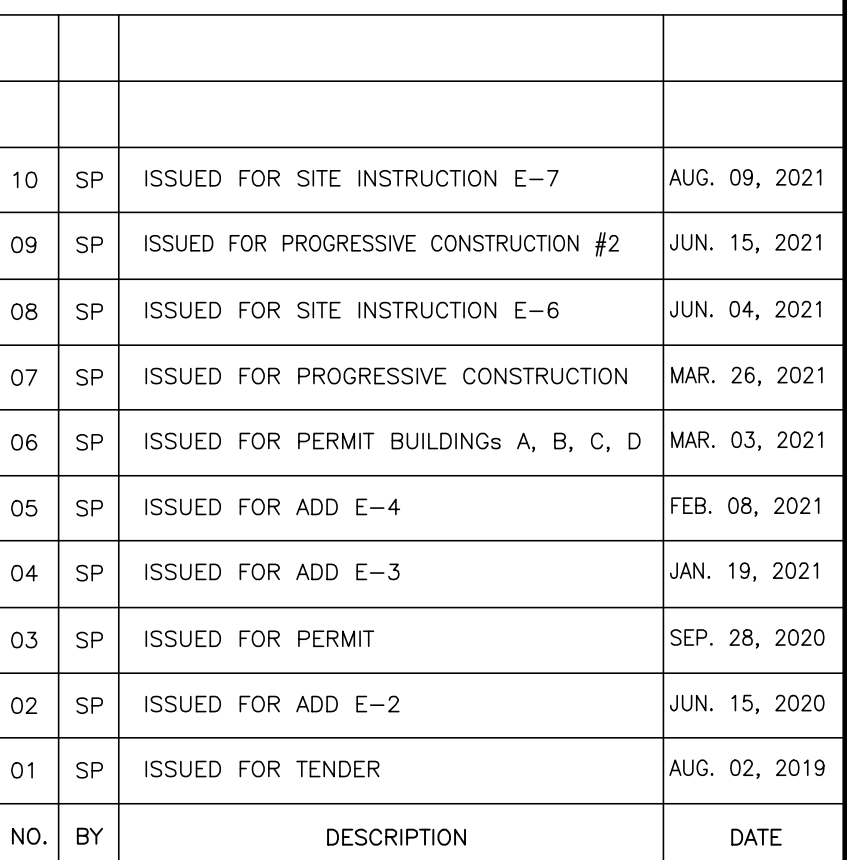

This drawing, is an instrument of service, is provided by and is the property of United Engineering Inc. The contractor must verify and accept responsibility for all dimensions and conditions on site and must notify United Engineering Inc. of any discrepancy before proceeding.

United Engineering Inc. is not responsible for the accuracy of Architectural, structural, interior design, etc. on this drawing.

Refer to the appropriate trade drawings before proceeding with any work. Installation must conform with all applicable codes and requirements of the authorities having jurisdiction.

This drawing is not to be scaled, all symbols are graphic representations only.



TITLE	GROUND FLOOR PLAN ELECTRICAL
-------	---------------------------------

DRAWN SP	CHECKED MG	SCALE 1:150
DATE MAY, 2019	PROJECT 18-017	DRAWING E-3 OF 16