



CONSTRUCTION SUMMARY

Grovetrail Developments Inc.

PURCHASER: JIE ZHOU

TEL:

LOT NUMBER	PHASE	HOUSE TYPE	CLOSING DATE
63 BLOCK 234	3	MACKENZIE END-OPT 2ND LEVEL-ELEV B	05-Aug-25

Date Added: 06-Mar-25 Invoice Number: 8737

1 - Install Builders Standard Cable Rough-Ins (x2) and Install Builders Standard Telephone Rough-Ins (x2) (See Sketch) Note:
1 - GREAT ROOM - In addition to builders standard ceiling light, Install SIX (6) POT LIGHTS Controlled by ONE (1) Seperate Switch at great room (See Sketch) Note: **TEN (10) Pot Lights with ONE (1) Switch Included in Standard Features and Finishes**
1 - DINETTE - In addition to builders standard ceiling light, Install FOUR (4) POT LIGHTS Controlled by ONE (1) Seperate Switch at Dinette Area (See Sketch) Note: **TEN (10) Pot Lights with ONE (1) Switch Included in Standard Features and Finishes** - Purchaser Paying for Additional Switch Only
1 - MASTER ENSUITE - In addition to builders standard electrical plugs, INSTALL ONE (1) ADDITIONAL INTERIOR GFCI PLUG on Dedicated line. To be installed beside toilet at master ensuite (See Sketch) Note:
1 - CLARIFICATION; EXTERIOR - GARAGE DOOR - Install STANDARD Exterior Handle with Lock on Garage Door Note:
1 - 2ND FLOOR - FLOORING - Install LAMINATE FLOORING - 7 1/2" TORLYS HIGHLAND WATSON NATURAL OAK EEH-292 in lieu of builders standard broadloom. To be installed throughout 2nd floor, where applicable. Note: To Include; Upper Hall, Master Bedroom, Bedroom #2, Bedroom #3 and Flex/Office Space (See Sketch)
1 - STAIRCASE VS FLOORING WOOD SPECIES DIFFERENCE: STAIRCASE - The purchaser was advised and therefore accepts and acknowledges that the wood species of the staircase and flooring chosen do not match. This difference may result in a stain colour variance. Note: The purchaser agrees that the vendor is to be exempt from any and all claims by the purchaser regarding this colour variance.
1 - STAIRCASE VS FLOORING STAINING DIFFERENCE: STAIRCASE - The purchaser was advised and therefore accepts and acknowledges that the stain of the staircase and flooring chosen do not match. This difference might result in an undesirable colour variance. Note: The purchaser agrees that the vendor is to be exempt from any and all claims by the purchaser regarding this colour variance.
1 - KITCHEN - CABINETRY - Install UPGRADE EXTENDED HEIGHT UPPER CABINETRY WITH LARGE CROWN MOULDING Includes FASCIA & PAN - To be installed throughout upper kitchen cabinetry, where applicable. Upper Cabinetry to Extend Up to Touch Ceiling.(See Sketch) Note: Priced as per Villa
1 - KITCHEN - COUNTERTOP - Install Builders Standard Stone Countertop – EVEREST VANILLA WHITE with STANDARD " A " EDGE PROFILE - To be installed throughout kitchen, where applicable (does not include stone backsplash) (See Sketch) Note:
1 - DISCLAIMER - STONE COUNTERTOP; KITCHEN - Due to the many variables that can affect the pattern, colour and/or design and “pitting” of stone products, stone installed will not be identical to the samples displayed. Note: Every effort is made to provide stone countertops as close as possible but the vendor is not responsible for results which differ from the sample displayed. All countertop surfaces may have seams, and product pattern and shade can change in areas containing seams.
1 - DISCLAIMER - STONE COUNTERTOP; KITCHEN - Stone slabs vary in size & all seams are visible & the fabricator reserves the right to position the seams as necessary. Note:
1 - KITCHEN - KITCHEN SINK - Install Builders Standard Undermount Sink – Kindred Reginox Undermount Sink – Model #ND1831UA-9 Note:
1 - KITCHEN - KITCHEN FAUCET - Install Builders Standard Faucet - DELTA Osler Single Handle Pull-Down (Single Hole) Kitchen Faucet - Model # 976LF – Chrome Note:



CONSTRUCTION SUMMARY

Grovetrail Developments Inc.

PURCHASER: JIE ZHOU

TEL:

LOT NUMBER	PHASE	HOUSE TYPE	CLOSING DATE
63 BLOCK 234	3	MACKENZIE END-OPT 2ND LEVEL-ELEV B	05-Aug-25

Date Added: 06-Mar-25 Invoice Number: 8737

1 - APPLIANCES - INSTALL STANDARD APPLIANCE PACKAGE (See Attached) Note:
1 - KITCHEN - KITCHEN BACKSPLASH - Install Standard 3x6 Silver Grey - To be installed throughout kitchen backsplash area, where applicable (does not include behind the fridge or stove) To be Installed STRAIGHT/STACKED (See Sketch) Note:
1 - POWDER ROOM - COUNTERTOP - Install Builders Standard Stone Countertop - EVEREST VANILLA WHITE with STANDARD " A " EDGE PROFILE - To be installed throughout powder room vanity, where applicable (Includes Applicable Splash) (See Sketch) Note:
1 - MAIN BATH - COUNTERTOP - Install Builders Standard Stone Countertop - EVEREST VANILLA WHITE with STANDARD " A " EDGE PROFILE - To be installed throughout main bath vanity, where applicable (Includes Applicable Splash) (See Sketch) Note:
1 - MASTER ENSUITE - COUNTERTOP - Install Builders Standard Stone Countertop - EVEREST VANILLA WHITE with STANDARD " A " EDGE PROFILE - To be installed throughout master ensuite vanity, where applicable (Includes Applicable Splash) (See Sketch) Note:
1 - DISCLAIMER - STONE COUNTERTOP; ALL BATHROOMS - Due to the many variables that can affect the pattern, colour and/or design and "pitting" of stone products, stone installed will not be identical to the samples displayed. Note: Every effort is made to provide stone countertops as close as possible but the vendor is not responsible for results which differ from the sample displayed. All countertop surfaces may have seams, and product pattern and shade can change in areas containing seams.
1 - MASTER ENSUITE - SHOWER FLOOR - Install UPGRADE #1 MOSAIC FLOOR TILES - 2x2 LA MARCA STATURARIETTO HONED in lieu of builders standard mosaic floor tiles. To be installed throughout master ensuite shower floor, where applicable (See Sketch) Note:
1 - MAIN BATH - Purchaser has DECLINED Upgrade to Install tiles on tub/shower ceiling. Purchaser accepts and acknowledges NO TILES will be installed on tub/shower ceiling. Note:
1 - MASTER ENSUITE - Purchaser has DECLINED Upgrade to Install tiles on shower ceiling. Purchaser accepts and acknowledges NO TILES will be installed on shower ceiling. Note:
1 - CLARIFICATION - PLUMBING ALL BATHROOMS - Install Builders Standard Plumbing Fixtures and Builders Standard Plumbing Faucets throughout all bathrooms, where applicable. To Include; Powder Room, Master Ensuite and Main Bath (See Sketch) Note:
1 - PURCHASER HAS ATTENDED A DECOR APPOINTMENT AT THE DESIGN STUDIO AND HAS DECLINED ANY ADDITIONAL UPGRADES. Purchaser accepts and acknowledges that there will be no further changes/additions/deletions to be made upon signing on FEBRUARY 28,2025 Note:
1 - PURCHASER AWARE AND ACCEPTS THAT ANY CHANGES MADE TO UPGRADES AFTER SIGNING THIS PURCHASERS EXTRA FORM ARE SUBJECT TO A MINIMUM ADMINISTRATION FEE OF \$1,000 Note:

Date Added: 30-Jan-25 Invoice Number: 8706

1 - BASEMENT - Install ADDITIONAL LAUNDRY ROUGH-INS ONLY (Inlcudes Electricalfor Washer and Dryer) To be installed beside existing standard laundry tub at basement (See Sketch) Note:



CONSTRUCTION SUMMARY

Grovetrail Developments Inc.

PURCHASER: JIE ZHOU

TEL:

LOT NUMBER	PHASE	HOUSE TYPE	CLOSING DATE
63 BLOCK 234	3	MACKENZIE END-OPT 2ND LEVEL-ELEV B	05-Aug-25

Date Added: 30-Jan-25 Invoice Number: 8706

I - SECOND FLOOR - CEILINGS - Install UPGRADE SMOOTH CEILINGS Throughout 2nd Floor, where applicable. To Include: Upper Hall, Master Bedroom, Bedroom #2, Bedroom #3 and Flex Space/Office. (See Sketch) Note:
I - BONUS PACKAGE - PURCHASER HAS APPLIED \$7,500.00 (Includes Taxes) WORTH OF UPGRADE PROMOTIONAL PACKAGE TOWARDS THE PURCHASE OF STRUCTURAL UPGRADES COMPLETED AT THE DECOR CENTRE Note:
I - PURCHASER HAS ATTENDED A STRUCTURAL APPOINTMENT AT THE DESIGN STUDIO & HAS DECLINED ANY ADDITIONAL UPGRADES. Purchaser accepts & acknowledges that there will be no further structural changes/additions/deletions to be made upon signing on JANUARY 29,2025 Note:
I - PURCHASER AWARE AND ACCEPTS THAT ANY CHANGES MADE TO UPGRADES AFTER SIGNING THIS PURCHASERS EXTRA FORM ARE SUBJECT TO A MINIMUM ADMINISTRATION FEE OF \$1,000 Note:

This Document is Extremely Time Sensitive - Printed 10 Mar 25 at 9:01

* INTERIOR COLOUR SCHEME *

	Purchaser JIE ZHOU	Decor Consultant Laura Di Pede	Model and Elevation MACKENZIE END-OPT 2ND LEVEL-ELEV B	Telephone Res. / Bus /	Project Grovetrail Developments Inc.	Closing Date 05/08/2025	Property 63 BLOCK 234
---	------------------------------	--	--	----------------------------------	--	-----------------------------------	---------------------------------

Page 1 of 3

	Flooring	Wall Tile	Plumbing			
	Description	Main	Accent/Insert	Border / Listello	Pattern	
Master Ensuite	✓ 13x13 MALENA CARBON (STD)	✓ 8x10 MALENA CARBON (STD)	NONE	NONE	NONE	WHITE
Main Bath	✓ 13x13 MALENA ICE (STD)	✓ 8x10 MALENA ICE (STD)	NONE	NONE	NONE	WHITE
Laundry (2nd Floor)	✓ 13x13 COSTA WHITE (STD)	N/A	N/A	N/A	NONE	STD
Powder Room	✓ 13x13 COSTA WHITE (STD)	N/A	N/A	N/A	NONE	WHITE
Mud Room	✓ 13x13 COSTA WHITE (STD)	N/A	N/A	N/A	NONE	N/A
Kitchen/Dinette	✓ 13x13 COSTA WHITE (STD)	✓ 3x6 SILVER GREY (STRAIGHT) (STD)	NONE	NONE	NONE	STD
Foyer	✓ 13x13 COSTA WHITE (STD)					
Main Hall	✓ 7 1/2" Torlys Watson Natural Oak EEH-292 (STD)					
Great Room	✓ 7 1/2" Torlys Watson Natural Oak EEH-292 (STD)					
Upper Hall	✓ 7 1/2" Torlys Watson Natural Oak EEH-292 (UPG)					
Flex Space/Office	✓ 7 1/2" Torlys Watson Natural Oak EEH-292 (UPG)					
Master Bedroom	✓ 7 1/2" Torlys Watson Natural Oak EEH-292 (UPG)					
Bedroom 2	✓ 7 1/2" Torlys Watson Natural Oak EEH-292 (UPG)					
Bedroom 3	✓ 7 1/2" Torlys Watson Natural Oak EEH-292 (UPG)					

Railings and Stairs

Railings	✓ STD - OVAL Mirage Red Oak Driftwood	Landing - Upper	✓ 7 1/2" Torlys Watson Natural Oak (STD)
Pickets	✓ STD-Steel 1/2" Square, Plain Flat Black	Landing - Lower	✓ 7 1/2" Torlys Watson Natural Oak (STD)
Posts	✓ STD-3 1/2" Square with Cap, Mirage Red Oak Drift	Ledge - Upper	N/A
		Ledge - Lower	N/A
Stringers	✓ STD - MIRAGE RED OAK DRIFTWOOD		
Treads	✓ STD - MIRAGE RED OAK DRIFTWOOD		
Risers	✓ STD - MIRAGE RED OAK DRIFTWOOD		
Runner	NONE		

Trim

Baseboard & Casing	✓ STANDARD - Colonial	Knobs	✓ STANDARD
Front Door Glass	✓ STANDARD	Hinges	✓ STANDARD
Interior Doors	✓ STANDARD	Grip Set	✓ STANDARD

Notes

MASTER ENSUITE - Install UPGRADE - 2x2 LA MARCA STATURARIETTO HONED Mosaic Floor Tiles with 6" Curb with White Quartz to Shower Stall

Cornice Moulding / Medallion

Foyer	NONE
Living Room	NONE
Dining Room	NONE
Family Room	NONE
Main Hall	NONE
Kitchen	NONE
2nd Floor Hall	NONE

* INTERIOR COLOUR SCHEME *

Purchaser	Decor Consultant	Model and Elevation	Telephone Res. / Bus	Project	Closing Date	Property
JIE ZHOU	Laura Di Pedo	MACKENZIE END-OPT 2ND LEVEL-ELEV B	/	Grovetrail Developments Inc.	05/08/2025	63 BLOCK 234

Page 2 of 3

	Interior Paint
	Description
Master Ensuite	STANDARD - SILVER BIRCH
Main Bath	STANDARD - SILVER BIRCH
Laundry (2nd Floor)	STANDARD - SILVER BIRCH
Powder Room	STANDARD - SILVER BIRCH
Mud Room	STANDARD - SILVER BIRCH
Kitchen/Dinette	STANDARD - SILVER BIRCH
Foyer	STANDARD - SILVER BIRCH
Main Hall	STANDARD - SILVER BIRCH
Great Room	STANDARD - SILVER BIRCH
Upper Hall	STANDARD - SILVER BIRCH
Flex Space/Office	STANDARD - SILVER BIRCH
Master Bedroom	STANDARD - SILVER BIRCH
Bedroom 2	STANDARD - SILVER BIRCH
Bedroom 3	STANDARD - SILVER BIRCH

Cabinet

Style	Countertop	Counter Edge	Handle / Knob
EURO MELAMINE - WILLOW VELVET SF255 (VELVELT FINISH) (STD)	EVEREST VANILLA WHITE (STD)	A * EDGE (STD)	9550-BNI
EURO MELAMINE - FOG GREY SF213 (VELVELT FINISH) (STD)	EVEREST VANILLA WHITE (STD)	A * EDGE (STD)	9550-BNI
N/A	N/A	N/A	N/A
EURO MELAMINE - FOG GREY SF213 (VELVELT FINISH) (STD)	EVEREST VANILLA WHITE (STD)	A * EDGE (STD)	9550-BNI
N/A	N/A	N/A	N/A
EURO MELAMINE - FOG GREY SF213 (VELVELT FINISH) (STD)	EVEREST VANILLA WHITE (STD)	A * EDGE (STD)	9550-BNI

Appliance Opening/Dimension

Fridge Size	See Attached Villa Layout	Range	See Attached Villa Layout
Built-Ins	None	Microwave	None
Hood Fan	See Attached Villa Layout	Exhaust Opening	6" 8"
Dishwasher Cabinet	See Attached Villa Layout		

Fireplace

Fireplace	N/A	Fireplace	N/A
Location Flooring	N/A	Location Flooring	N/A
Style	N/A	Style	N/A
Finish	N/A	Finish	N/A
Marble	N/A	Marble	N/A
Hearth	N/A	Hearth	N/A

Notes

**APPLIANCES - INSTALL STANDARD APPLIANCE PACKAGE
**KITCHEN SINK - Install Standard Undermount Sink - Kindred Reginox Undermount Sink - Model #ND1831UA-9
**KITCHEN FAUCET - Install Standard Faucet - DELTA Oster Single Handle Pull-Down(Single Hole) Kitchen Faucet - Model # 976LF - Chrome

Decor Consultant:

Purchaser:

Vendor:

Page 2 of 3

Decor Consultant:

Purchaser:

Vendor:


Lot: 63 BLOCK 234 Project: Grovetrail Developments Inc. Model: MACKENZIE END-OPT 2ND LEVEL-ELEV B

Printed Feb 28, 2025 12:48 pm



Jan. 29, 2025
52

Cable (C)
Telephone (T)
Conduit (x1)
Electrical (GFCI) (x1) - (E)

Additional
curbway rough-in

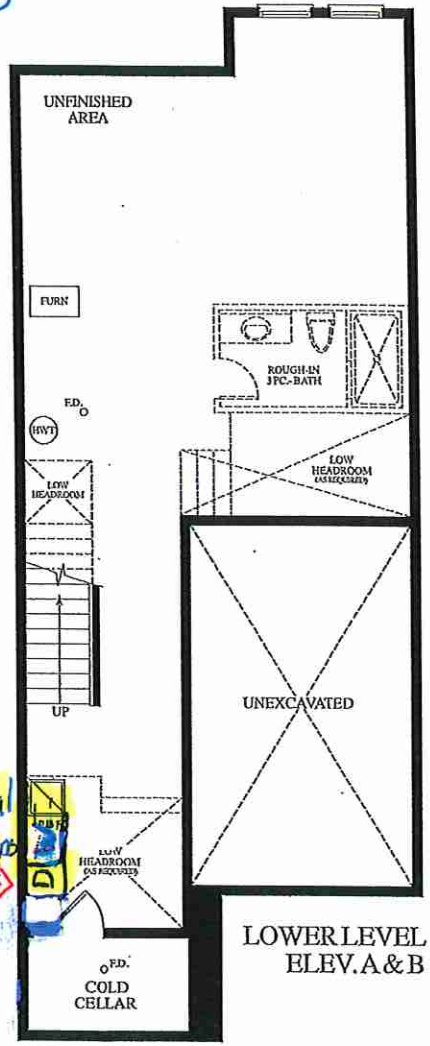

OAKRIDGE
MEADOWS

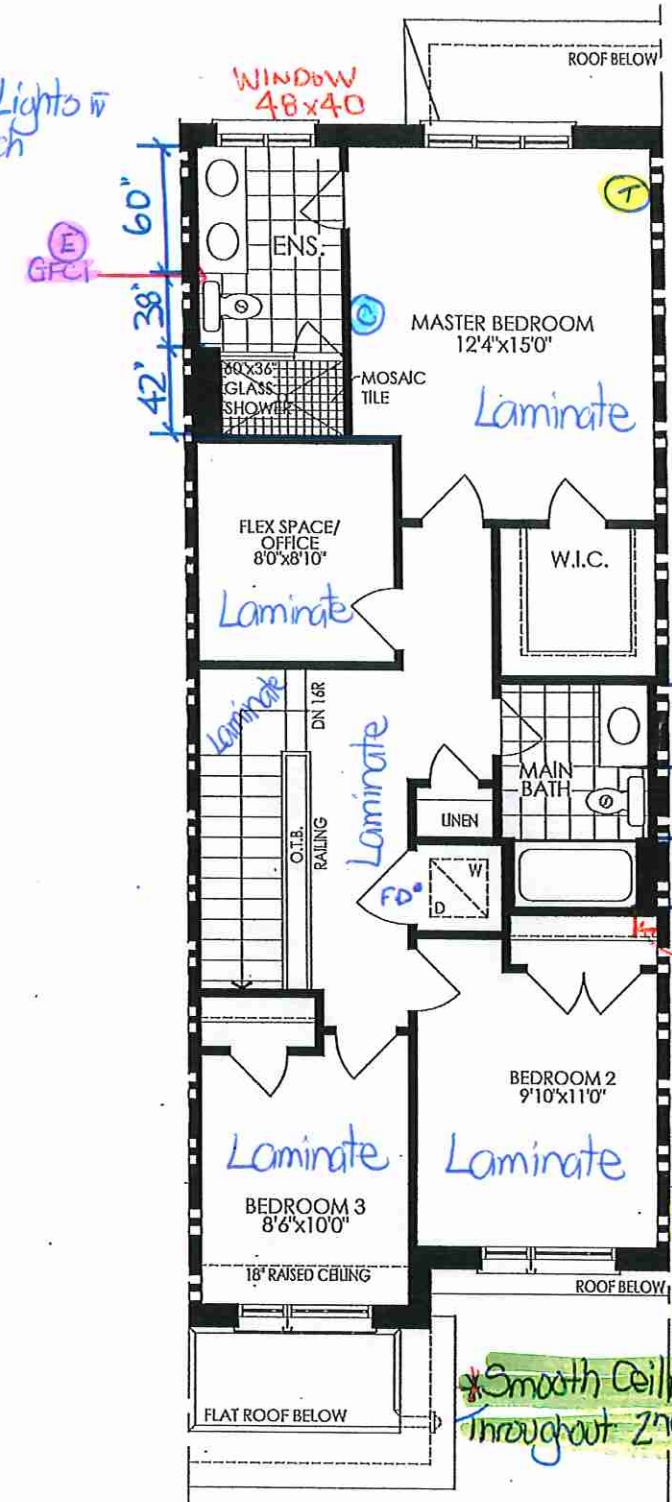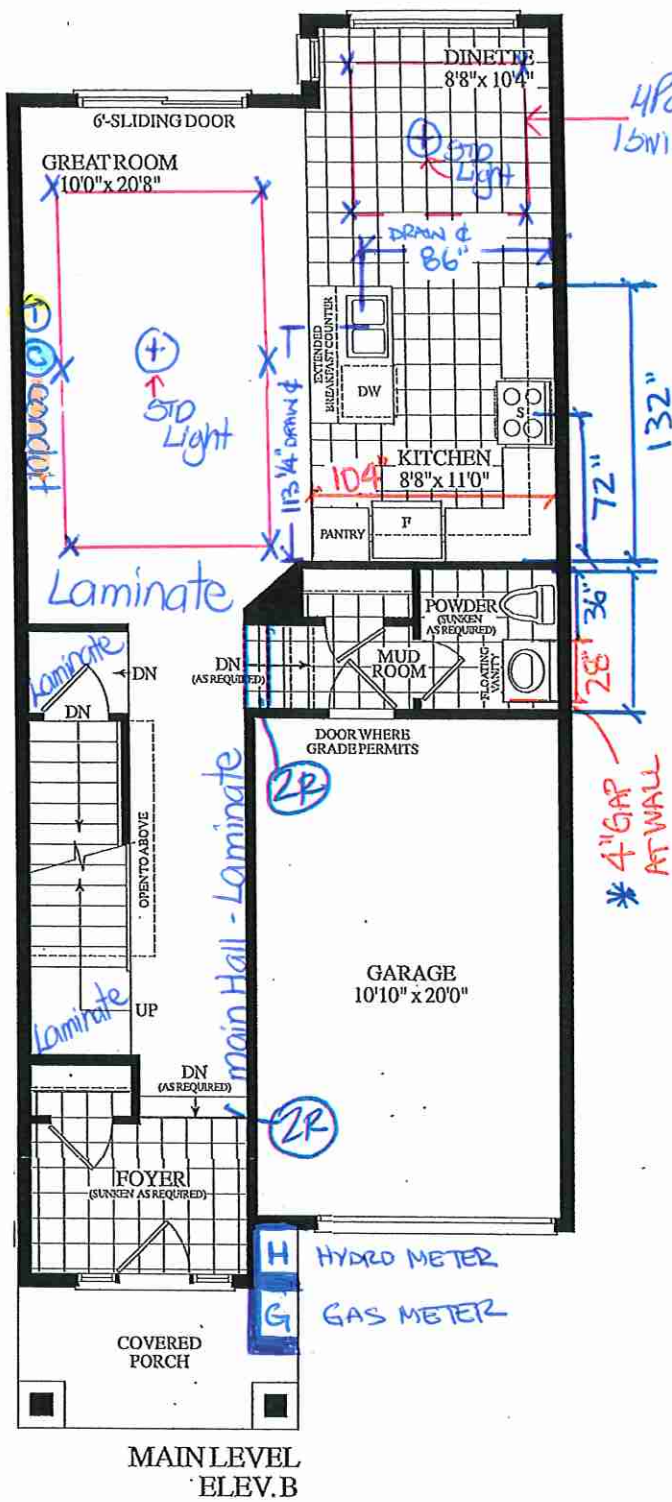

Smooth Ceilings
throughout 2nd Floor

BLK. 234 TH 63 20-09 THE MACKENZIE EL. B 1710 SQ. FT.

Lot 63/BLK 234

Villa
KITCHENS & FINE CABINETRY LTD

8111 Jane St. Unit 10
Concord, Ontario L4K 4L7
Tel. (905) 669-7028
Fax. (905) 669-7903
email: designstudio@villakitchens.ca
www.villakitchens.ca


CLIENT: ROYAL PINE

PROJECT: OAKRIDGE MEADOWS
ADDRESS: RP-OM-BLK 242 LOT 63
MODEL: MACKENZIE 20-09

KITCHEN PLAN VIEW

DOOR STYLE: EURO
DOOR PROFILE: N/A
FINISH COLOUR: FOG GREY
DOOR MATERIAL: MELAMINE
INTERIOR COLOUR:
CROWN MOULDING: LRG EURO CM
PAN MOLD: SQUARE
COUNTERTOP:
INSTALL HEIGHT:
DECORATIVE HARDWARE:
HINGES: STANDARD
DRAWER SLIDES: STANDARD
DOOR UPGRADE:
EXTRAS:

DRAWN BY: ELISA
DATE: MAR 6/25
REVISION:
SCALE: 5/8" = 1'
PAGE: 1 OF 7

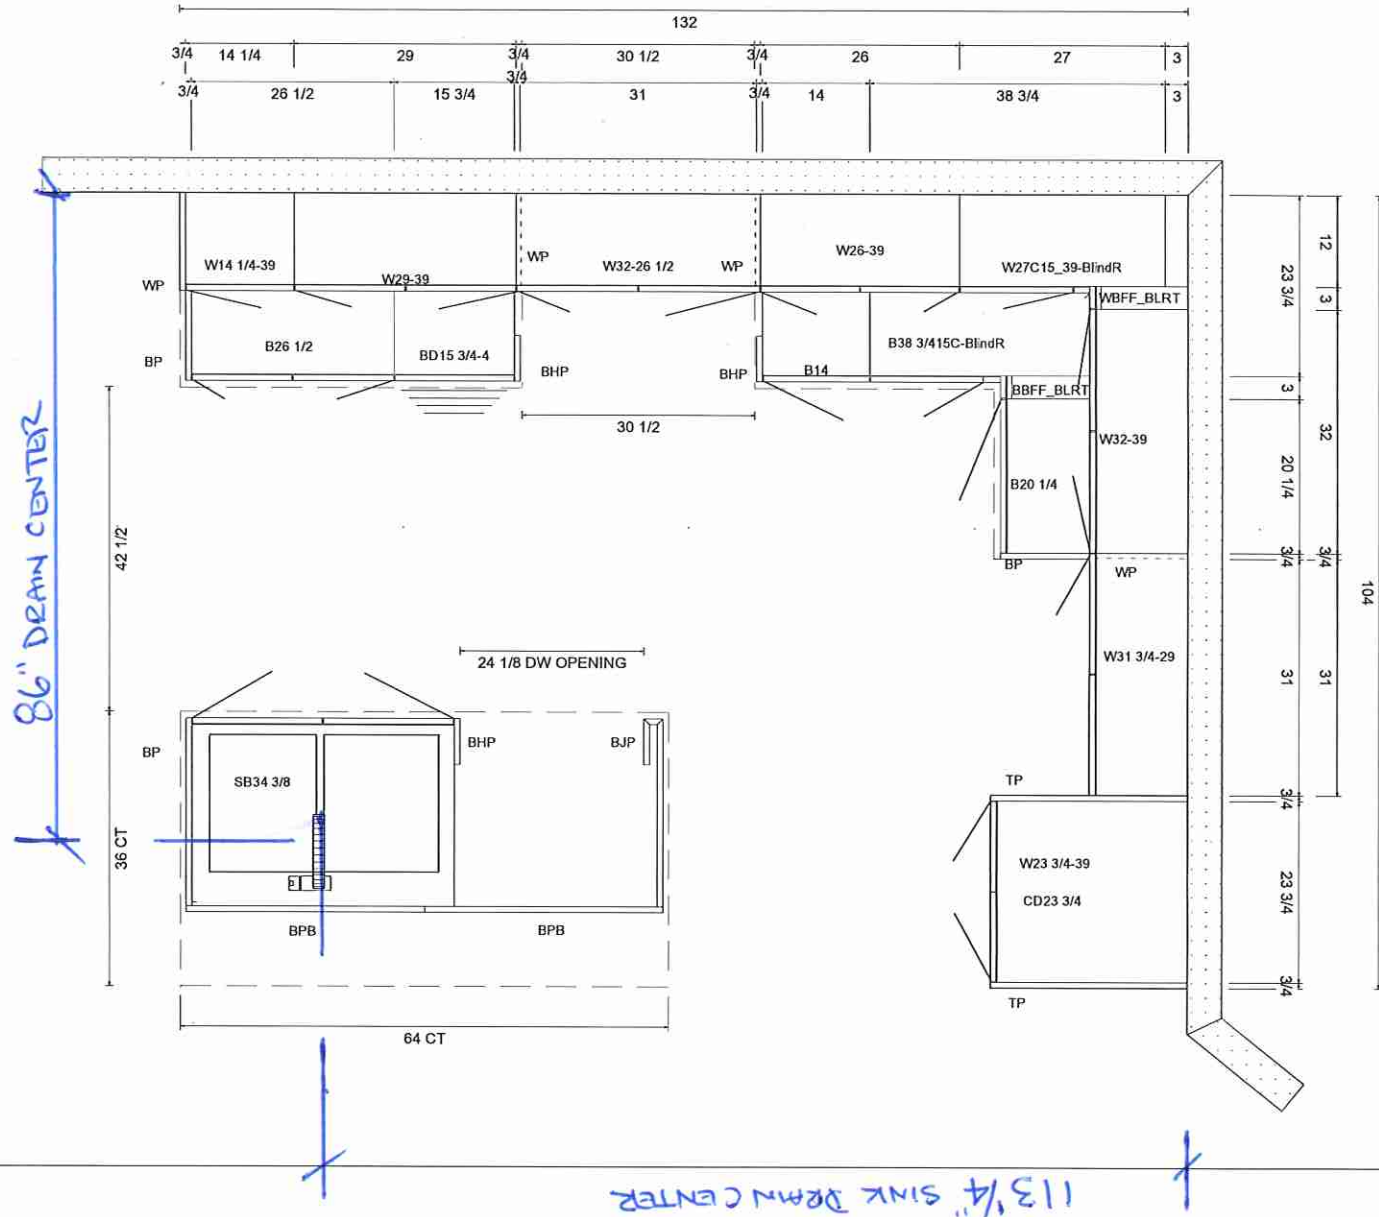

Lot 63/BLK 234




8111 Jane St. Unit 10
Concord, Ontario L4K 4L7
Tel. (905) 669-7028
Fax. (905) 669-7903
email: designstudio@villakitchens.ca
www.villakitchens.ca

CLIENT: ROYAL PINE
PROJECT: OAKRIDGE MEADOWS
ADDRESS: RP-OM-BLK 242 LOT 63
MODEL: MACKENZIE 20-09

KITCHEN ELEVATION

FINISH COLOUR: FOG GREY
DOOR PROFILE: N/A
FINISH COLOUR: FOG GREY
DOOR MATERIAL: MELAMINE
INTERIOR COLOUR:
CROWN MOULDING: LRG EURO CM
PAN MOLD: SQUARE
COUNTERTOP:
INSTALL HEIGHT:
DECORATIVE HARDWARE:
HINGES: STANDARD
DRAWER SLIDES: STANDARD
DOOR UPGRADE:
EXTRAS:

DRAWN BY: ELISA
DATE: MAR 6/25
REVISION:
SCALE: 5/8" = 1'
PAGE: 2 OF 7

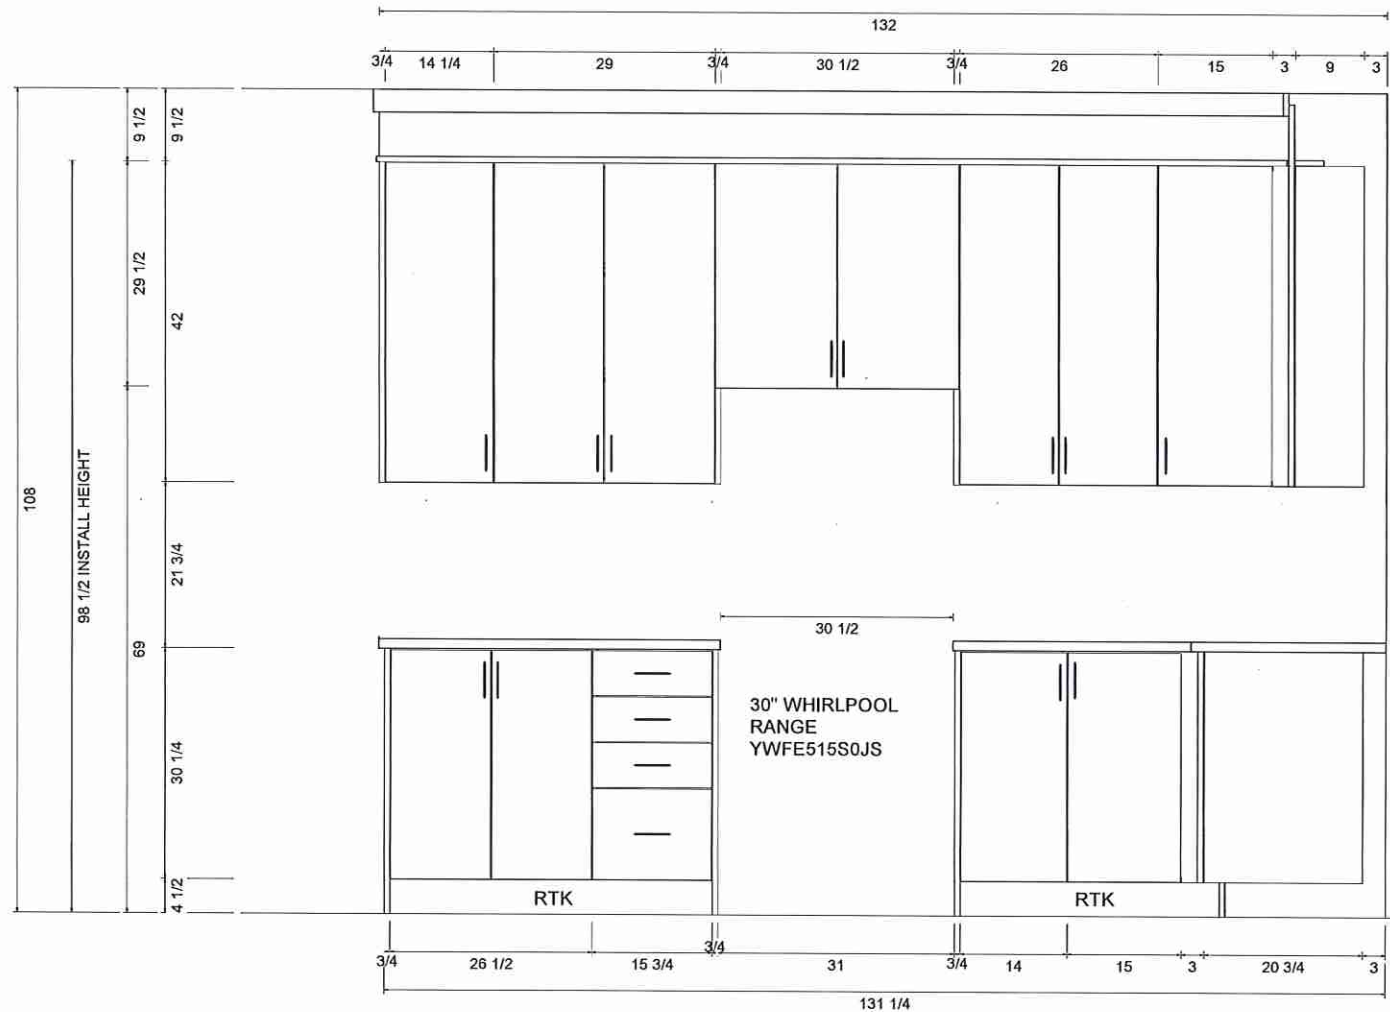

Lot 63 / BIK 234

Villa

KITCHENS & FINE CABINETS LTD

8111 Jane St. Unit 10
Concord, Ontario L4K 4L7
Tel. (905) 669-7028
Fax. (905) 669-7903
email: designstudio@villakitchens.ca
www.villakitchens.ca

CLIENT: ROYAL PINE

PROJECT: OAKRIDGE MEADOWS

ADDRESS: RP-OM-BLK 242 LOT 63

MODEL: MACKENZIE 20-09

KITCHEN ELEVATION

DOOR STYLE: EURO

DOOR PROFILE: N/A

FINISH COLOUR: FOG GREY

DOOR MATERIAL: MELAMINE

INTERIOR COLOUR:

CROWN MOULDING: LRG EURO CM

PAN MOLD: SQUARE

COUNTERTOP:

INSTALL HEIGHT:

DECORATIVE HARDWARE:

HINGES: STANDARD

DRAWER SLIDES: STANDARD

DOOR UPGRADE:

EXTRAS:


DRAWN BY: ELISA

DATE: MAR 6/25

REVISION:

SCALE: 5/8" = 1'

PAGE: 3 OF 7

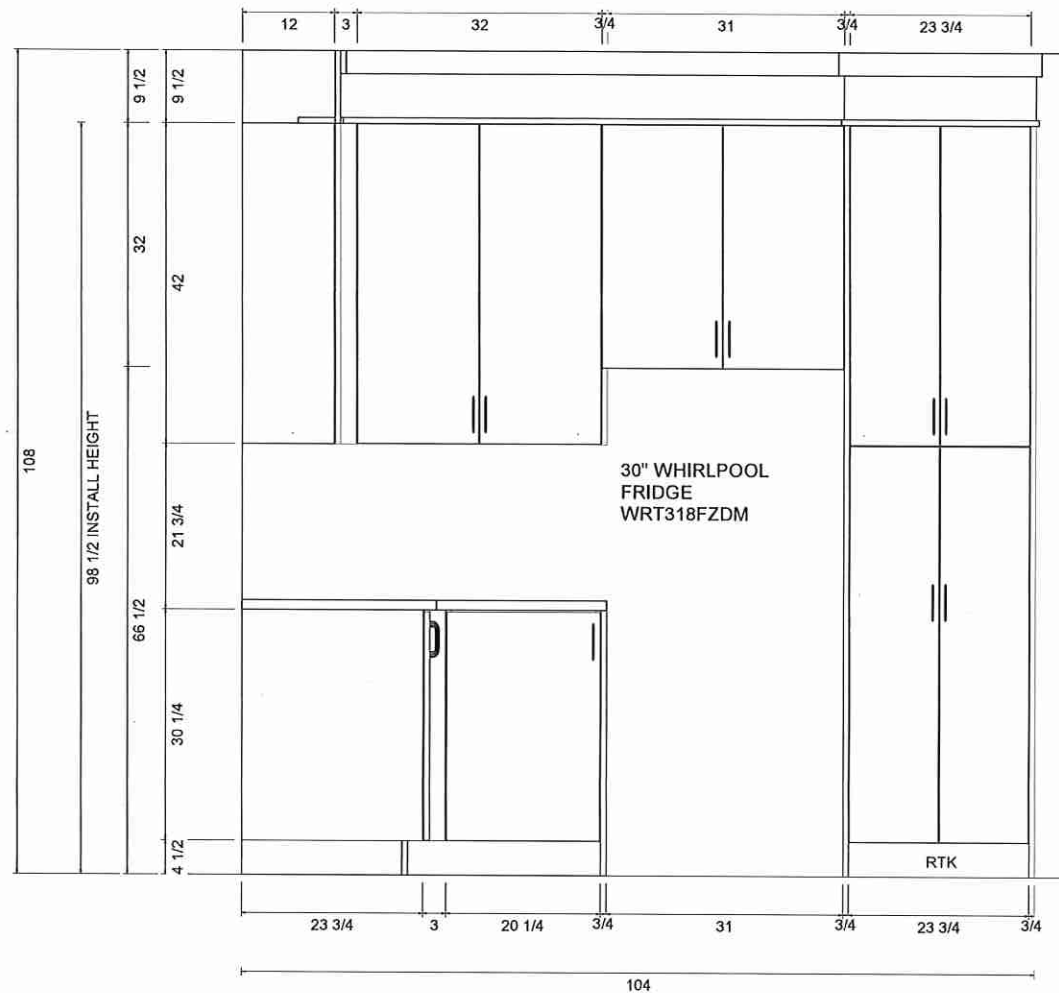

Lot 63/BLK 234

Villa
KITCHENS & FINE CABINETRY LTD





8111 Jane St. Unit 10
Concord, Ontario L4K 4L7
Tel. (905) 669-7028
Fax. (905) 669-7903
email: designstudio@villakitchens.ca
www.villakitchens.ca

CLIENT: ROYAL PINE
PROJECT: OAKRIDGE MEADOWS
ADDRESS: RP-OM-BLK 242 LOT 63
MODEL: MACKENZIE 20-09

KITCHEN ISLAND ELEVATION

DOOR STYLE: EURO
DOOR PROFILE: N/A
FINISH COLOUR: FOG GREY
DOOR MATERIAL: MELAMINE
INTERIOR COLOUR:
CROWN MOULDING: LRG EURO CM
PAN MOLD: SQUARE
COUNTERTOP:
INSTALL HEIGHT:
DECORATIVE HARDWARE:
HINGES: STANDARD
DRAWER SLIDES: STANDARD
DOOR UPGRADE:
EXTRAS:

DRAWN BY: ELISA
DATE: MAR 6/25
REVISION:
SCALE: 5/8" = 1'
PAGE: 4 OF 7

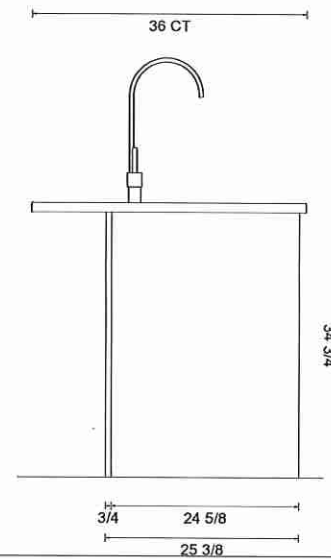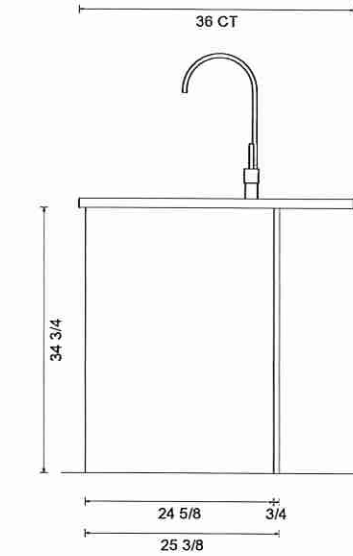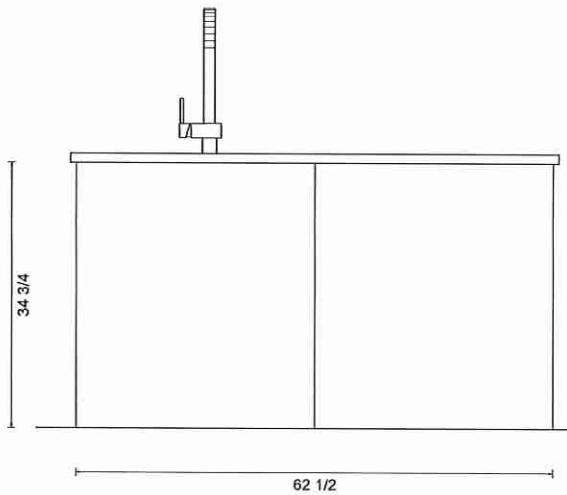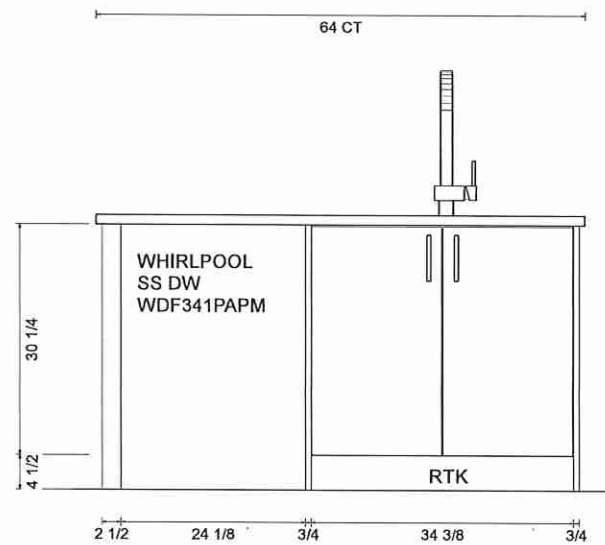

Lot 63/BLK 234

Villa

KITCHENS & FINE CABINETRY LTD

8111 Jane St. Unit 10
Concord, Ontario L4K 4L7
Tel. (905) 669-7028
Fax. (905) 669-7903
email: designstudio@villakitchens.ca
www.villakitchens.ca

CLIENT: ROYAL PINE

PROJECT: OAKRIDGE MEADOWS

ADDRESS: RP-OM-BLK 242 LOT 63

MODEL: MACKENZIE 20-09

POWDER RM

DOOR STYLE:

DOOR PROFILE:

FINISH COLOUR:

DOOR MATERIAL:

INTERIOR COLOUR:

CROWN MOULDING: N/A

LIGHT VALANCE: N/A

COUNTERTOP:

INSTALL HEIGHT:

DECORATIVE HARDWARE:

HINGES: STANDARD

DRAWER SLIDES: N/A

DOOR UPGRADE:

EXTRAS:



DRAWN BY: ELISA

DATE: MAR 6/25

REVISION:

SCALE: 0

PAGE: 5 OF 7

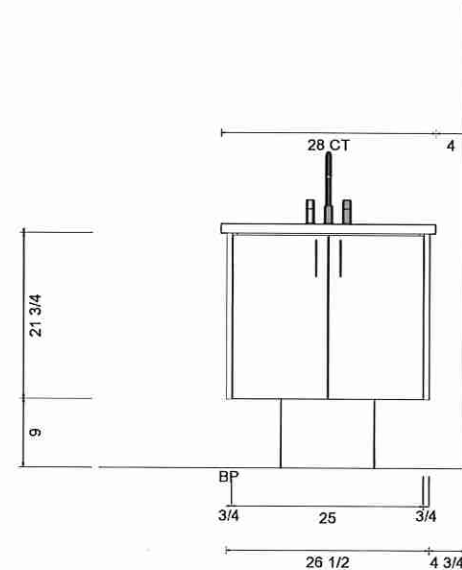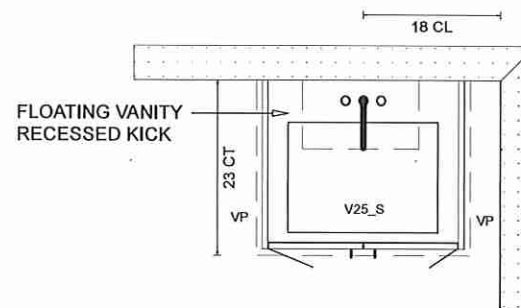

Lot 63 / BLK 234

Villa
KITCHENS & FINE CABINETRY LTD

8111 Jane St. Unit 10
Concord, Ontario L4K 4L7
Tel. (905) 669-7028
Fax. (905) 669-7903
email: designstudio@villakitchens.ca
www.villakitchens.ca

CLIENT: ROYAL PINE

PROJECT: OAKRIDGE MEADOWS

ADDRESS: RP-OM-BLK 242 LOT 63

MODEL: MACKENZIE 20-09

PRIMARY VANITY OPT

DOOR STYLE:

DOOR PROFILE:

FINISH COLOUR:

DOOR MATERIAL:

INTERIOR COLOUR:

CROWN MOULDING: N/A

LIGHT VALANCE: N/A

COUNTERTOP:

INSTALL HEIGHT:

DECORATIVE HARDWARE:

HINGES: STANDARD

DRAWER SLIDES: N/A

DOOR UPGRADE:

EXTRAS:



DRAWN BY: ELISA

DATE: MAR 6/25

REVISION:

SCALE: 0

PAGE: 6 OF 7

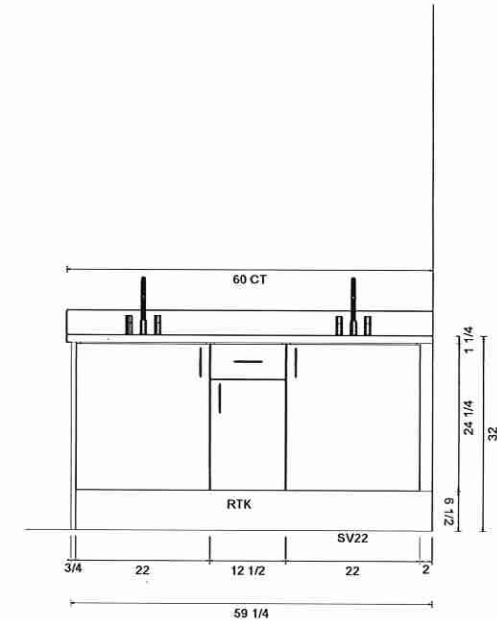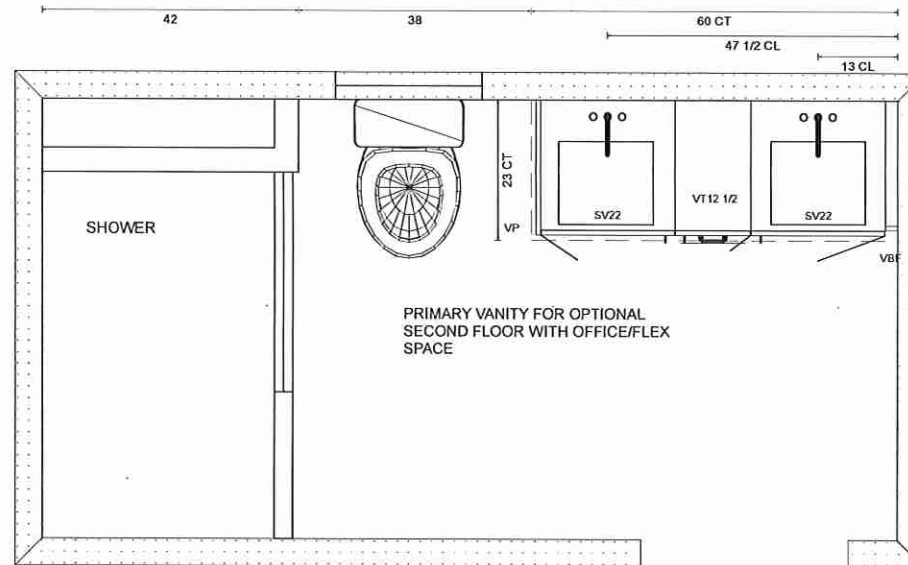

Lot 63/BLK 234

Villa
KITCHENS & FINE CABINETRY LTD.

8111 Jane St. Unit 10
Concord, Ontario L4K 4L7
Tel. (905) 669-7028
Fax. (905) 669-7903
email: designstudio@villakitchens.ca
www.villakitchens.ca

CLIENT: ROYAL PINE

PROJECT: OAKRIDGE MEADOWS

ADDRESS: RP-OM-BLK 242 LOT 63

MODEL: MACKENZIE 20-09

MAIN VANITY

DOOR STYLE:

DOOR PROFILE:

FINISH COLOUR:

DOOR MATERIAL:

INTERIOR COLOUR:

CROWN MOULDING: N/A

LIGHT VALANCE: N/A

COUNTERTOP:

INSTALL HEIGHT:

DECORATIVE HARDWARE:

HINGES: STANDARD

DRAWER SLIDES: N/A

DOOR UPGRADE:

EXTRAS:

DRAWN BY: ELISA

DATE: MAR 6/25

REVISION:

SCALE: 0

PAGE: 7 OF 7

