



Valecraft

Homes Ltd.



PLACE ST-THOMAS - PHASE 6
MODEL: 110 THE THOMAS
BLOCK: D
LOT: 21
ADDRESS: 737 NAMUR STREET

PLACE ST-THOMAS - PHASE 6
MODEL: 140 THE GREEN (REV)
BLOCK: D
LOT: 20
ADDRESS: 739 NAMUR STREET

PLACE ST-THOMAS - PHASE 6
MODEL: 120 THE HUNTLEY
BLOCK: D
LOT: 19
ADDRESS: 741 NAMUR STREET

PLACE ST-THOMAS - PHASE 6
MODEL: 160-2 THE STANLEY 2 (REV)
BLOCK: D
LOT: 18
ADDRESS: 743 NAMUR STREET

PLACE ST-THOMAS - PHASE 6
MODEL: 160-2 THE STANLEY 2
BLOCK: D
LOT: 17
ADDRESS: 745 NAMUR STREET



PLACE ST-THOMAS - PHASE 6
MODEL: 130 THE LEWIS (REV)
BLOCK: D
LOT: 16
ADDRESS: 747 NAMUR STREET

PLACE ST-THOMAS PHASE 6 - BLOCK D

DRAWING LIST:

- A.1 FRONT, LEFT AND RIGHT ELEVATIONS
- A.2 REAR ELEVATION AND BUILDING SECTIONS
- A.3 BUILDING SECTIONS
- A.4 FOOTING PLAN
- A.5 BASEMENT FLOOR PLAN
- A.6 GROUND FLOOR - FLOOR JOIST FRAMING PLAN
- A.7 GROUND FLOOR PLAN
- A.8 SECOND FLOOR - FLOOR JOIST FRAMING PLAN
- A.9 SECOND FLOOR PLAN
- A.10 ROOF PLAN

- A.11 WALL SECTIONS AND DETAILS
- A.12 DETAILS
- E.1 BASEMENT FLOOR - ELECTRICAL PLAN
- E.2 GROUND FLOOR - ELECTRICAL PLAN
- E.3 SECOND FLOOR - ELECTRICAL PLAN

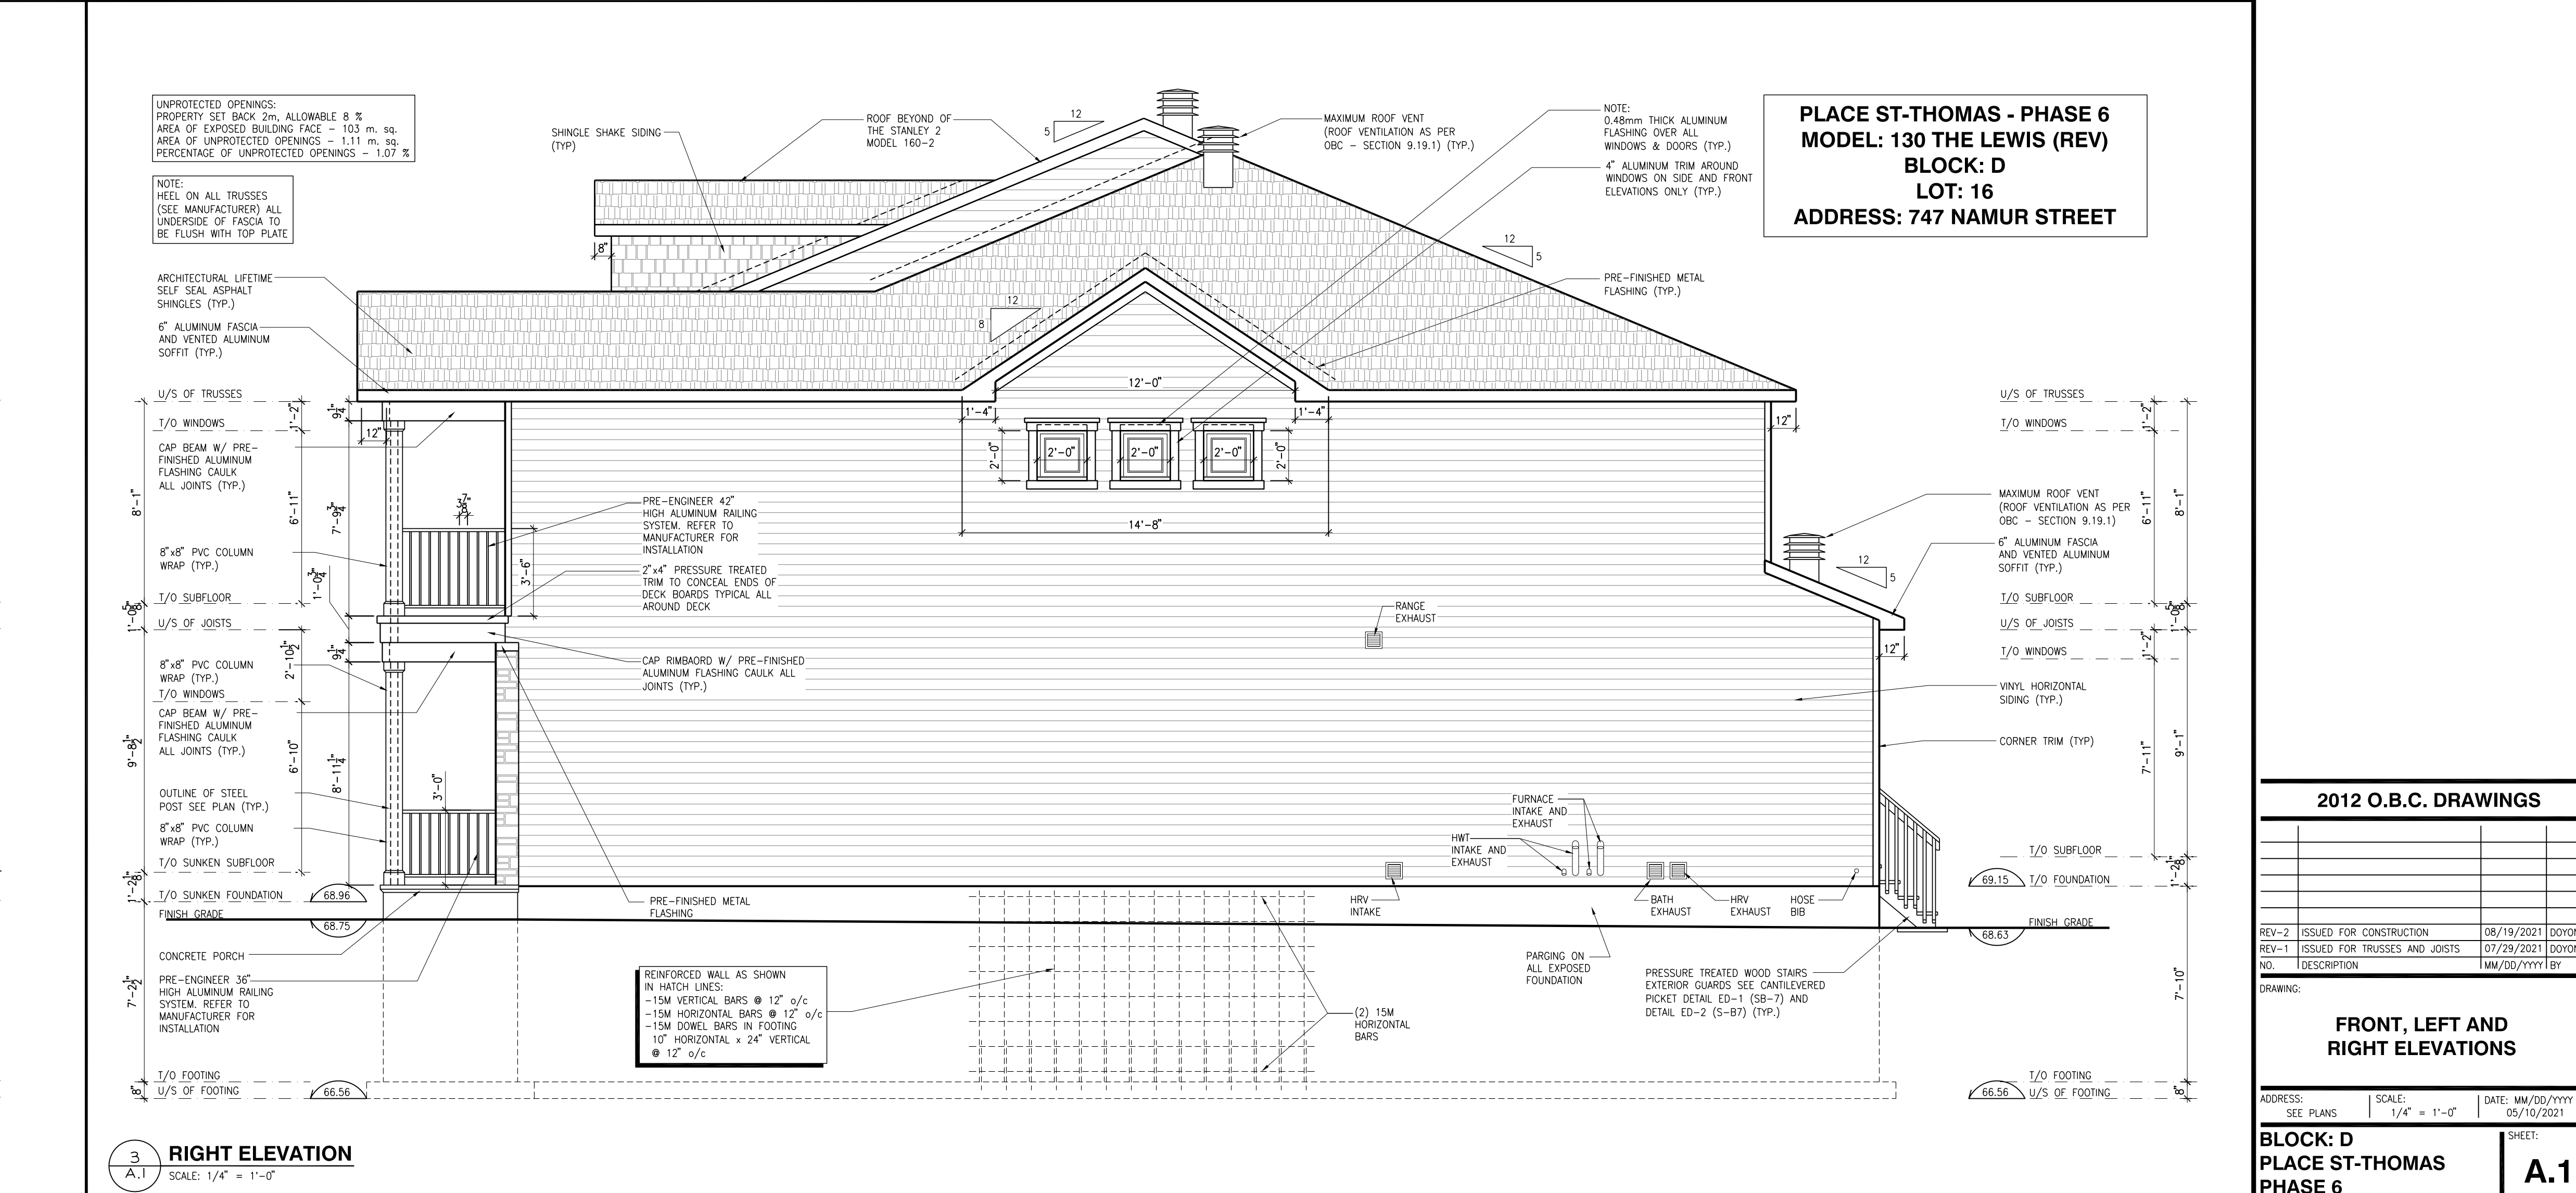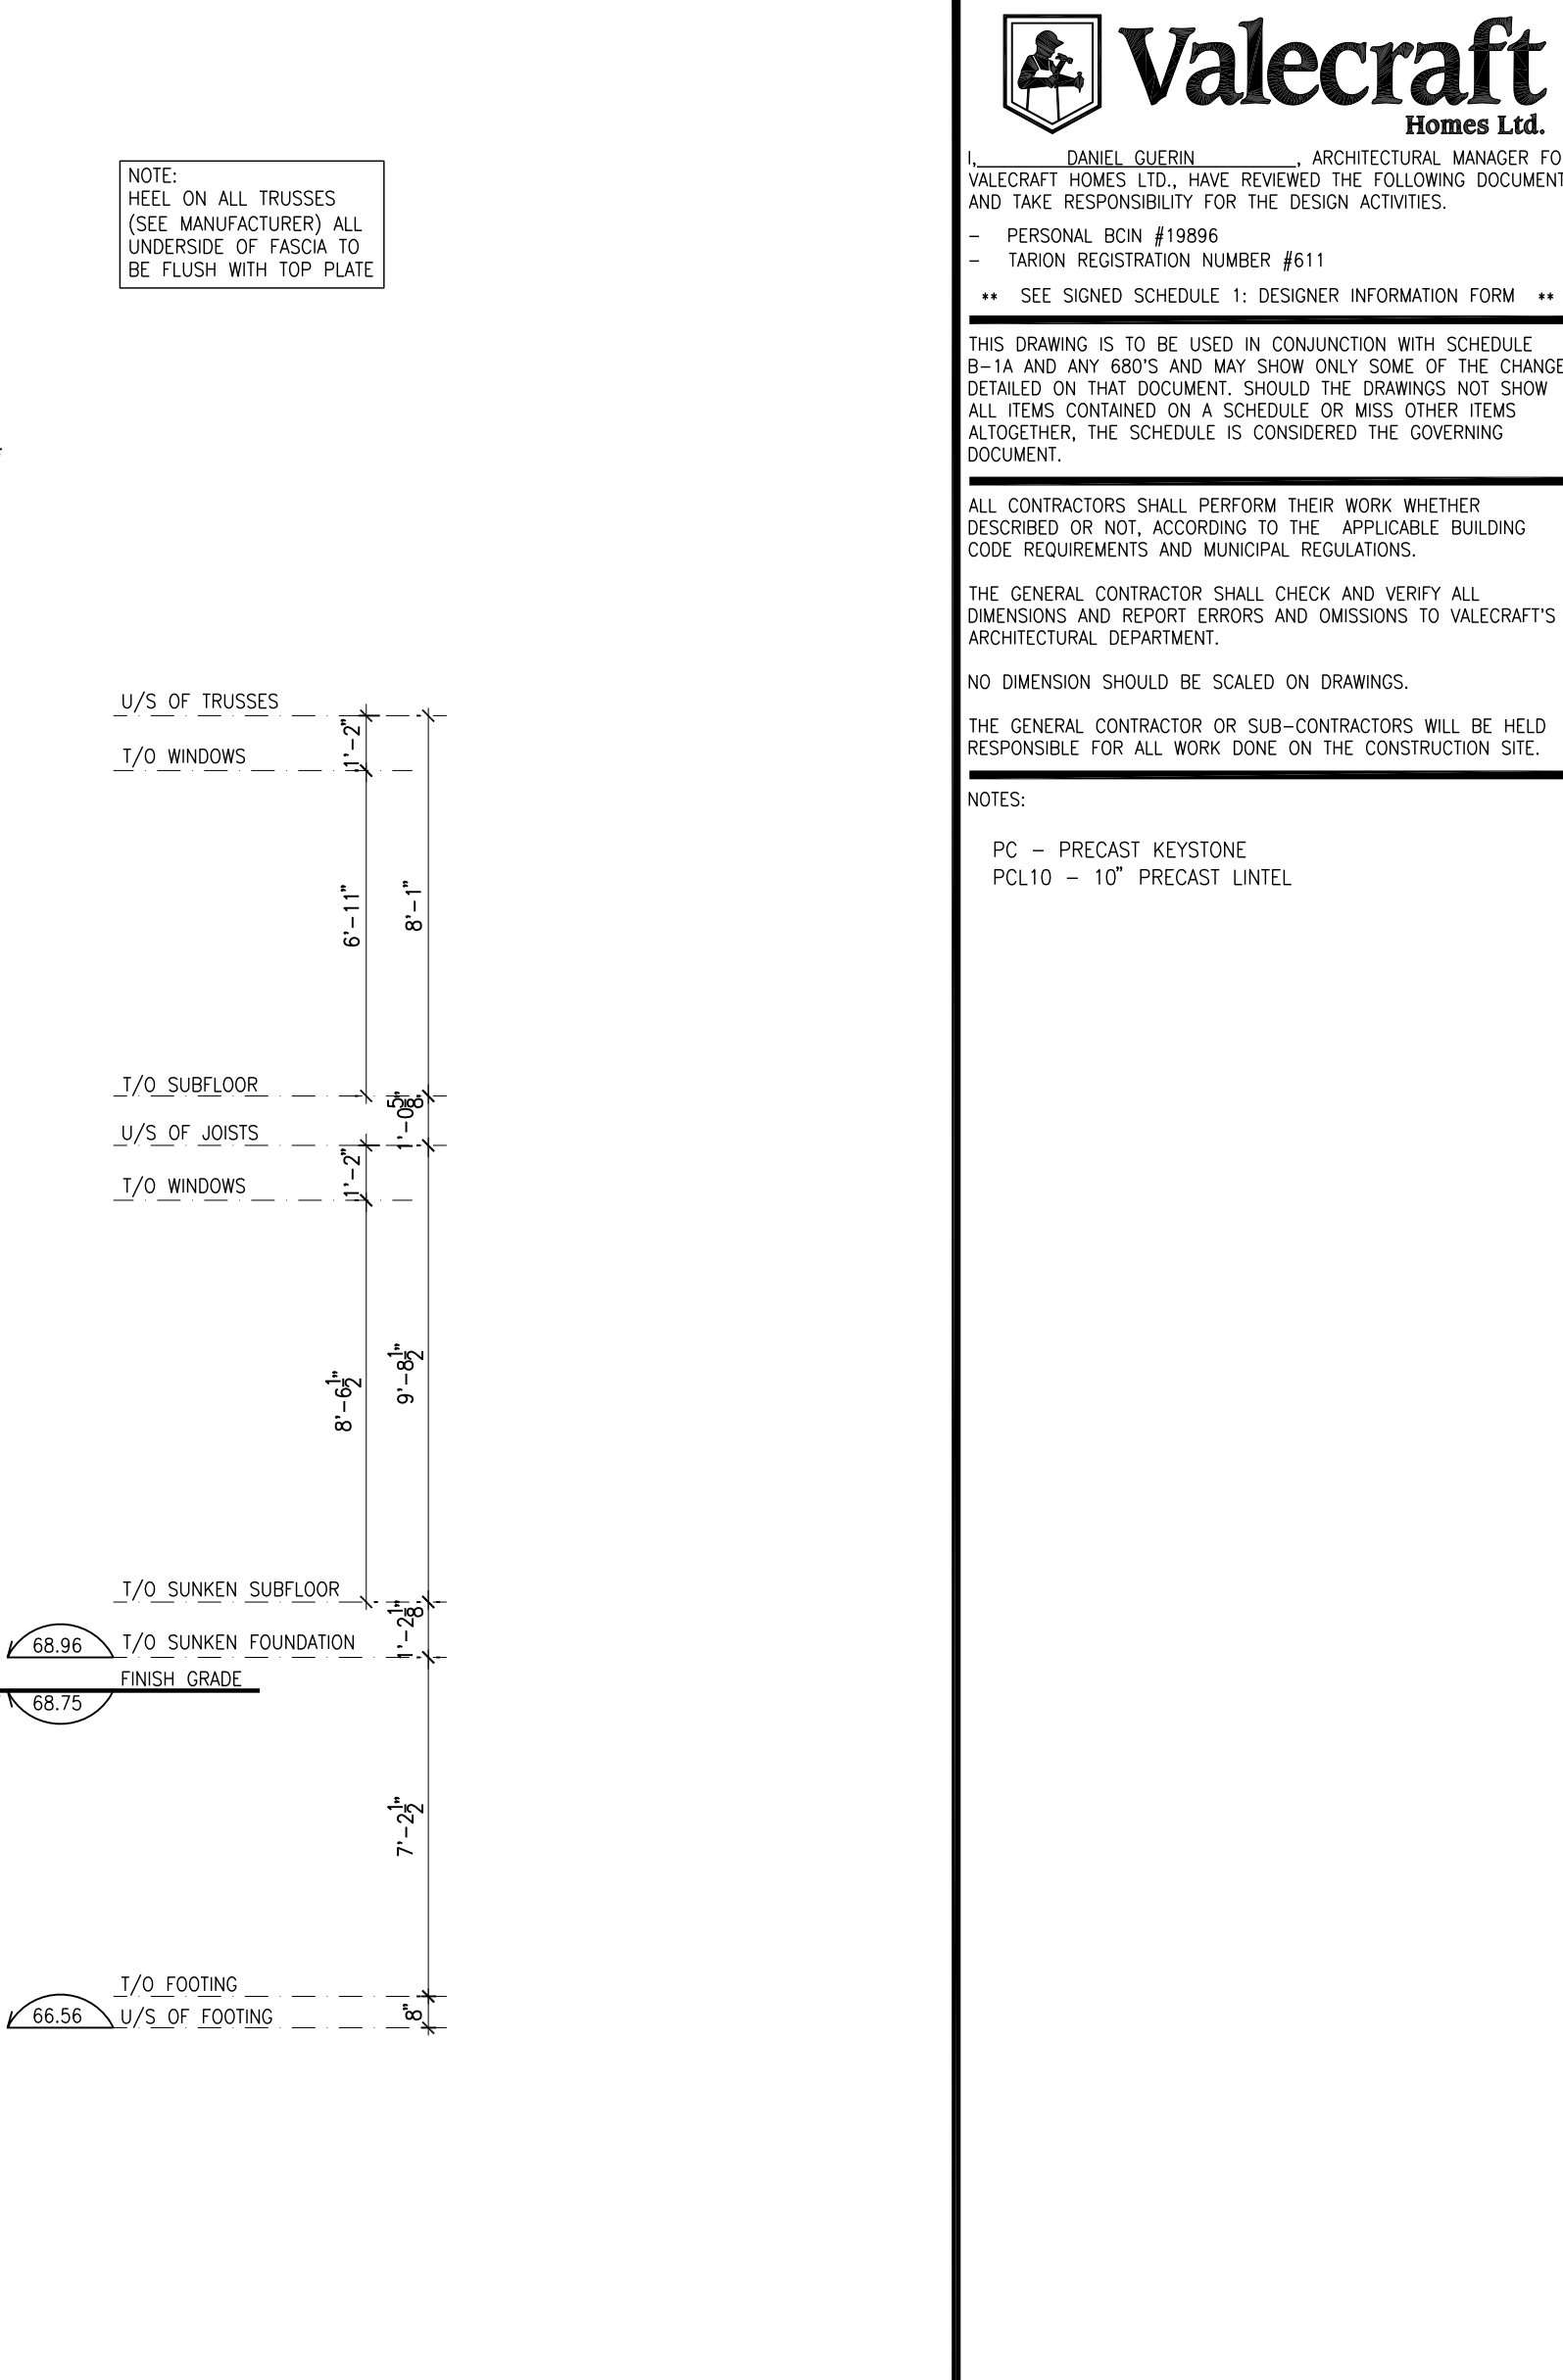

THIS DRAWING IS TO BE USED IN CONJUNCTION WITH SCHEDULE 8-14 AND ANY BIDS AND MAY SHOW ONLY SOME OF THE CHANGES DETAILED ON THAT DOCUMENT. SHOULD THE DRAWINGS NOT SHOW ALL ITEMS CONTAINED ON A SCHEDULE OR ANY OTHER ITEMS TOGETHER, THE SCHEDULE IS CONSIDERED THE GOVERNING DOCUMENT.


ALL CONTRACTORS SHALL PERFORM THEIR WORK WHETHER DESCRIBED OR NOT, ACCORDING TO THE APPLICABLE BUILDING CODE REQUIREMENTS AND MUNICIPAL REGULATIONS.

THE GENERAL CONTRACTOR SHALL CHECK AND VERIFY ALL DIMENSIONS AND REPORT ERRORS AND OMISSIONS TO VALECRAFT'S ARCHITECTURAL DEPARTMENT.

NO DIMENSION SHOULD BE SCALED ON DRAWINGS.

THE GENERAL CONTRACTOR OR SUB-CONTRACTORS WILL BE HELD RESPONSIBLE FOR ALL WORK DONE ON THE CONSTRUCTION SITE.

NOTES:

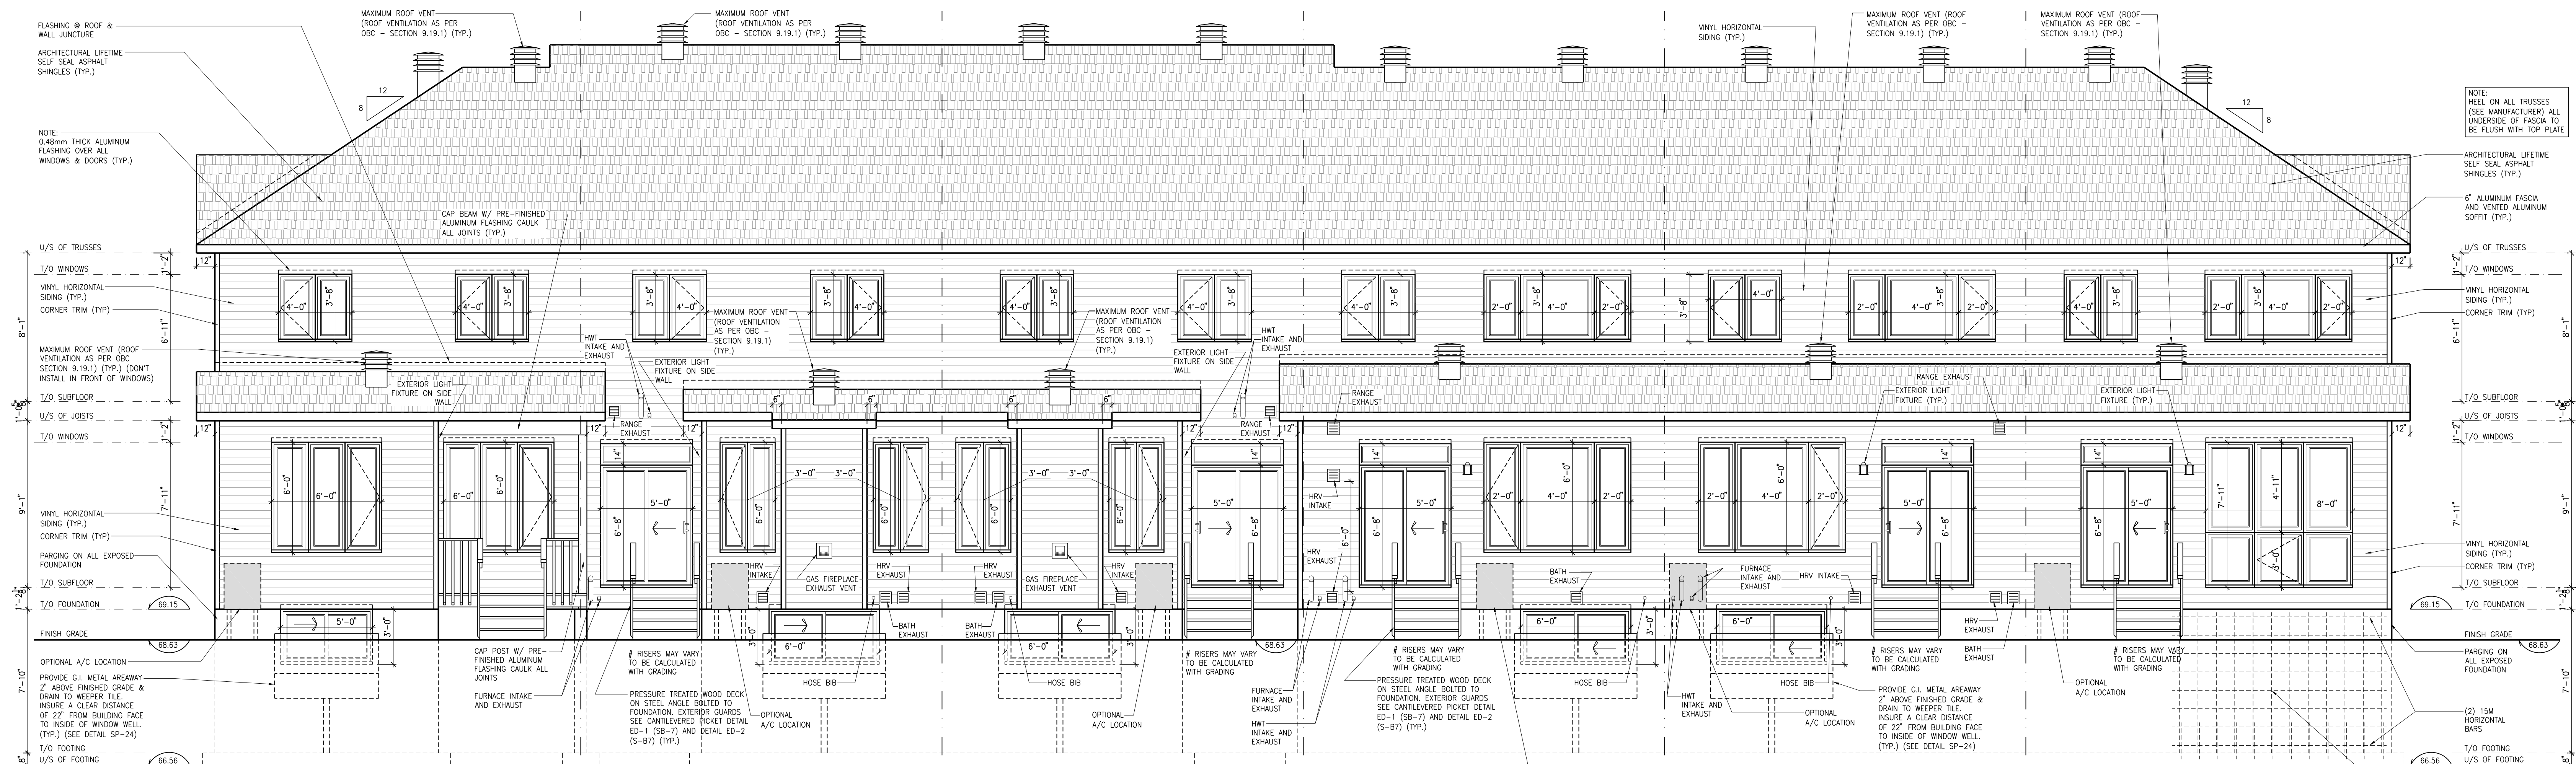

PLACE ST-THOMAS - PHASE 6
MODEL: 130 THE LEWIS (REV)
BLOCK: D
LOT: 16
ADDRESS: 747 NAMUR STREET

PLACE ST-THOMAS - PHASE 6
MODEL: 160-2 THE STANLEY 2
BLOCK: D
LOT: 17
ADDRESS: 745 NAMUR STREET


PLACE ST-THOMAS - PHASE 6
MODEL: 160-2 THE STANLEY 2 (REV)
BLOCK: D
LOT: 18
ADDRESS: 743 NAMUR STREET

PLACE ST-THOMAS - PHASE 6
MODEL: 120 THE HUNTLEY
BLOCK: D
LOT: 19
ADDRESS: 741 NAMUR STREET

PLACE ST-THOMAS - PHASE 6
MODEL: 140 THE GREEN (REV)
BLOCK: D
LOT: 20
ADDRESS: 739 NAMUR STREET


PLACE ST-THOMAS - PHASE 6
MODEL: 110 THE THOMAS
BLOCK: D
LOT: 21
ADDRESS: 737 NAMUR STREET

REAR ELEVATION
SCALE: 1/4" = 1'-0"

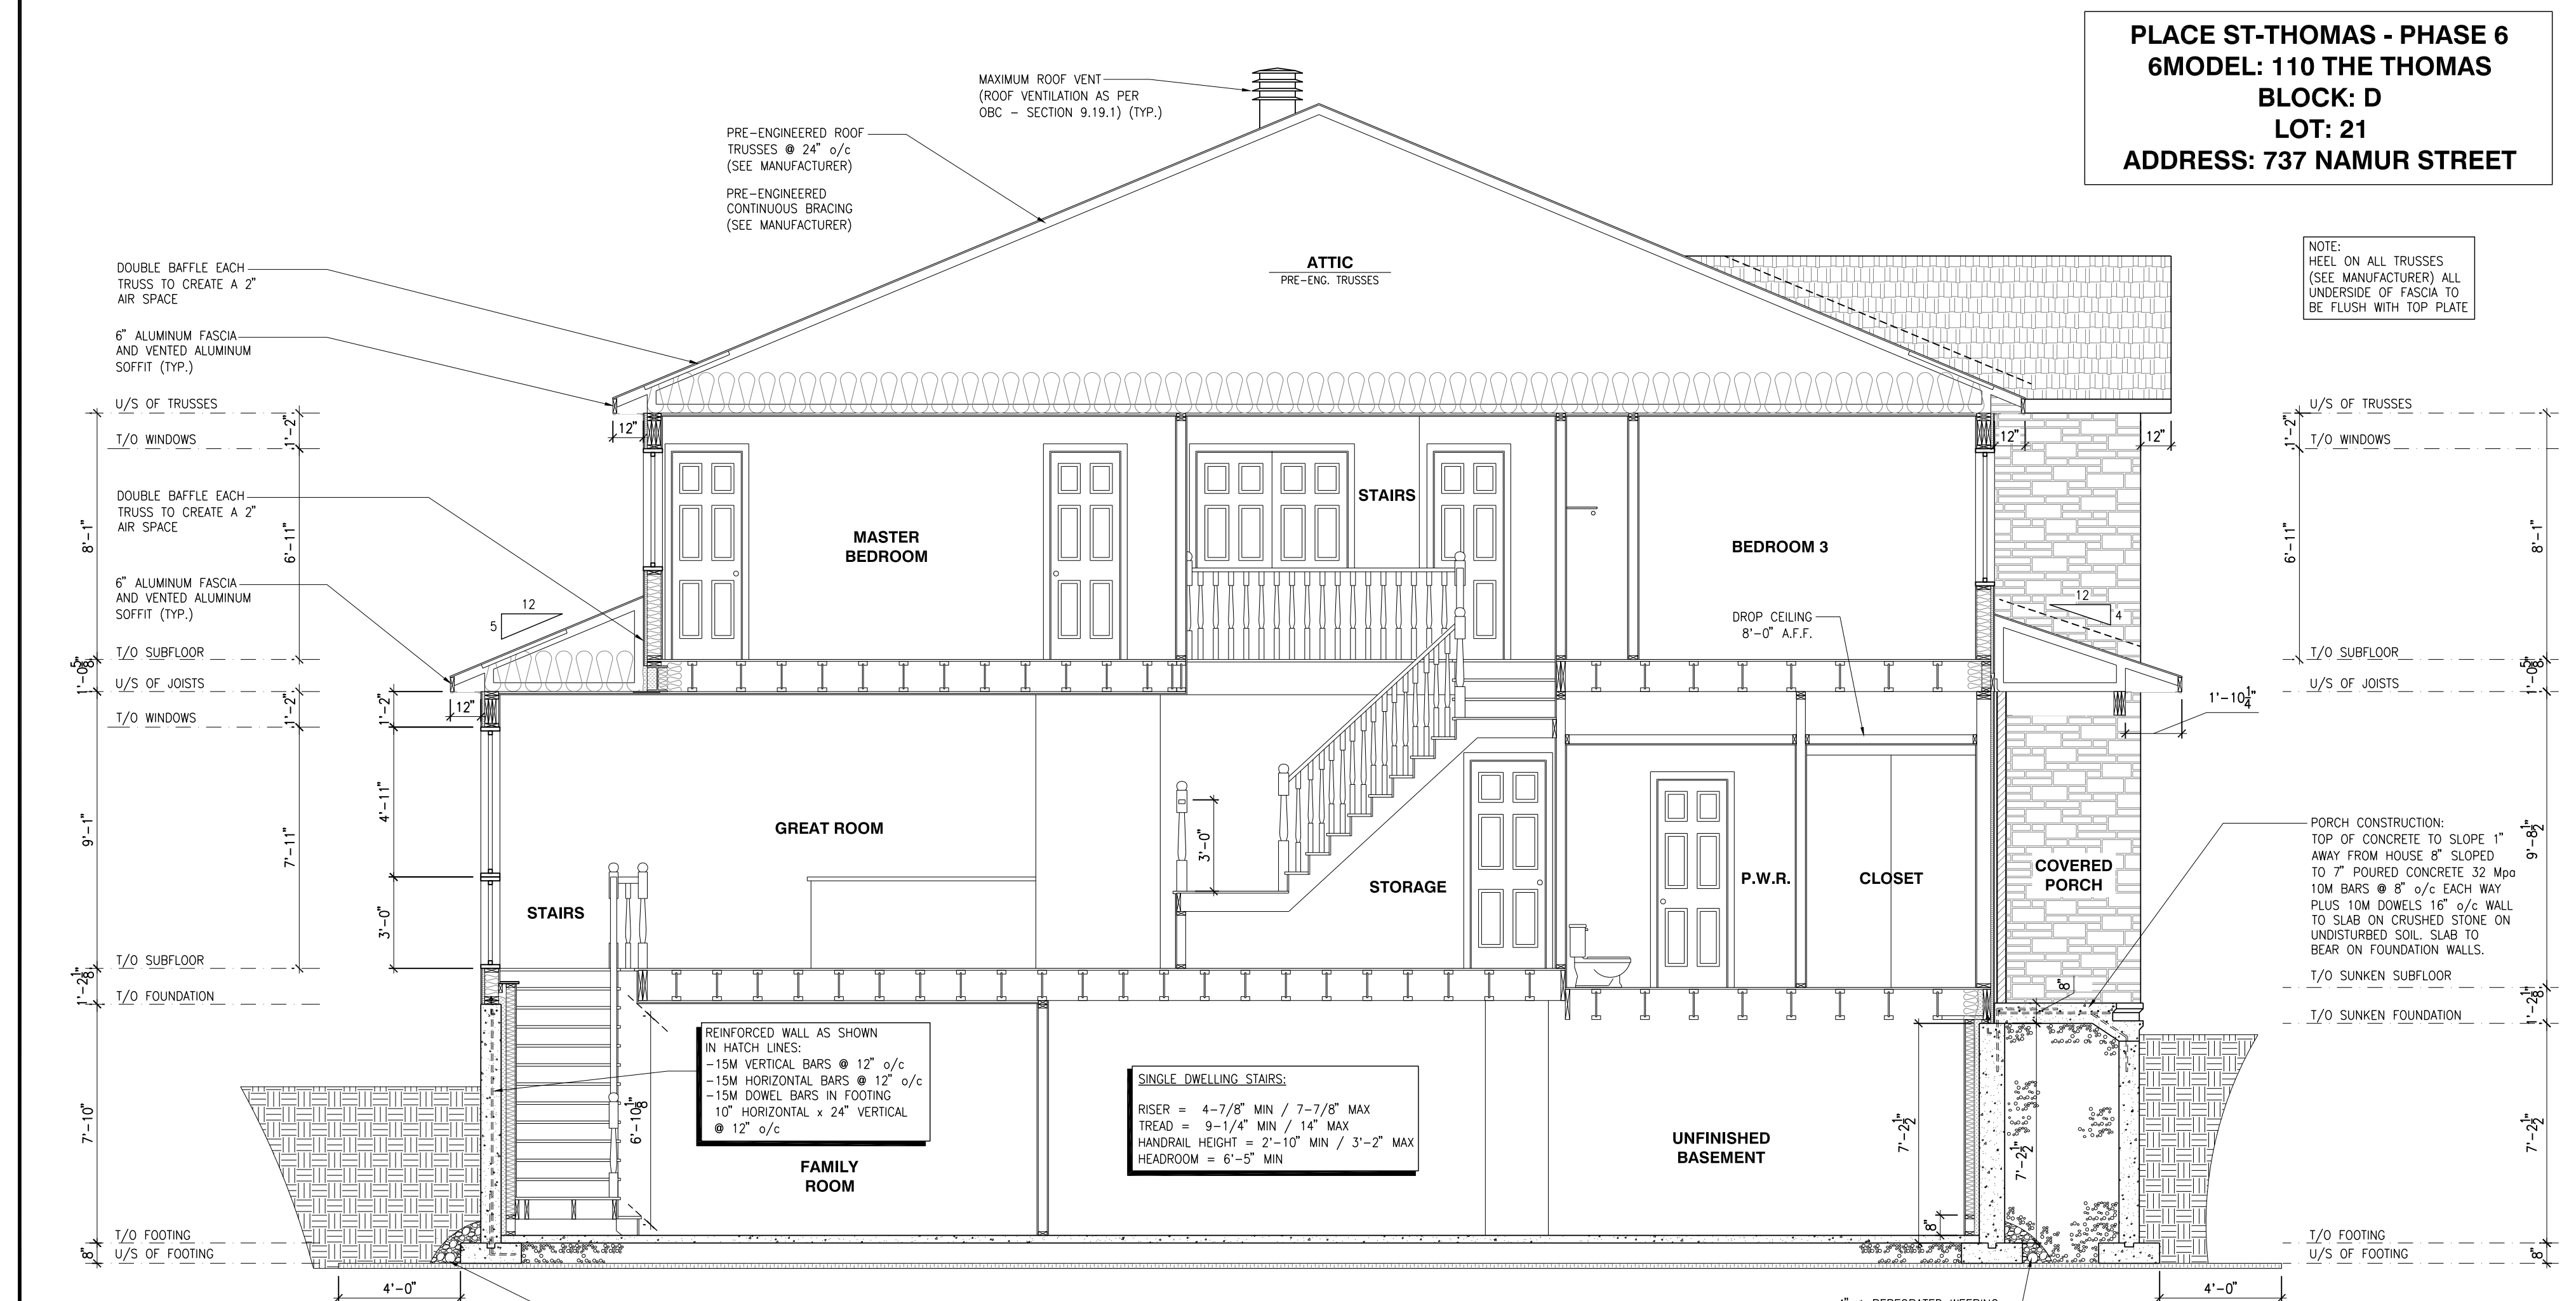

BUILDING SECTION - THE THOMAS MODEL 110
SCALE: 1/4" = 1'-0"

PLACE ST-THOMAS - PHASE 6
MODEL: 110 THE THOMAS
BLOCK: D
LOT: 21
ADDRESS: 737 NAMUR STREET

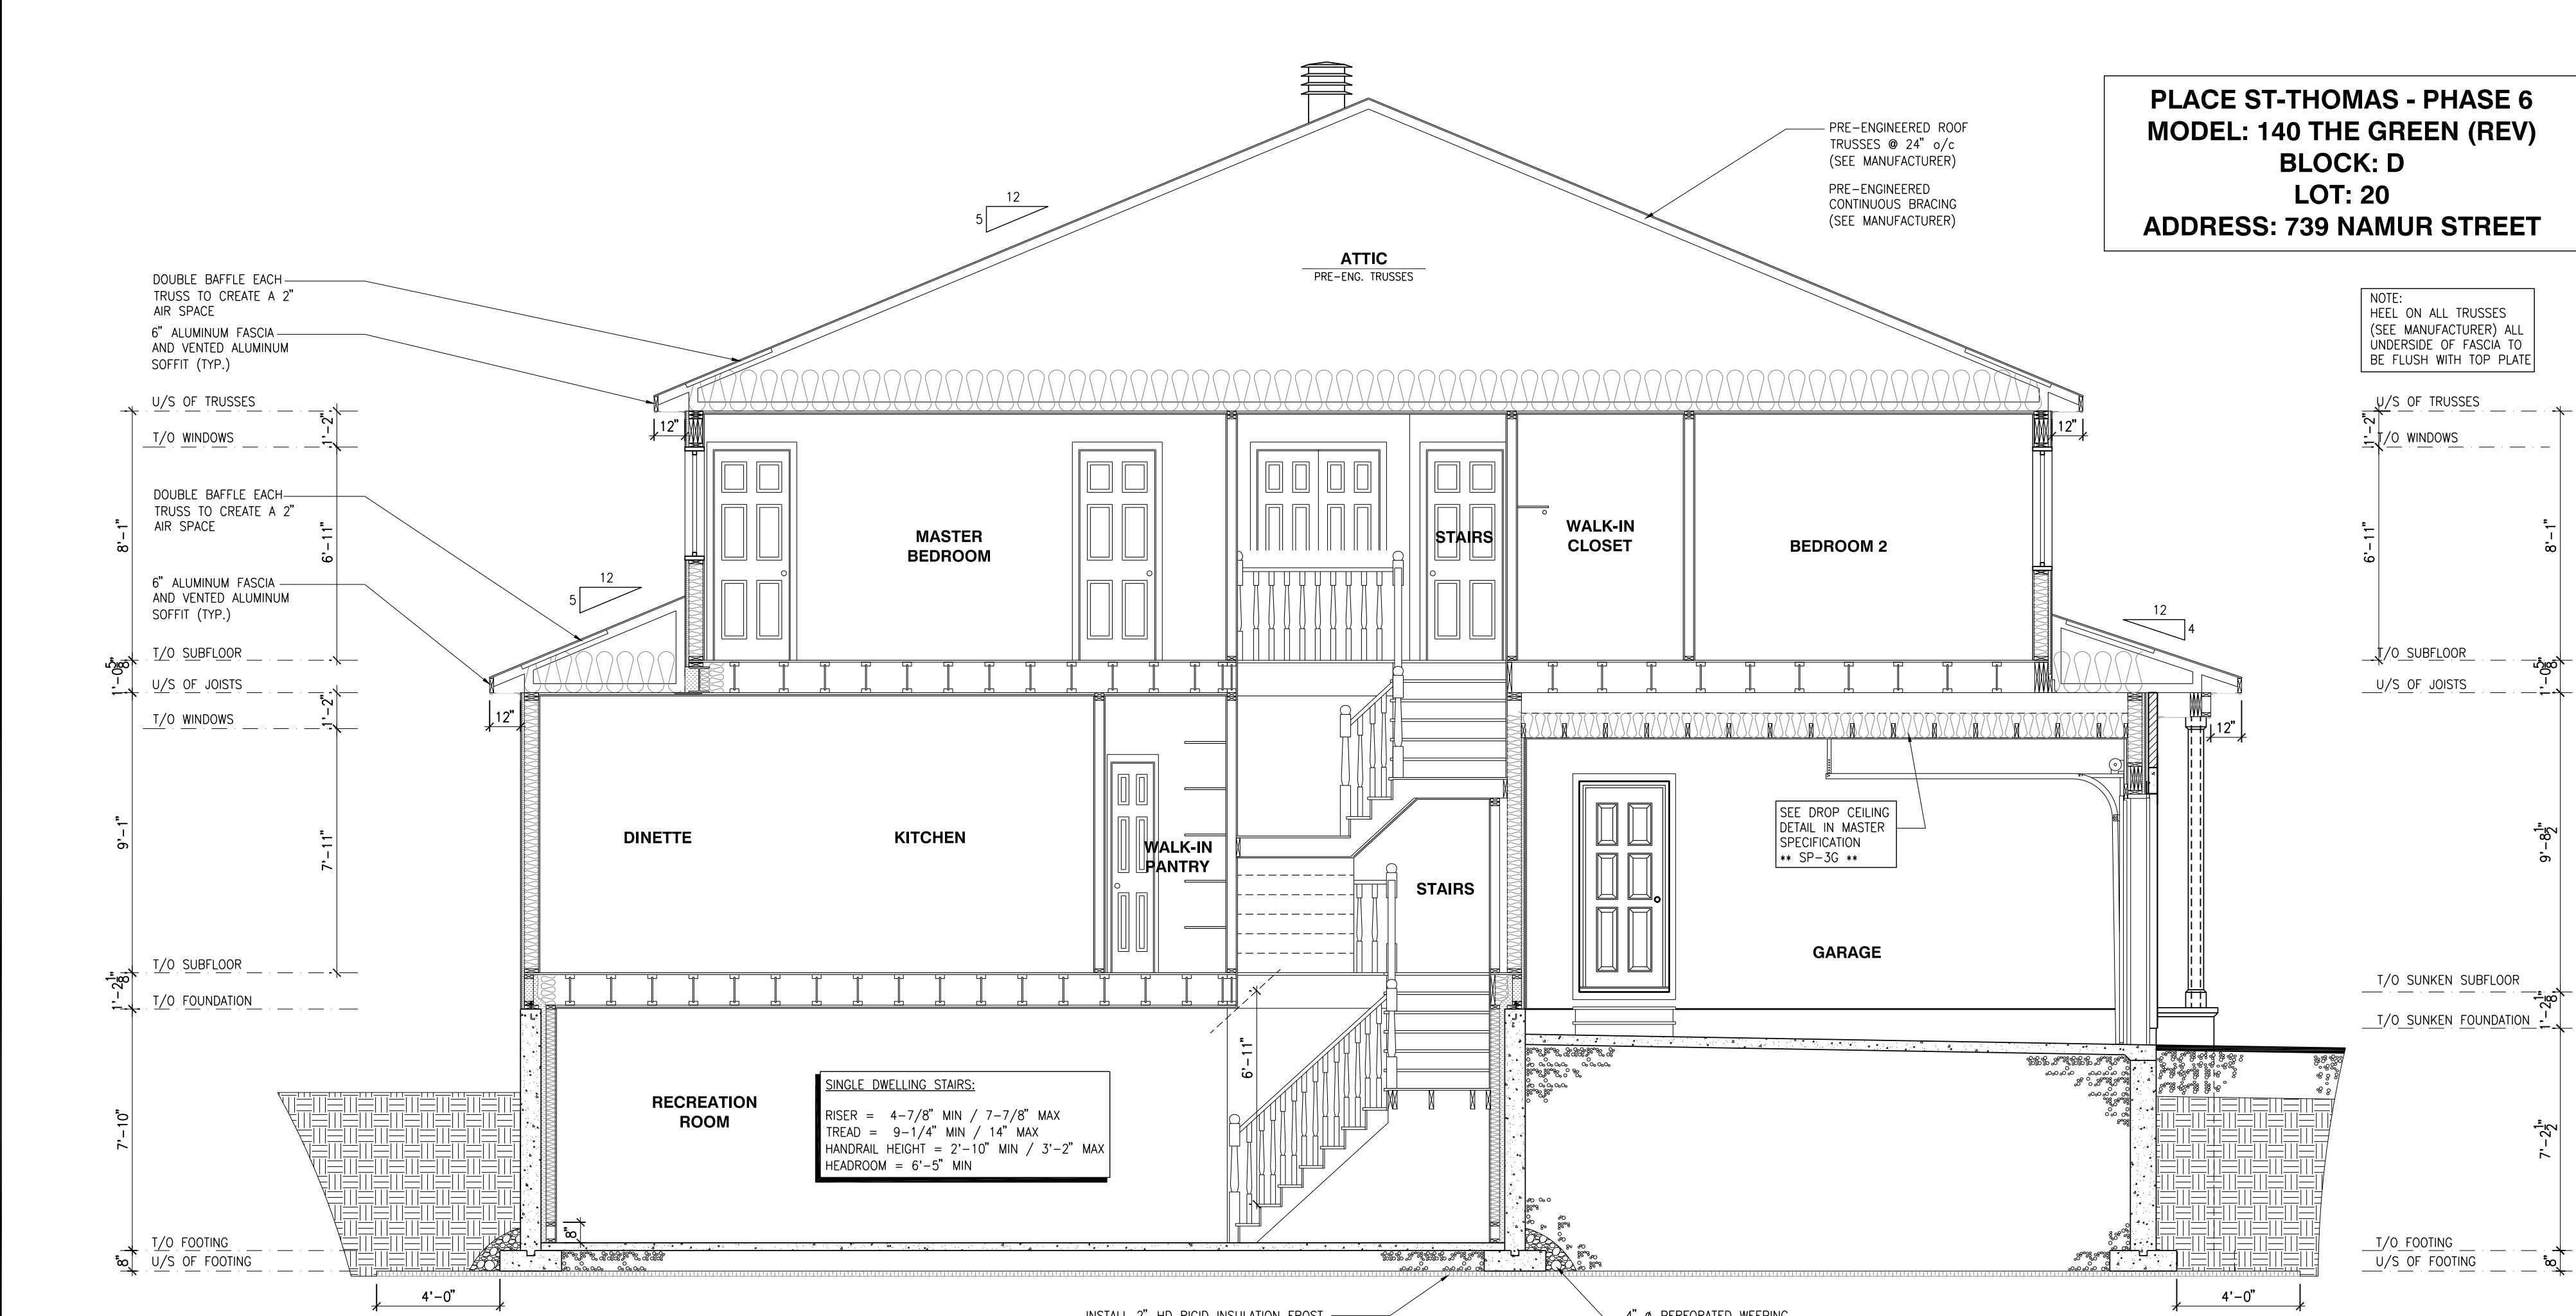

BUILDING SECTION - THE GREEN (REV) MODEL 140
SCALE: 1/4" = 1'-0"

PLACE ST-THOMAS - PHASE 6
MODEL: 140 THE GREEN (REV)
BLOCK: D
LOT: 20
ADDRESS: 739 NAMUR STREET





2012 O.B.C. DRAWINGS

REV-2 ISSUED FOR CONSTRUCTION 06/19/2021 DOYON
REV-1 ISSUED FOR TRUSSES AND JOISTS 07/29/2021 DOYON
NO. 1 DESCRIPTION 1MM/00/YYY1BY

REAR ELEVATION AND
BUILDING SECTIONS

ADDRESS: SEE PLANS SCALE: 1/4" = 1'-0" DATE: MM/DD/YYYY 05/10/2021
BLOCK: D
PLACE ST-THOMAS
PHASE 6

A.2

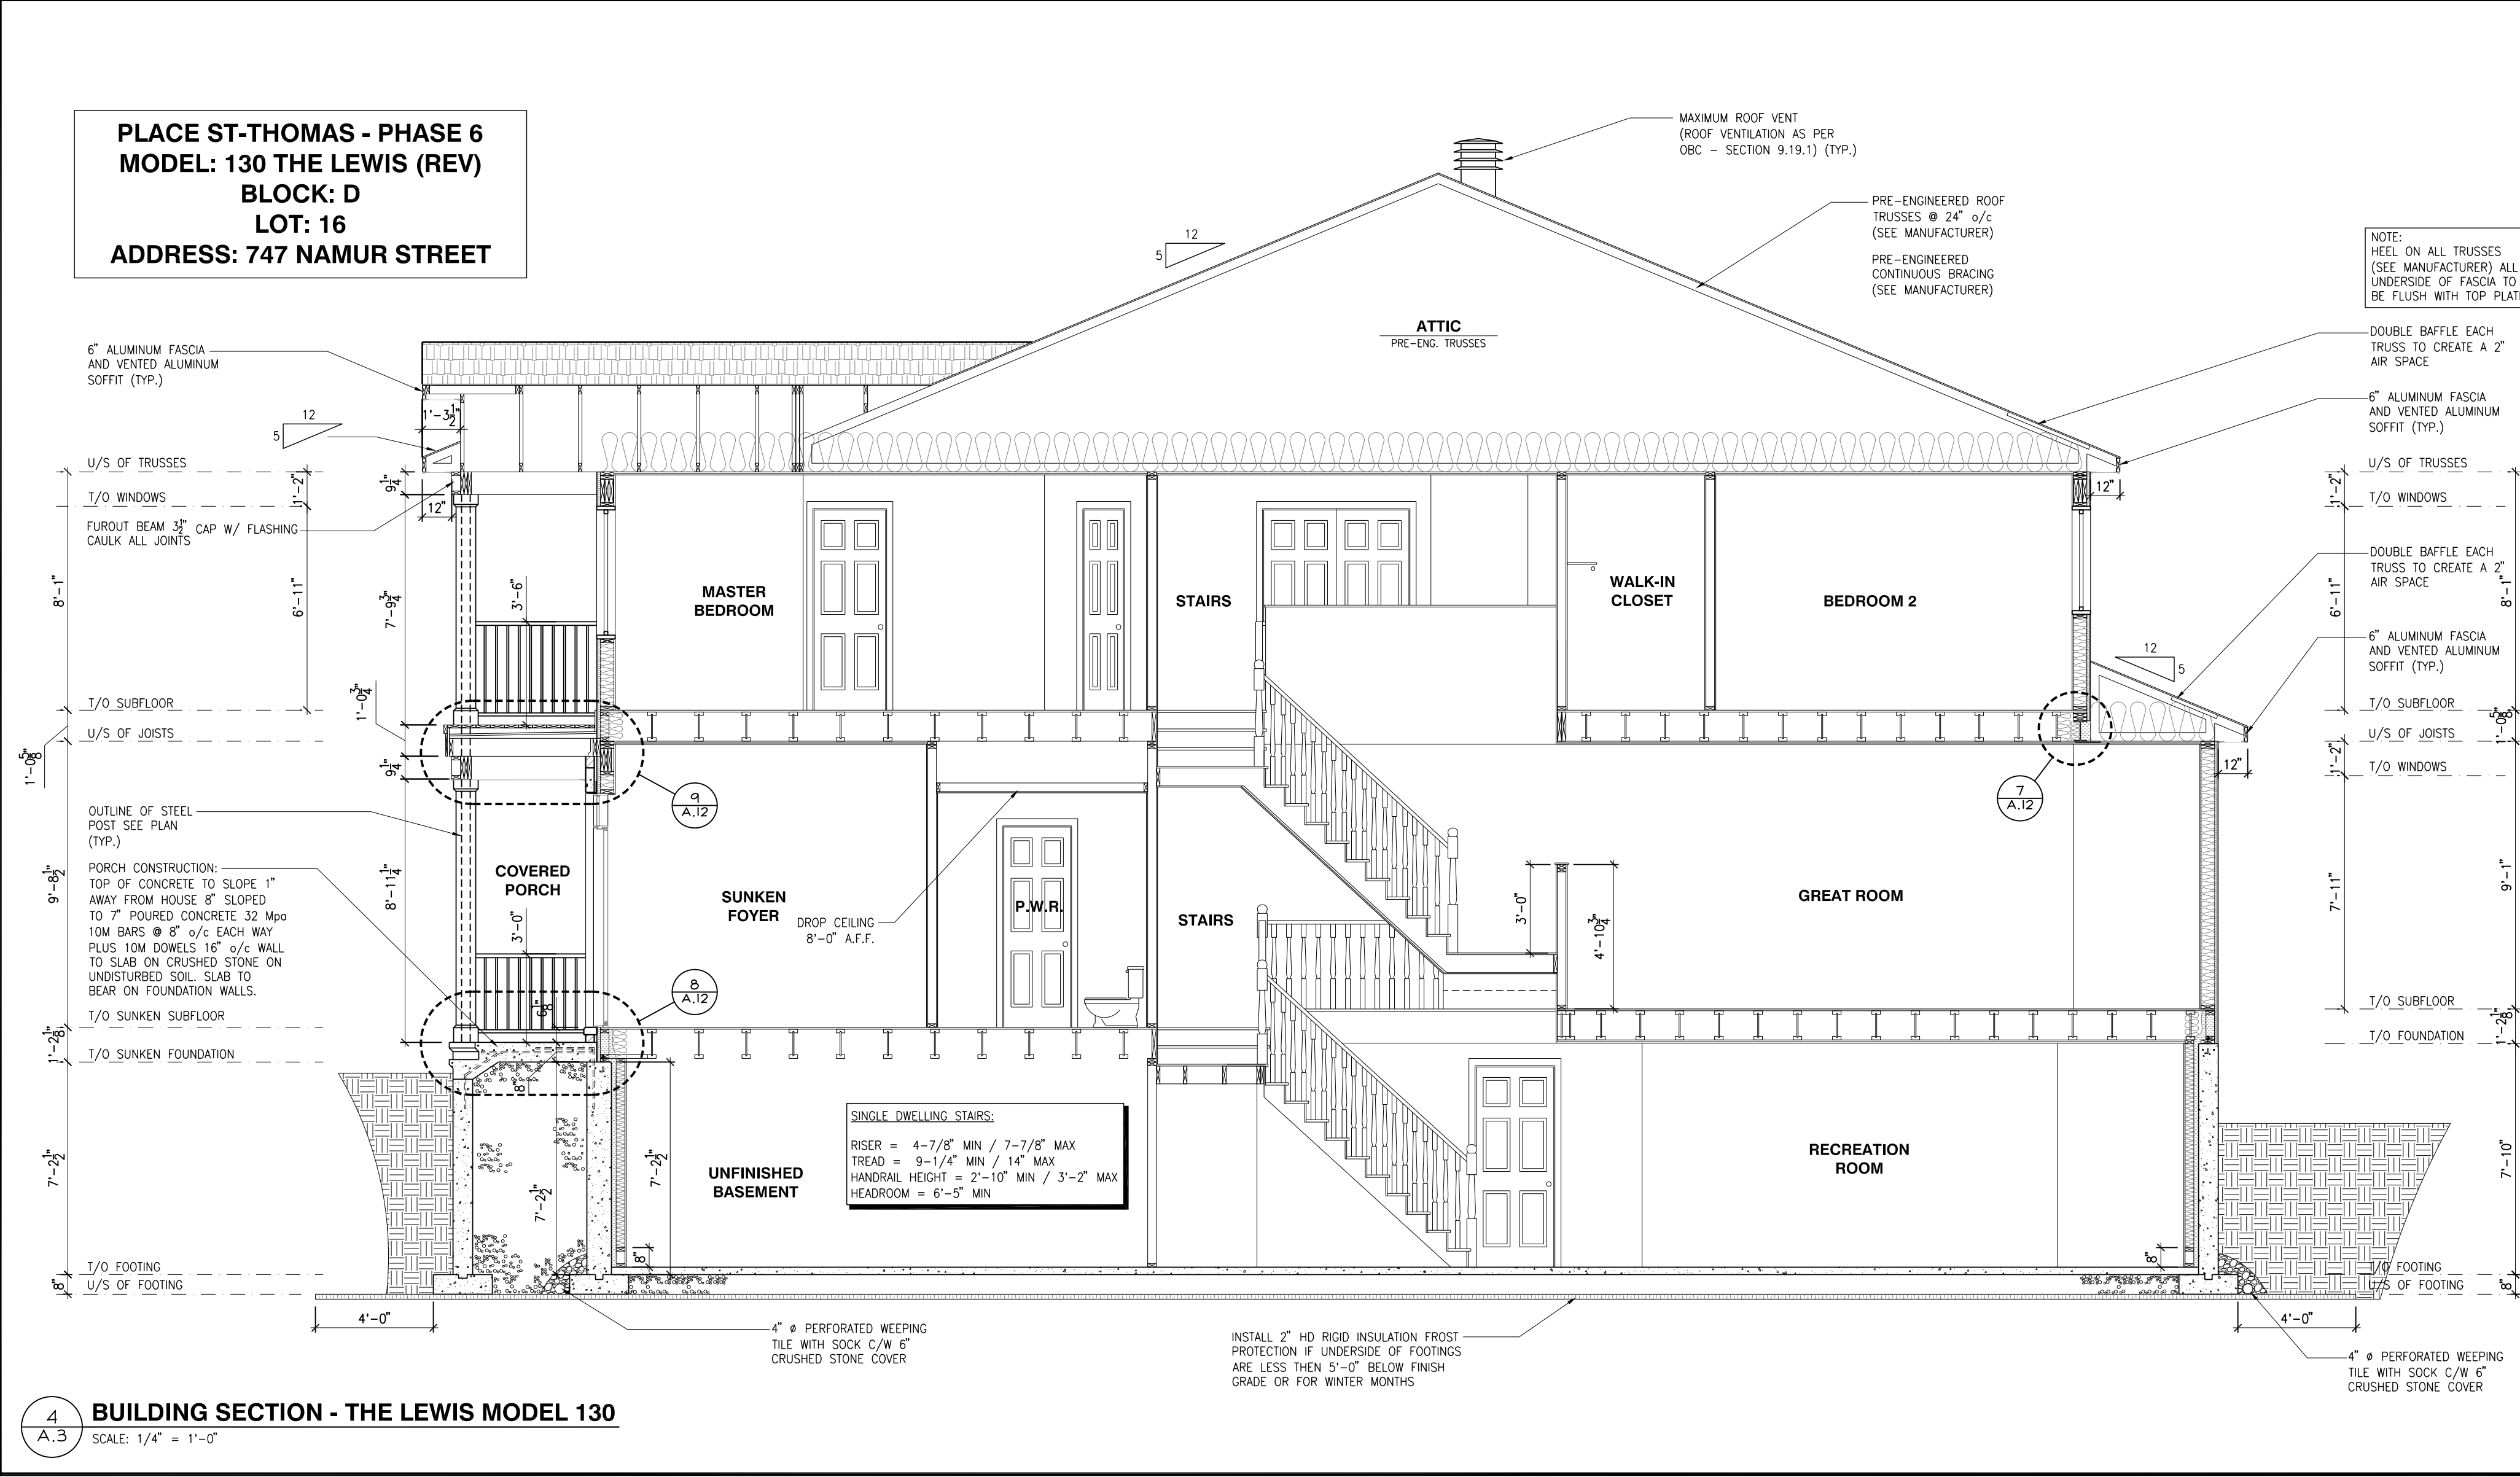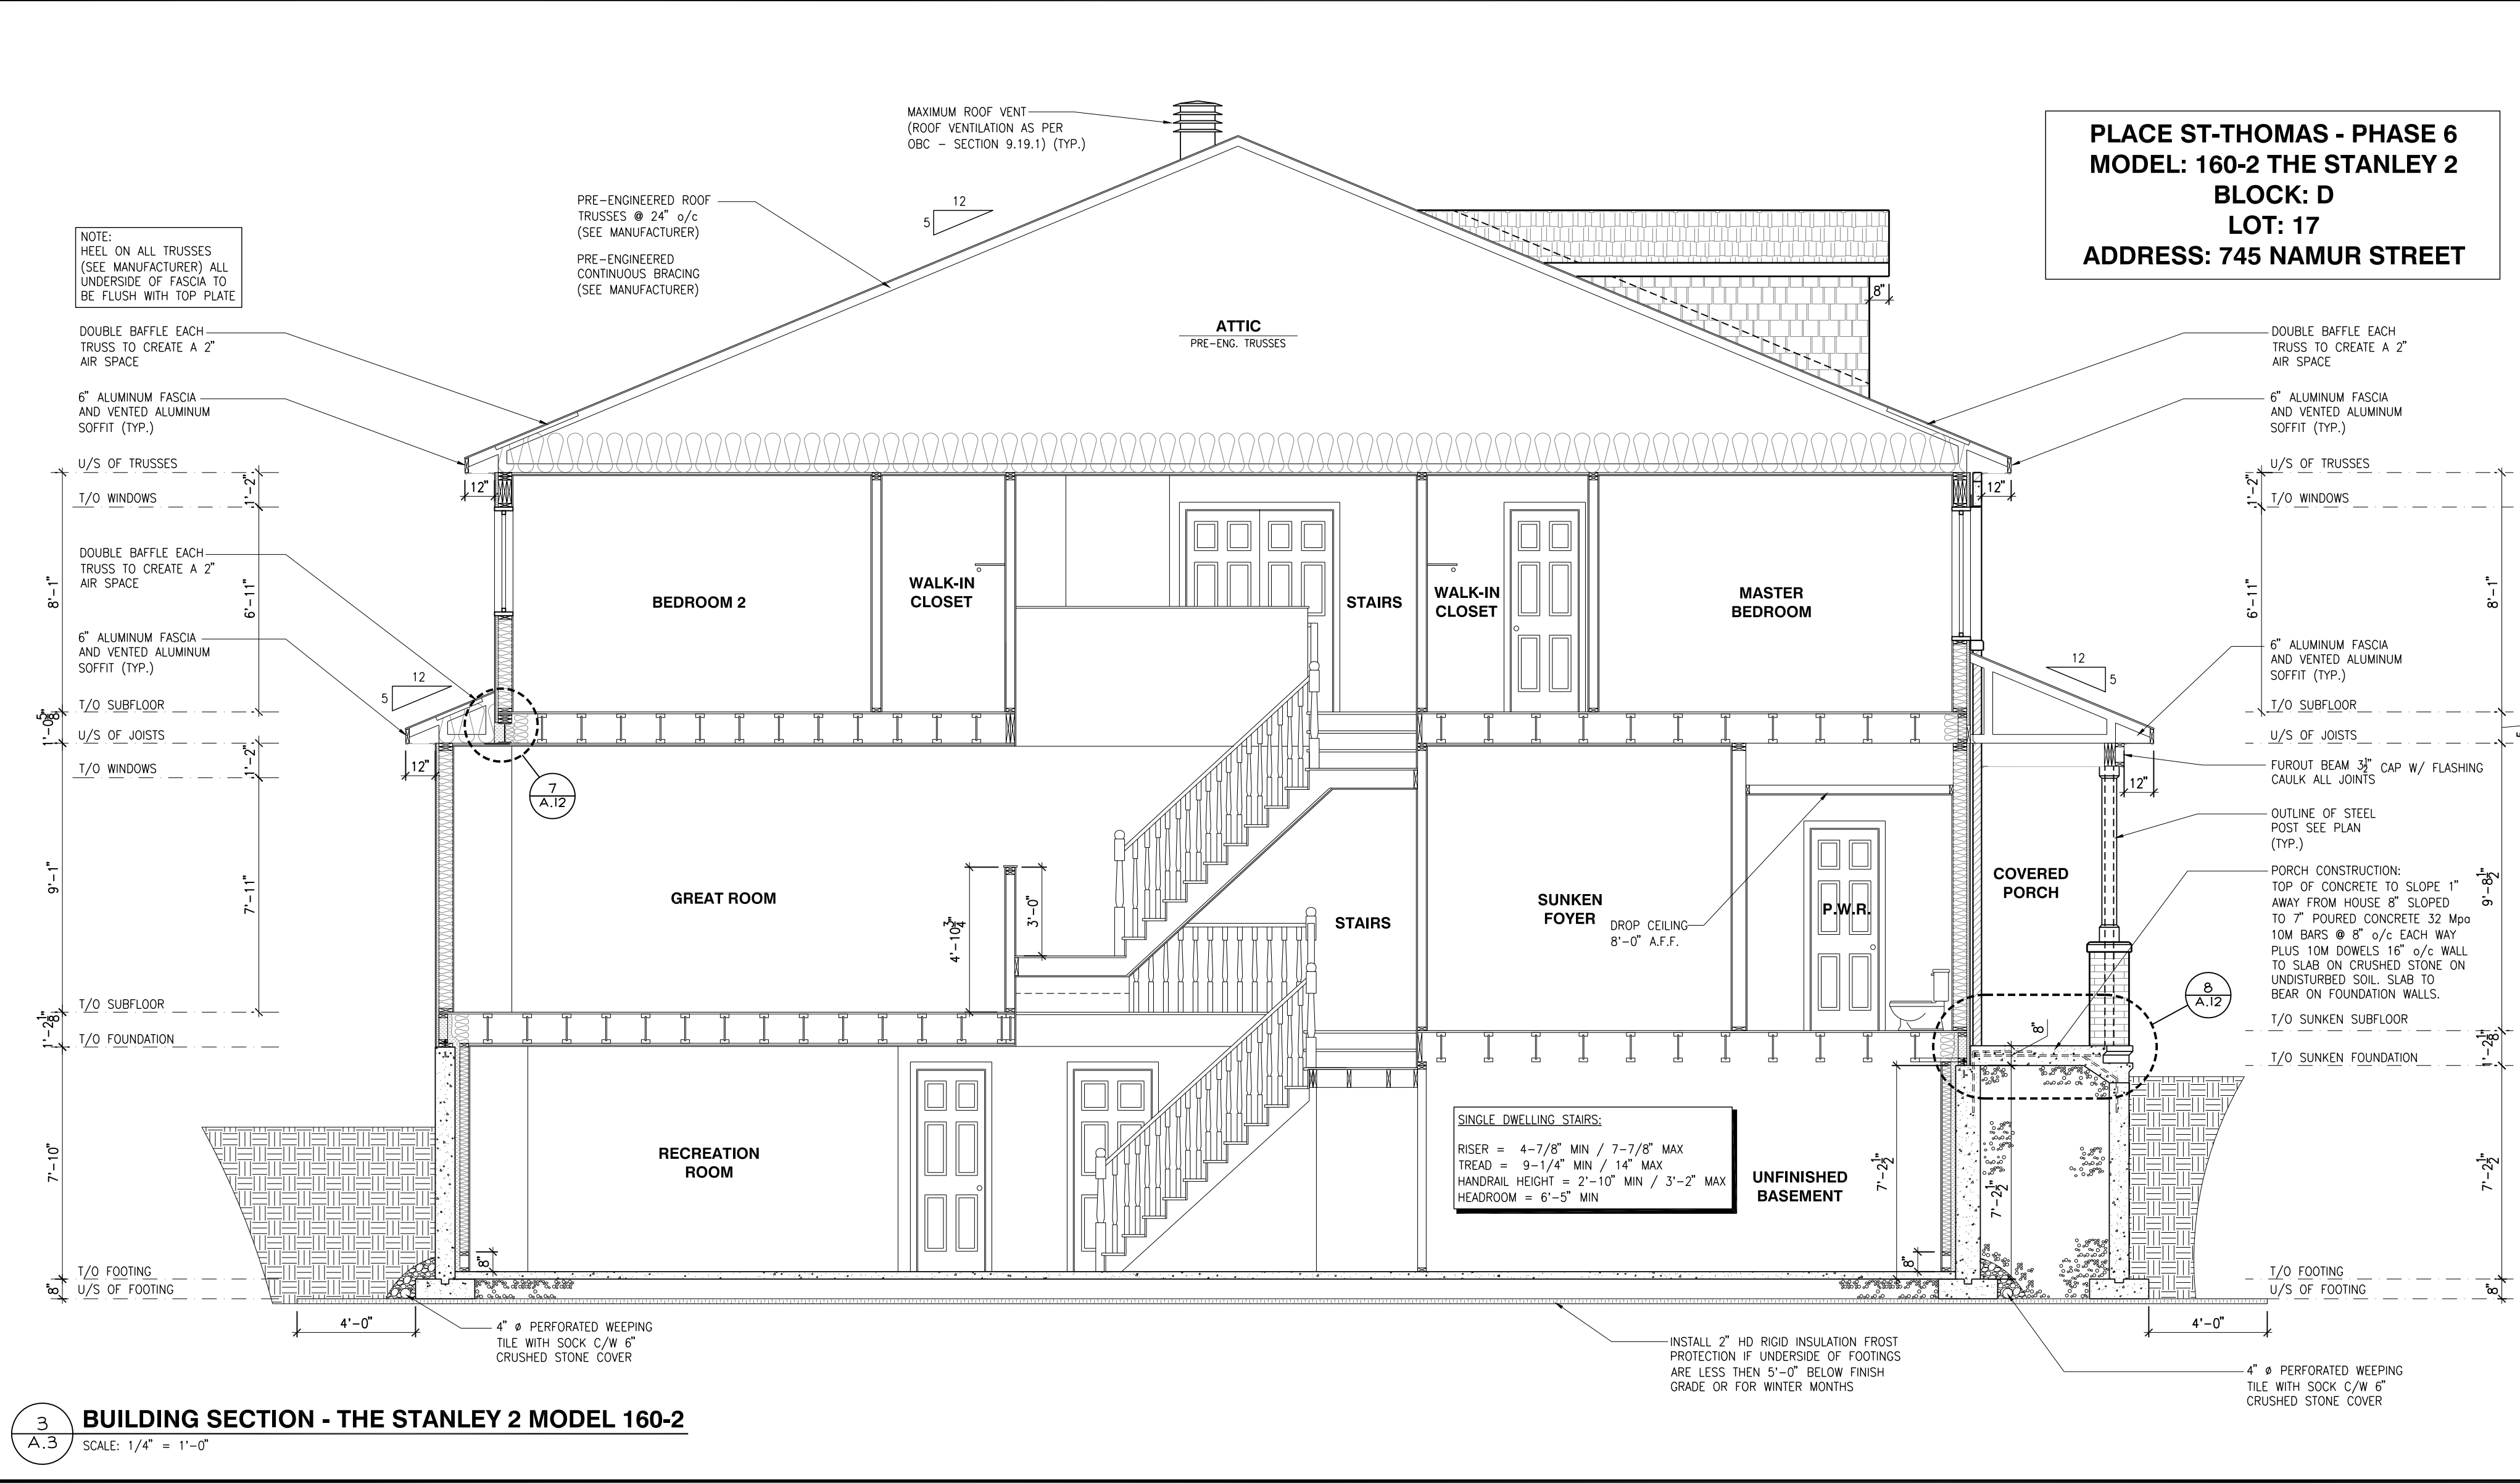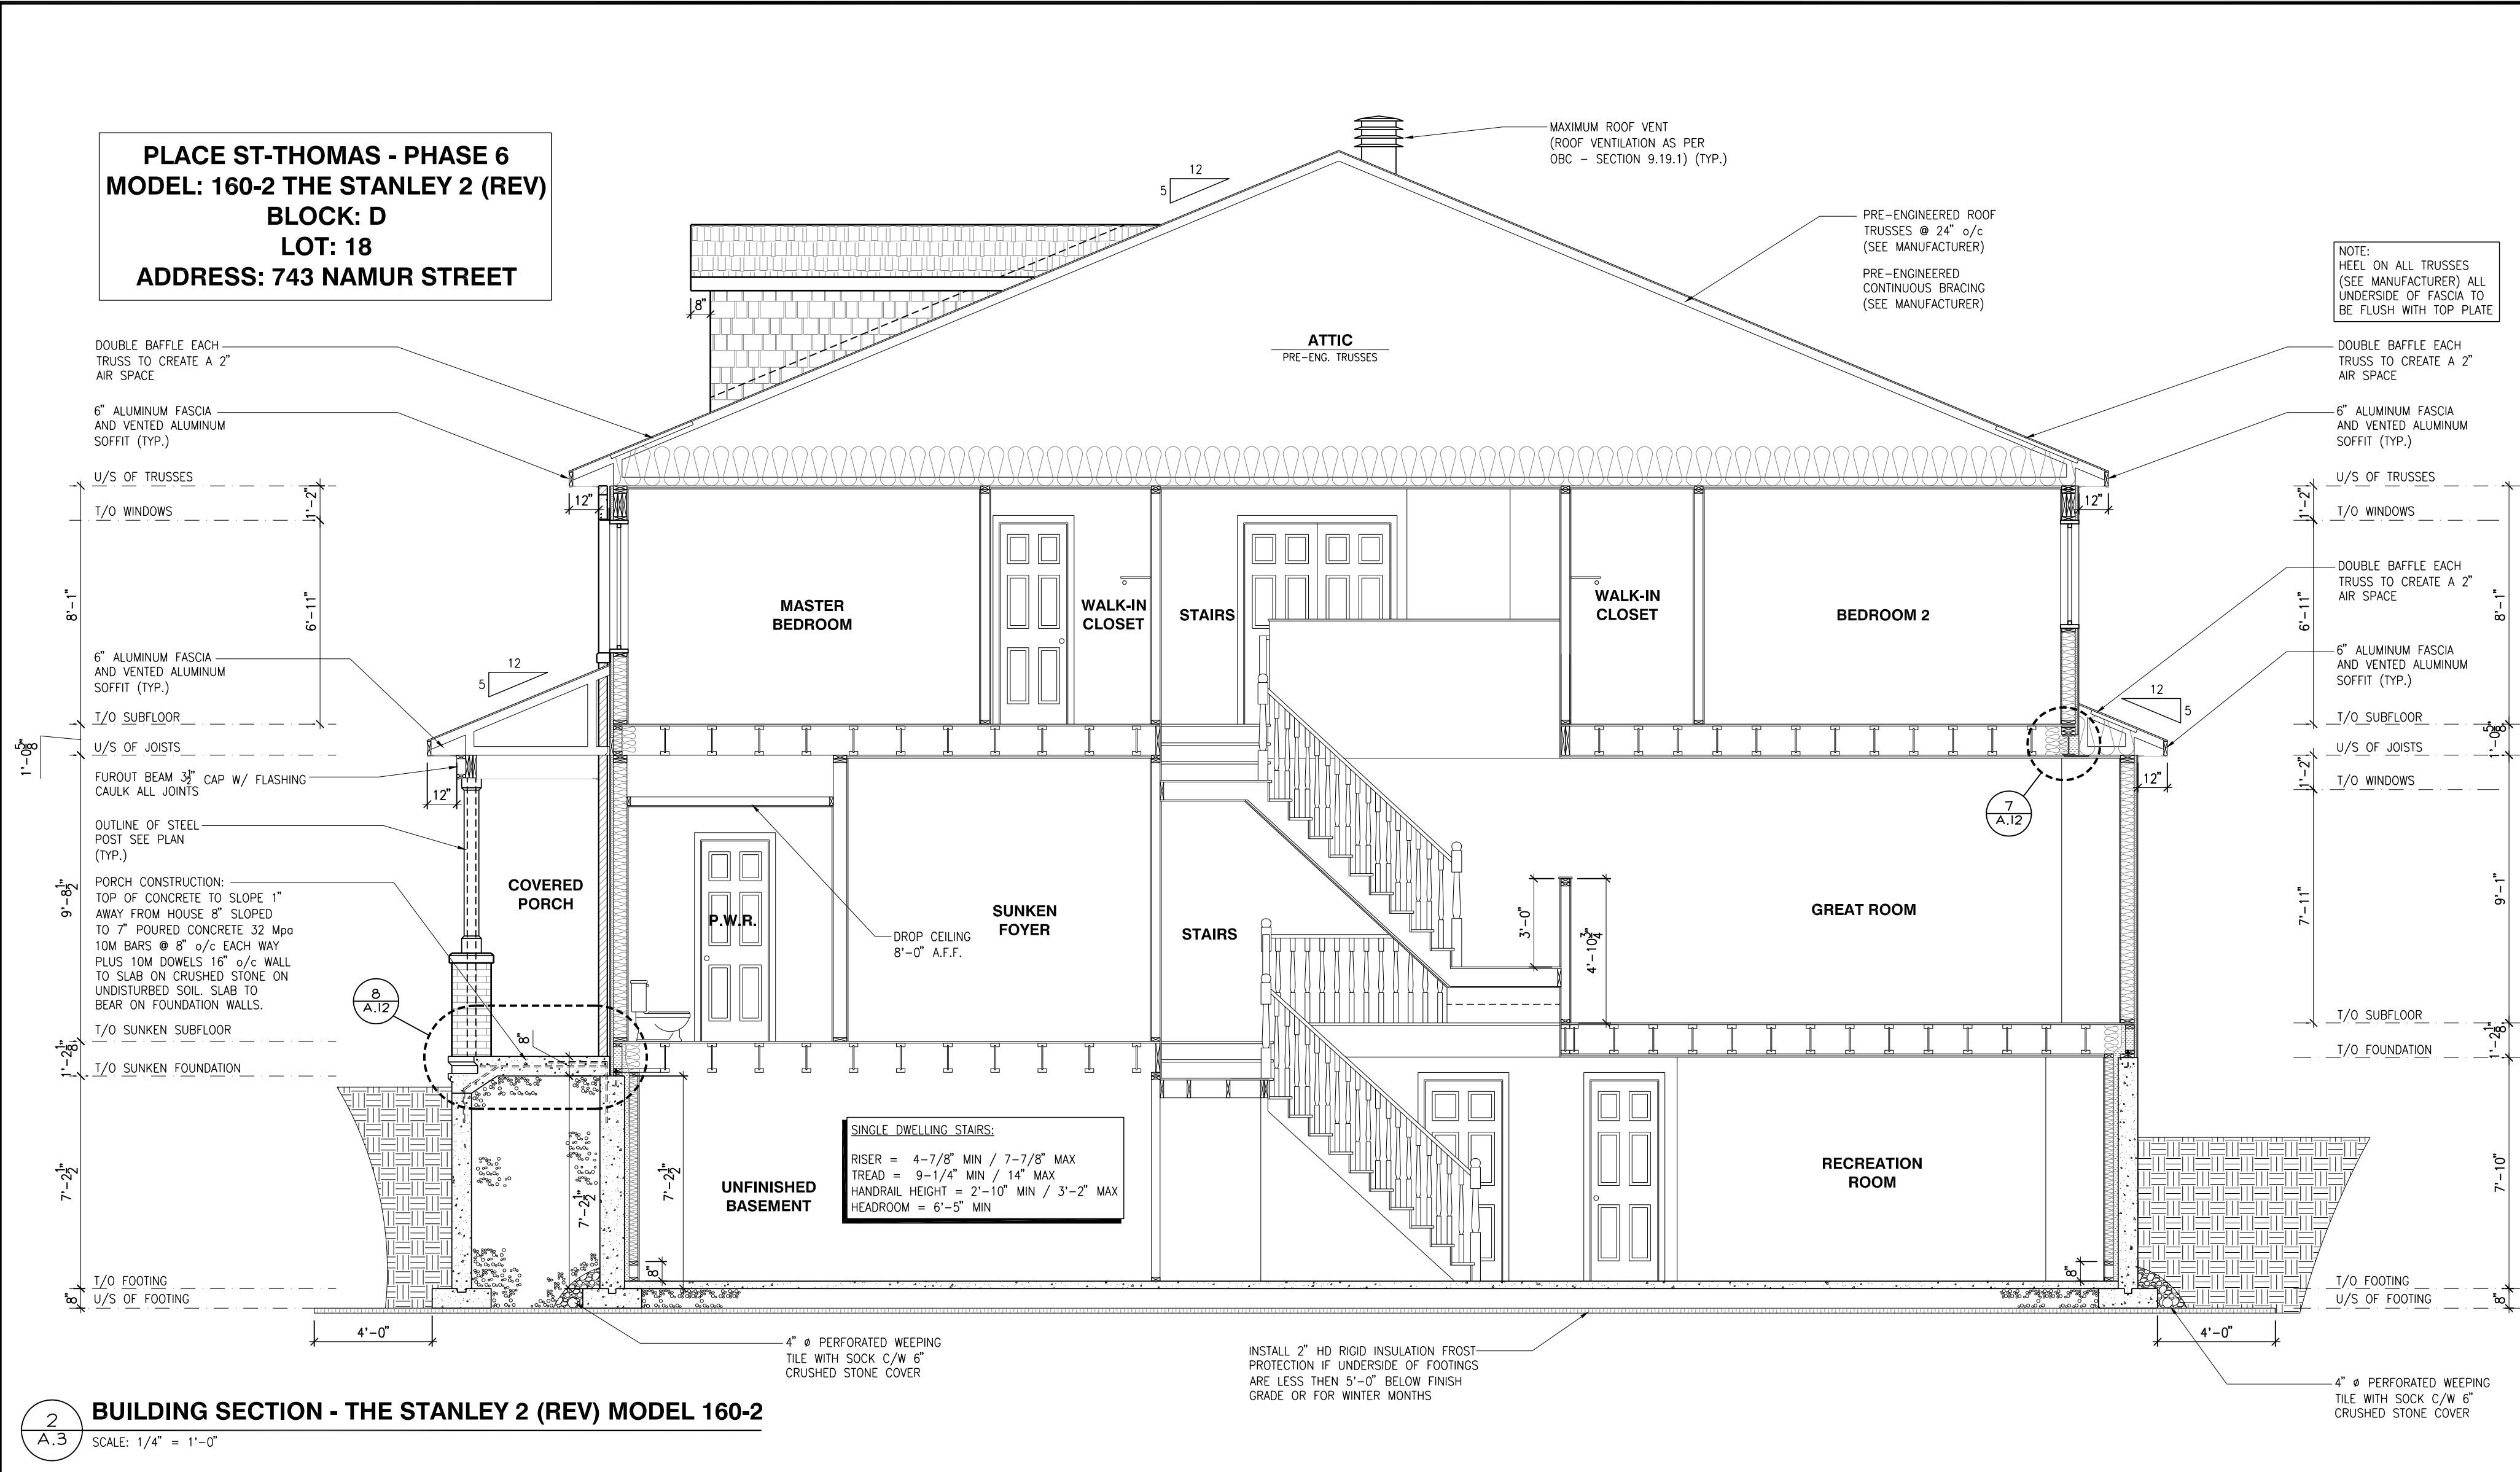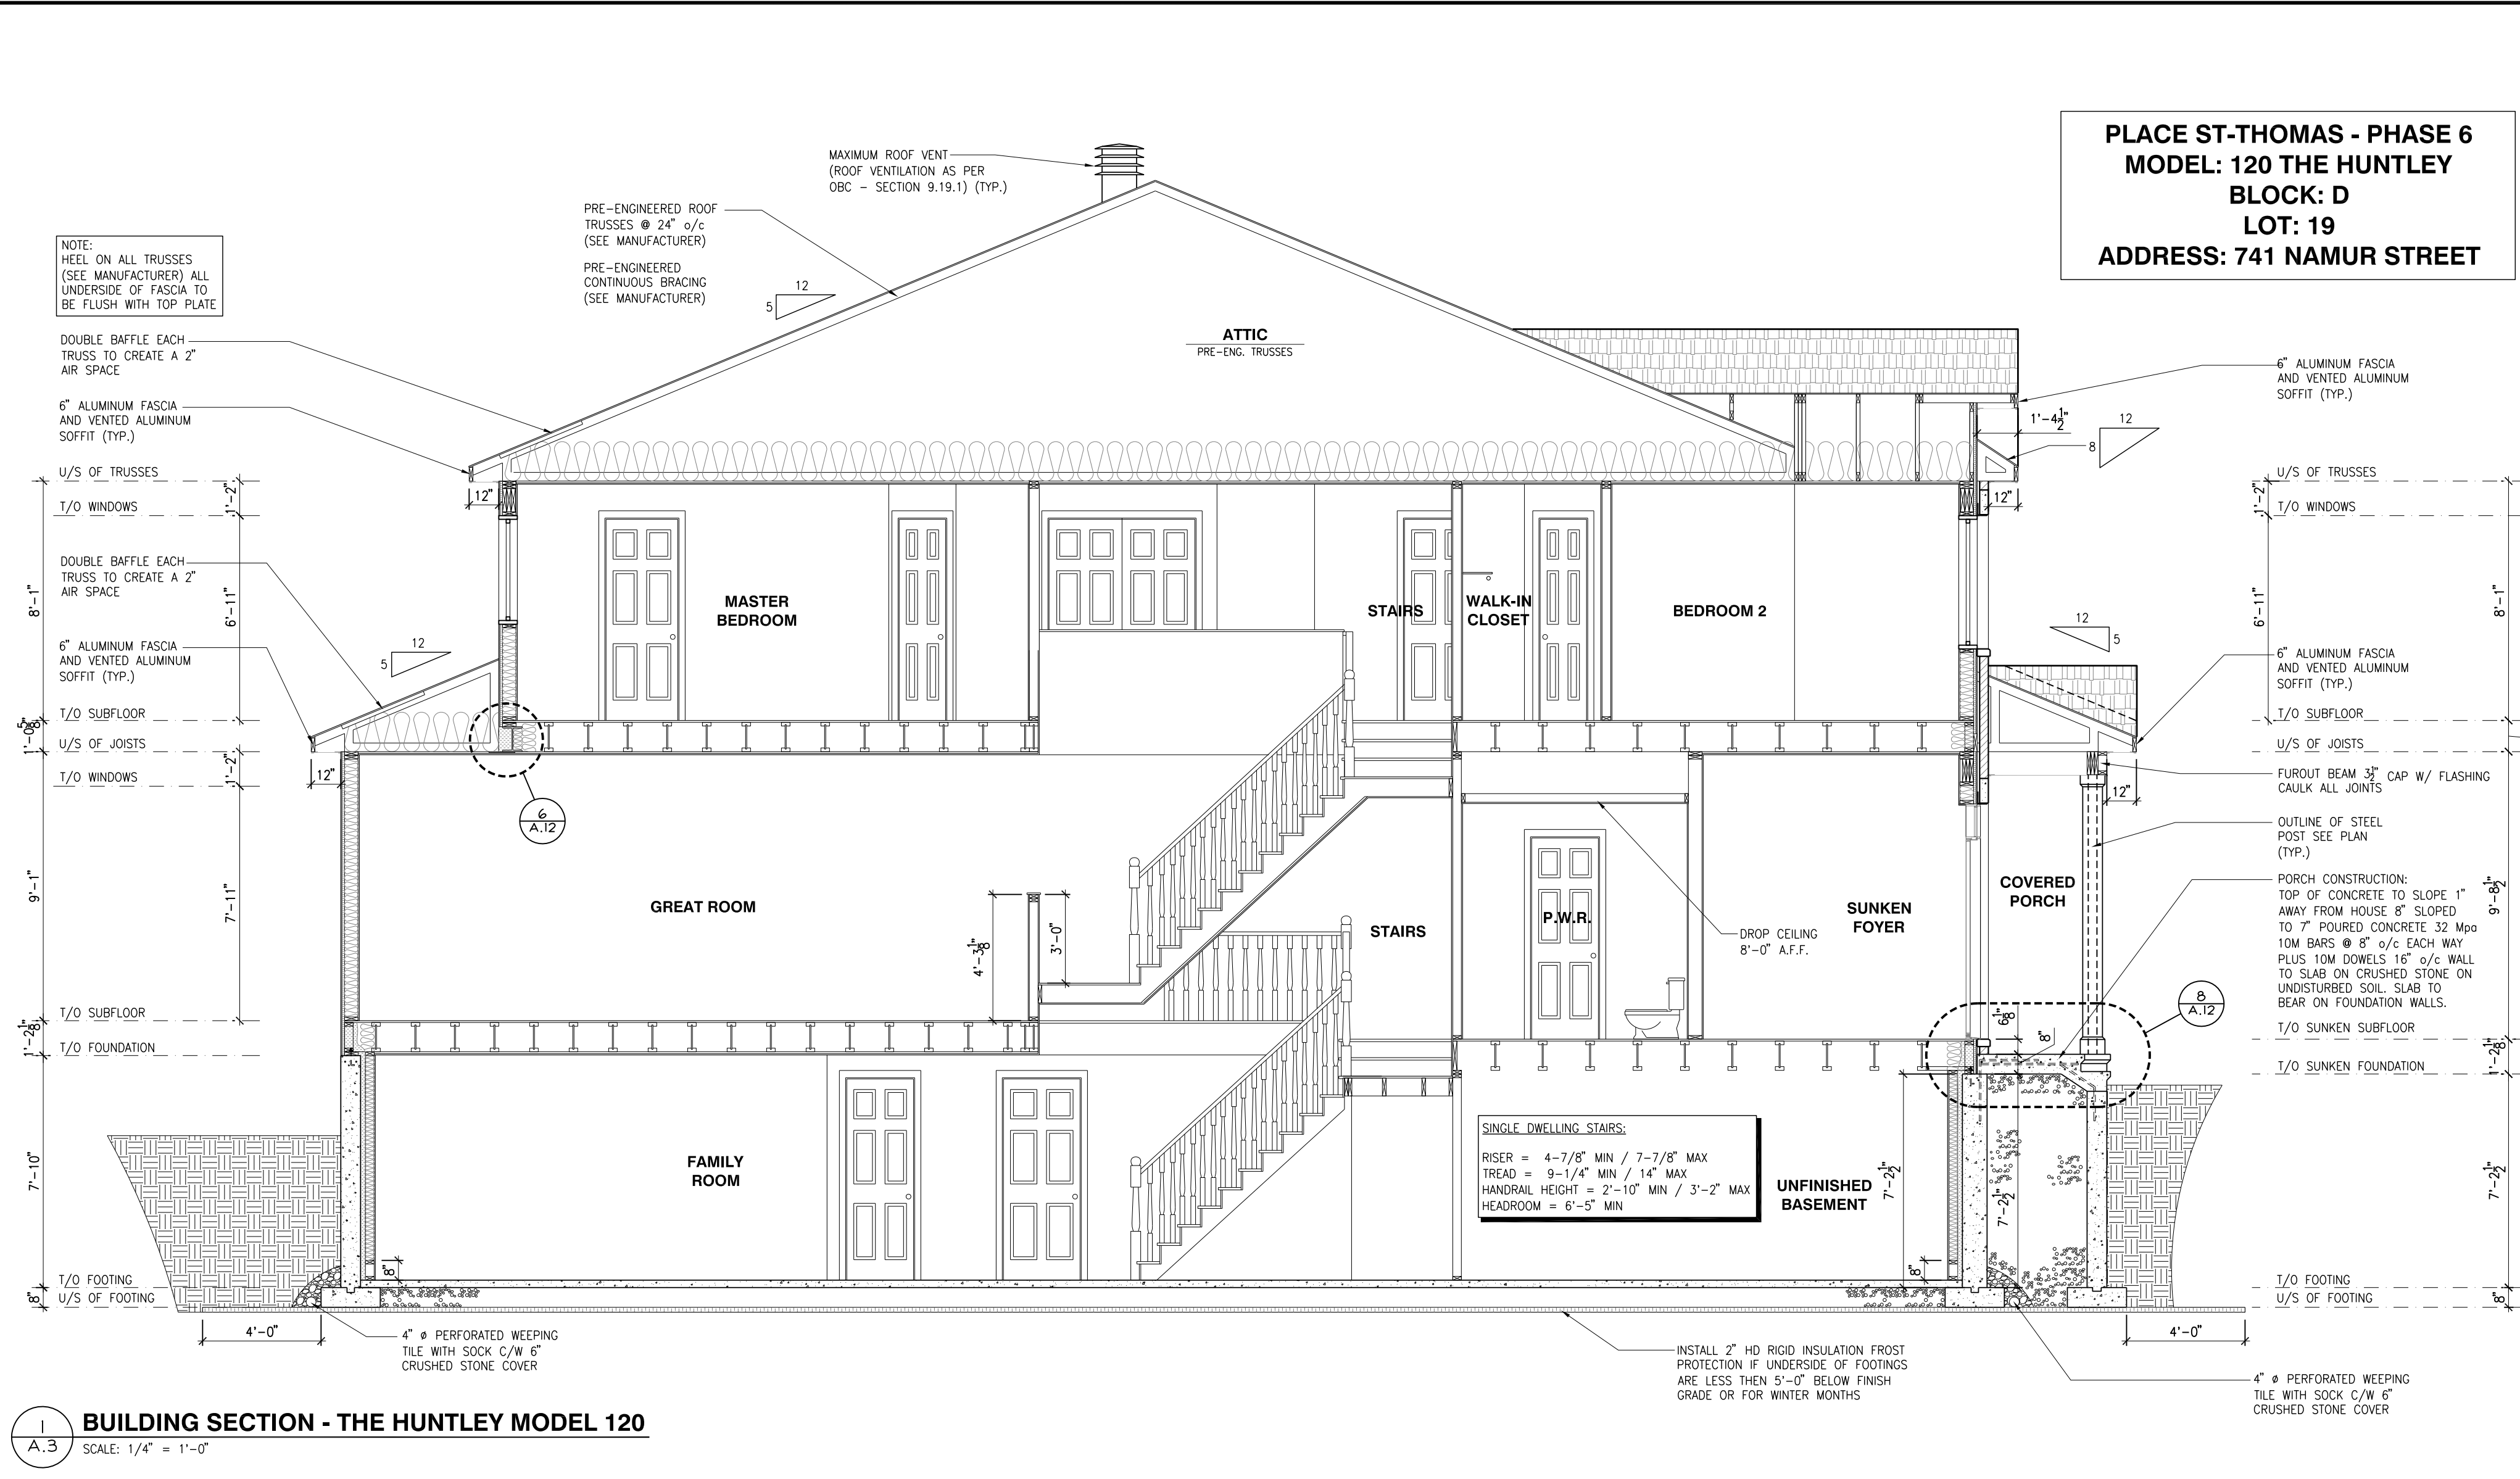

PLACE ST-THOMAS - PHASE 6
MODEL: 110 THE THOMAS
BLOCK: D
LOT: 21
ADDRESS: 737 NAMUR STREET


PLACE ST-THOMAS - PHASE 6
MODEL: 140 THE GREEN (REV)
BLOCK: D
LOT: 20
ADDRESS: 739 NAMUR STREET

PLACE ST-THOMAS - PHASE 6
MODEL: 120 THE HUNTLEY
BLOCK: D
LOT: 19
ADDRESS: 741 NAMUR STREET

PLACE ST-THOMAS - PHASE 6
MODEL: 160-2 THE STANLEY 2 (REV)
BLOCK: D
LOT: 18
ADDRESS: 743 NAMUR STREET

PLACE ST-THOMAS - PHASE 6
MODEL: 160-2 THE STANLEY 2
BLOCK: D
LOT: 17
ADDRESS: 745 NAMUR STREET

PLACE ST-THOMAS - PHASE 6
MODEL: 130 THE LEWIS (REV)
BLOCK: D
LOT: 16
ADDRESS: 747 NAMUR STREET

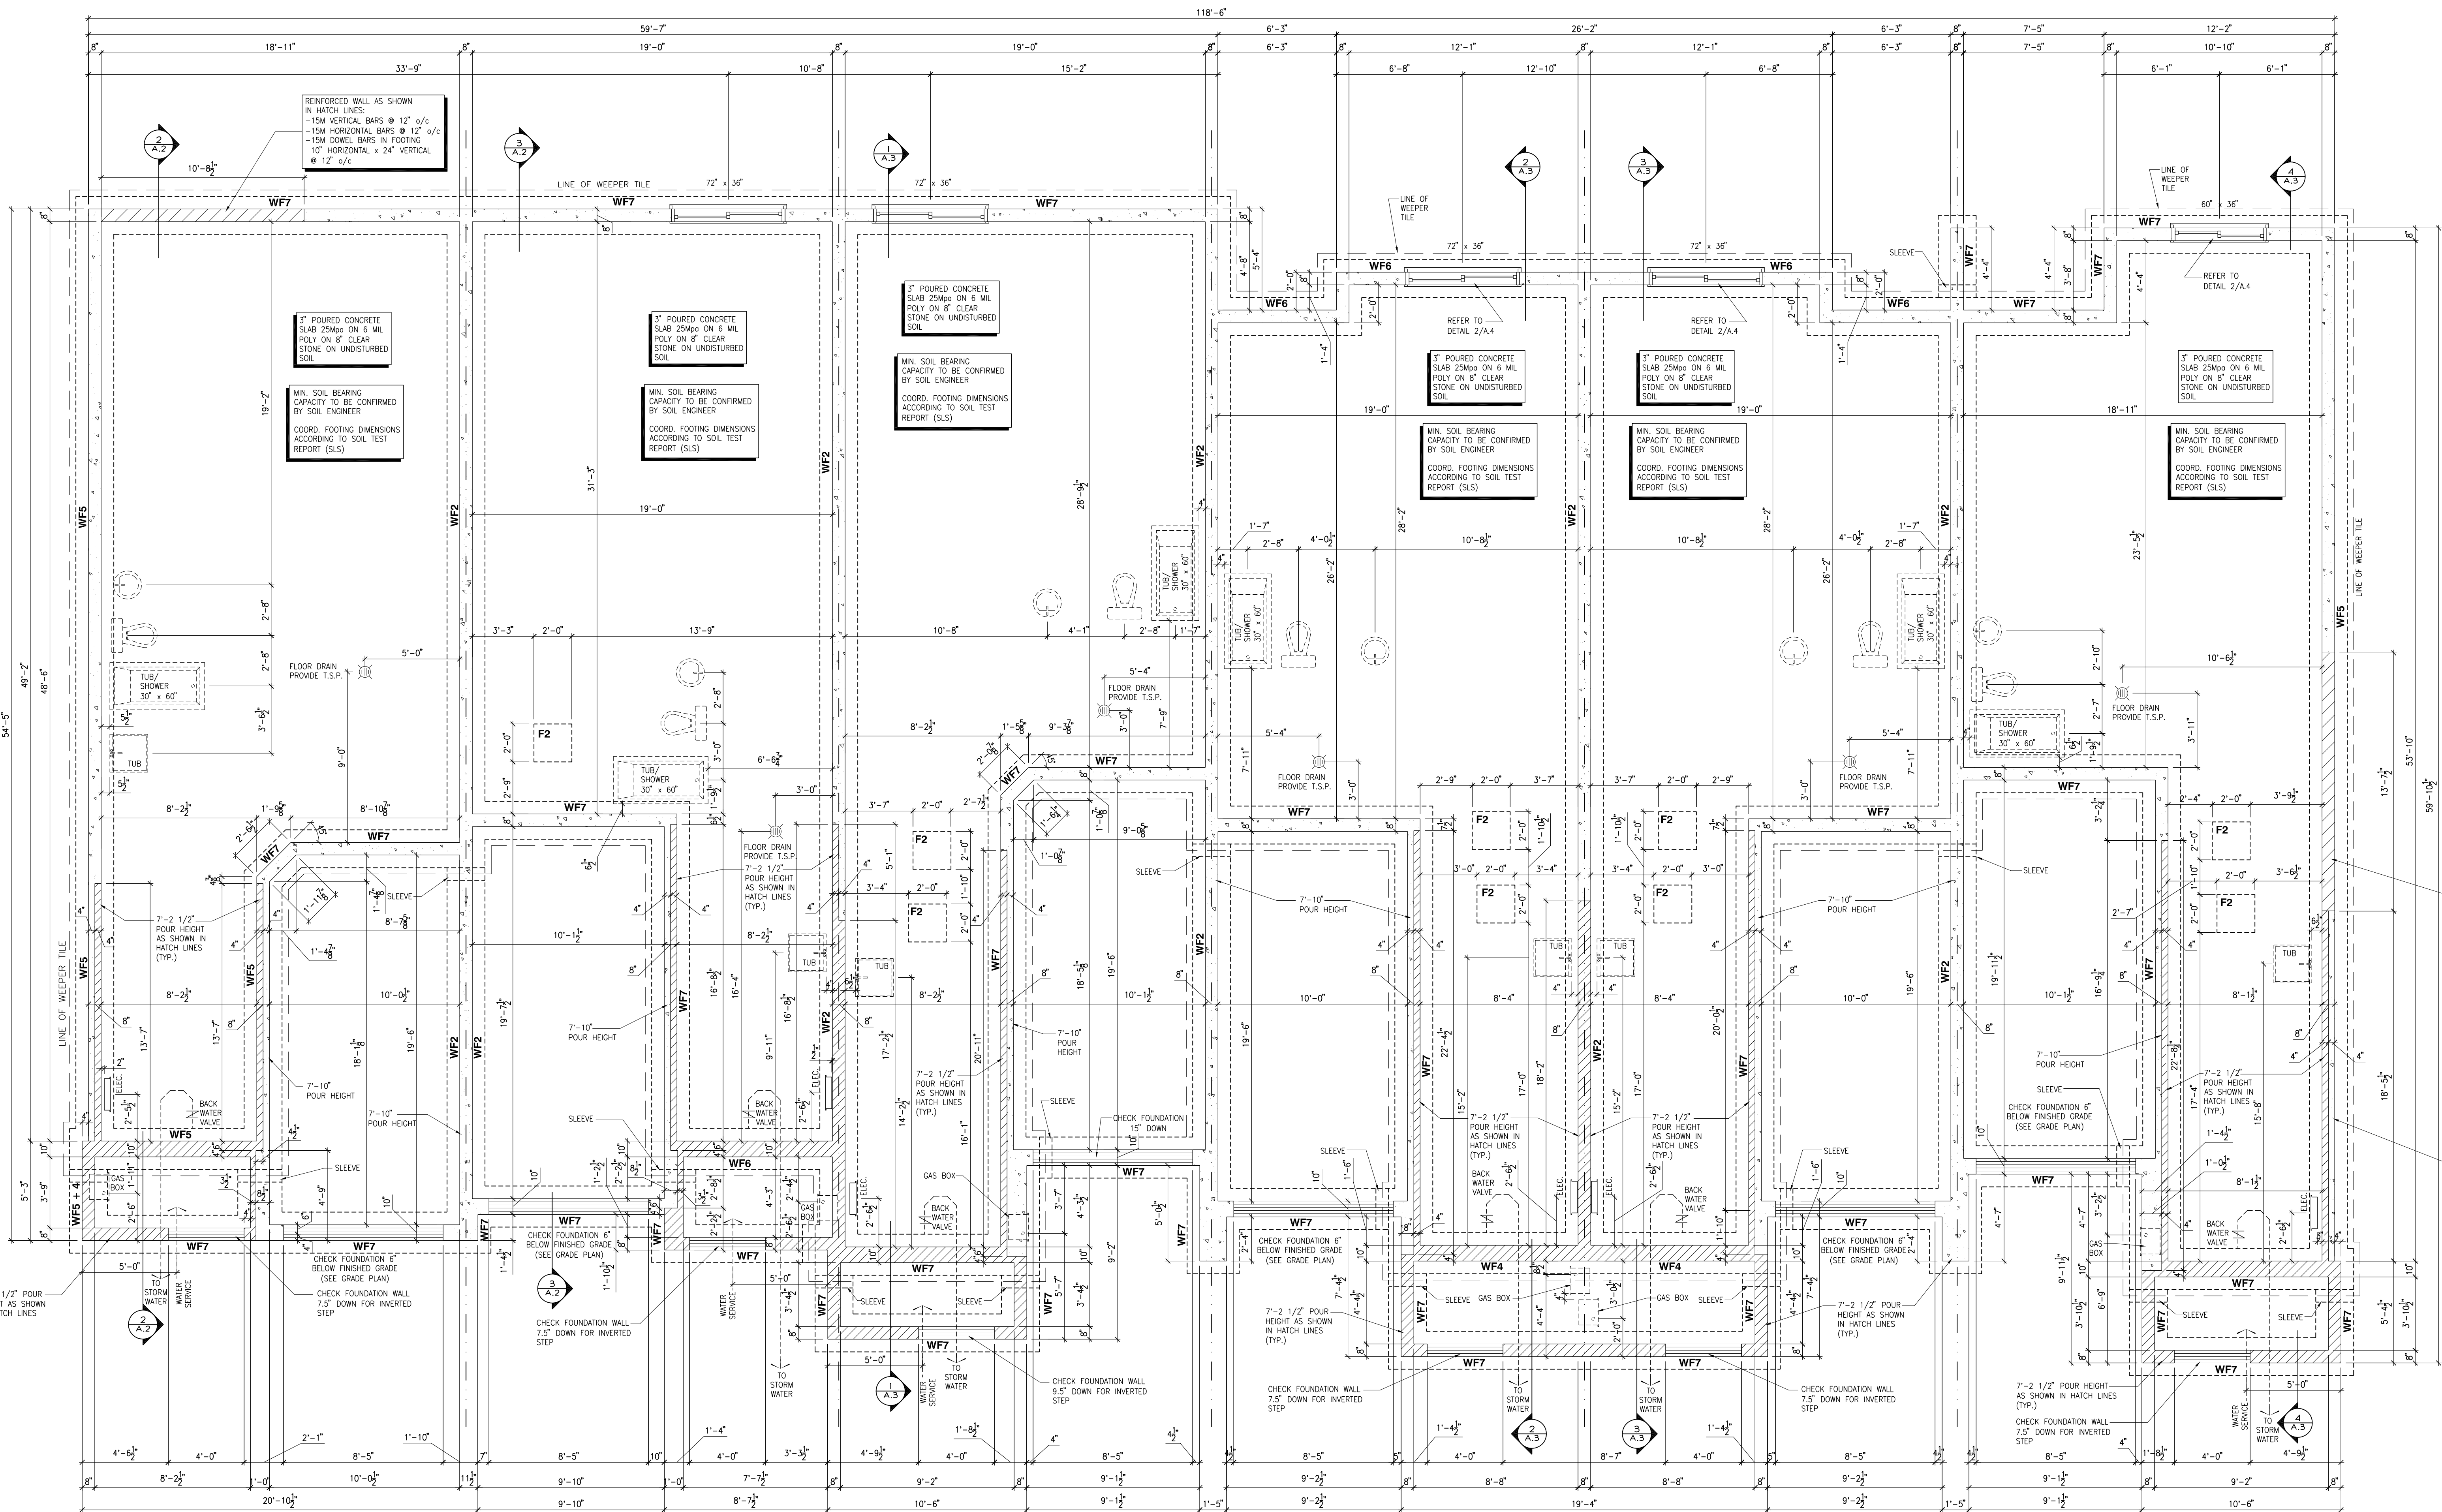


FOOTING SCHEDULE					
ALLOWABLE SOIL BEARING CAPACITY / BEARING RESISTANCE AT SLS FOR <SITE CLASS>					
WALL FOOTINGS	100KPa	85KPa	75KPa	60KPa	40KPa
WF1	30"W x 8'H 2-15M LONGITUDINAL BARS	36"W x 8'H 15M TRANSVERSE BOTTOM BARS 36" LONG @ 20" o/c 3-15M LONGITUDINAL BARS	40"W x 8'H 15M TRANSVERSE BOTTOM BARS 36" LONG @ 20" o/c 3-15M LONGITUDINAL BARS	48"W x 8'H 15M TRANSVERSE BOTTOM BARS 42" LONG @ 16" o/c 3-15M LONGITUDINAL BARS	72"W x 8'H 15M TRANSVERSE BOTTOM BARS 60" LONG @ 16" o/c 5-15M LONGITUDINAL BARS
WF2	28"W x 8'H 2-15M LONGITUDINAL BARS	34"W x 8'H 15M TRANSVERSE BOTTOM BARS 34" LONG @ 20" o/c 3-15M LONGITUDINAL BARS	38"W x 8'H 15M TRANSVERSE BOTTOM BARS 34" LONG @ 20" o/c 3-15M LONGITUDINAL BARS	46"W x 8'H 15M TRANSVERSE BOTTOM BARS 42" LONG @ 16" o/c 3-15M LONGITUDINAL BARS	70"W x 8'H 15M TRANSVERSE BOTTOM BARS 64" LONG @ 16" o/c 4-15M LONGITUDINAL BARS
WF3	26"W x 8'H 2-15M LONGITUDINAL BARS	30"W x 8'H 15M TRANSVERSE BOTTOM BARS 30" LONG @ 20" o/c 3-15M LONGITUDINAL BARS	34"W x 8'H 15M TRANSVERSE BOTTOM BARS 30" LONG @ 20" o/c 3-15M LONGITUDINAL BARS	42"W x 8'H 15M TRANSVERSE BOTTOM BARS 38" LONG @ 20" o/c 3-15M LONGITUDINAL BARS	64"W x 8'H 15M TRANSVERSE BOTTOM BARS 60" LONG @ 16" o/c 4-15M LONGITUDINAL BARS
WF4	24"W x 8'H 2-15M LONGITUDINAL BARS	28"W x 8'H 15M TRANSVERSE BOTTOM BARS 28" LONG @ 20" o/c 3-15M LONGITUDINAL BARS	32"W x 8'H 15M TRANSVERSE BOTTOM BARS 28" LONG @ 20" o/c 3-15M LONGITUDINAL BARS	38"W x 8'H 15M TRANSVERSE BOTTOM BARS 34" LONG @ 20" o/c 3-15M LONGITUDINAL BARS	58"W x 8'H 15M TRANSVERSE BOTTOM BARS 54" LONG @ 16" o/c 4-15M LONGITUDINAL BARS
WF5	24"W x 8'H 2-15M LONGITUDINAL BARS	24"W x 8'H 15M TRANSVERSE BOTTOM BARS 24" LONG @ 20" o/c 3-15M LONGITUDINAL BARS	26"W x 8'H 15M TRANSVERSE BOTTOM BARS 24" LONG @ 20" o/c 3-15M LONGITUDINAL BARS	34"W x 8'H 15M TRANSVERSE BOTTOM BARS 34" LONG @ 16" o/c 4-15M LONGITUDINAL BARS	58"W x 8'H 15M TRANSVERSE BOTTOM BARS 48" LONG @ 16" o/c 4-15M LONGITUDINAL BARS
WF6	24"W x 8'H 2-15M LONGITUDINAL BARS	24"W x 8'H 15M TRANSVERSE BOTTOM BARS 24" LONG @ 20" o/c 3-15M LONGITUDINAL BARS	24"W x 8'H 15M TRANSVERSE BOTTOM BARS 24" LONG @ 20" o/c 3-15M LONGITUDINAL BARS	30"W x 8'H 15M TRANSVERSE BOTTOM BARS 42" LONG @ 16" o/c 3-15M LONGITUDINAL BARS	46"W x 8'H 15M TRANSVERSE BOTTOM BARS 48" LONG @ 16" o/c 3-15M LONGITUDINAL BARS
WF7	20"W x 8'H 2-15M LONGITUDINAL BARS	20"W x 8'H 15M TRANSVERSE BOTTOM BARS 20" LONG @ 20" o/c 3-15M LONGITUDINAL BARS	20"W x 8'H 15M TRANSVERSE BOTTOM BARS 20" LONG @ 20" o/c 3-15M LONGITUDINAL BARS	24"W x 8'H 15M TRANSVERSE BOTTOM BARS 34" LONG @ 16" o/c 3-15M LONGITUDINAL BARS	38"W x 8'H 15M TRANSVERSE BOTTOM BARS 34" LONG @ 16" o/c 3-15M LONGITUDINAL BARS
PAD FOOTING SCHEDULE					
ALLOWABLE SOIL BEARING CAPACITY / BEARING RESISTANCE AT SLS FOR <SITE CLASS>					
POST FOOTINGS	100KPa	85KPa	75KPa	60KPa	40KPa
F1	36"Wx36"Wx10'H 3-15M LONGITUDINAL BARS x 36" LONG EACH WAY	38"Wx36"Wx10'H 3-15M LONGITUDINAL BARS x 36" LONG EACH WAY	40"Wx40"Wx10'H 3-15M LONGITUDINAL BARS x 36" LONG EACH WAY	44"Wx44"Wx10'H 3-15M LONGITUDINAL BARS x 36" LONG EACH WAY	54"Wx54"Wx10'H 3-15M LONGITUDINAL BARS x 48" LONG EACH WAY
F2	24"W x 24"W x 10'H	24"W x 24"W x 10'H	24"W x 24"W x 10'H	28"W x 28"W x 10'H	36"Wx36"Wx10'H 3-15M LONGITUDINAL BARS x 30" LONG EACH WAY

NOTES:

- CONCRETE TO HAVE A MINIMUM COMPRESSIVE STRENGTH OF 3000 P.S.I. (20MPa) AT 28 DAYS FOR FOOTINGS AND WALL.
- ALL GARAGE FLOOR SLAB TO BE 4" THICK AND 4500 P.S.I. c/w 5 TO 8% AIR ENTRAINMENT & TO BE SLOPED TOWARDS THE EXTERIOR (MIN 2% SLOPE).
- CONCRETE FOOTINGS MUST BE PLACED ON UNDISTURBED OR COMPACTED SOIL TO AN ELEVATION BELOW FROST PENETRATION OR FROST PROTECTION SHALL BE PROVIDED.
- FOUNDATION WALL SHALL NOT BE BACKFILLED UNTIL CONCRETE HAS REACHED ITS SPECIFIED 28 DAY STRENGTH AND STRUCTURAL FLOOR FRAMING (INCLUDING PLYWOOD SUBFLOOR) REQUIRED TO STABILIZE THE WALLS ARE COMPLETED AND FULLY NAILED AND ANCHORED.
- FOOTINGS DIMENSIONS ARE BASED ON THE SOIL BEARING CAPACITY PROVIDED BY THE GEOTECHNICAL ENGINEER.
- BEARING STRATA TO BE INSPECTED AND THE BEARING VALUE AND UNDER SIDE OF FOOTING (USP) ELEVATION CONFIRMED BY GEOTECHNICAL CONSULTANT AT TIME OF EXCAVATION.
- FOR ALLOWABLE BEARING VALUES OUTSIDE OF THE FOOTING SCHEDULE, CONTACT THE STRUCTURAL ENGINEER FOR INSTRUCTIONS.
- REINFORCING STEEL SHALL COMPLY TO CSA18 GRADE 400.
- THIS DRAWING IS TO BE READ IN CONJUNCTION WITH THE ARCHITECTURAL BASEMENT FLOOR PLAN AND ARCHITECTURAL SPECIFICATION.


BASEMENT WINDOW REINFORCING

SCALE: 1/4" = 1'-0"

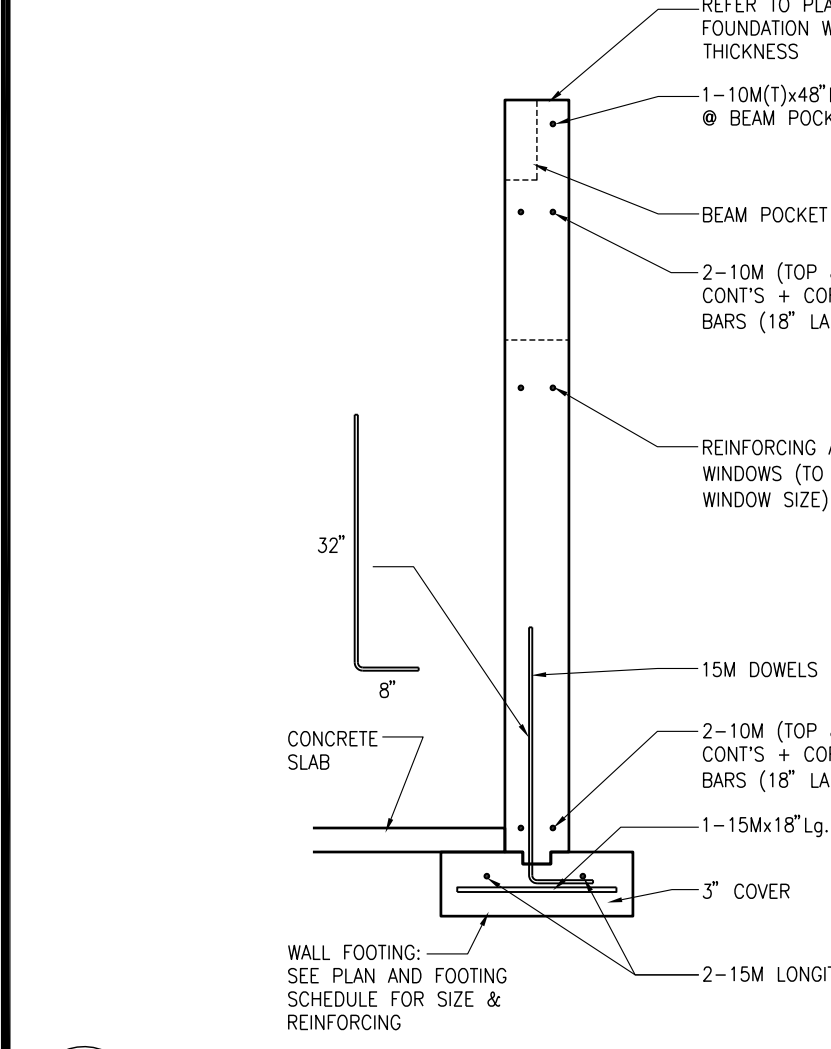

CONCRETE WALL REINFORCING

SCALE: 1/2" = 1'-0"

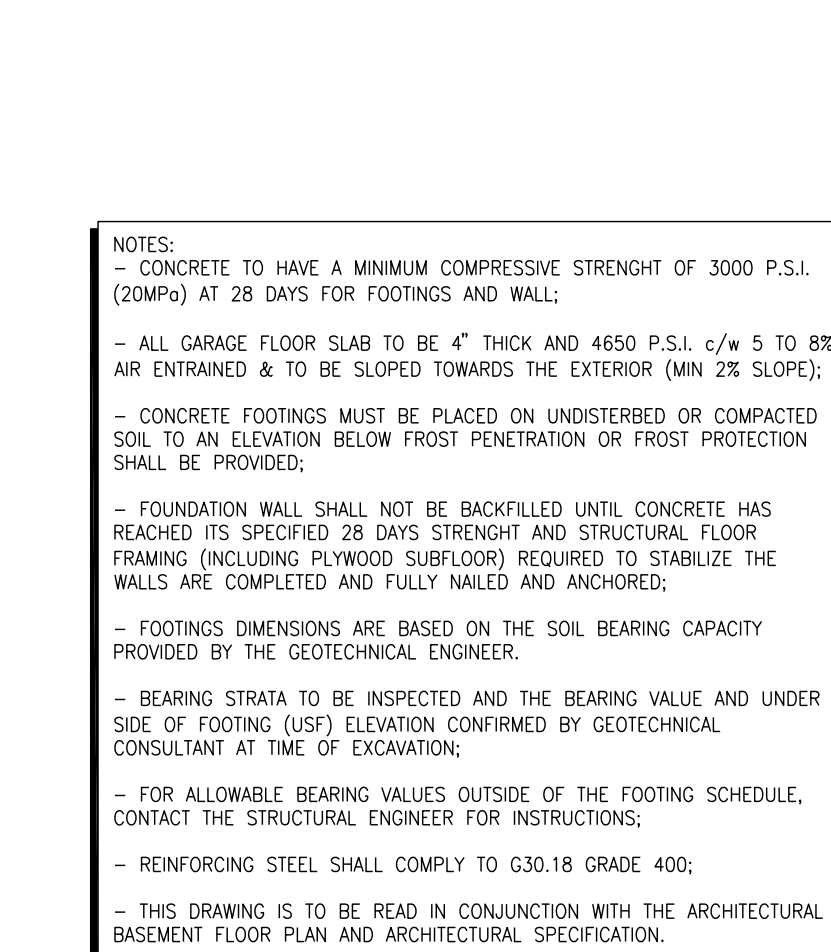

1. DANIEL GUSMAN, ARCHITECTURAL MANAGER FOR VALECRAFT HOMES LTD., HAVE REVIEWED THE FOLLOWING DOCUMENTS AND TAKE RESPONSIBILITY FOR THE DESIGN ACTIVITIES.

2. PERSONAL SIGN #18996

3. TARIAN REGISTRATION NUMBER #611

4. SEE SIGNED SCHEDULE 1- DESIGNER INFORMATION FORM

THIS DRAWING IS TO BE USED IN CONJUNCTION WITH SCHEDULE 1-1A AND ANY PARTS AND MAY SHOW ONLY SOME OF THE CHANGES DETAILED ON THAT DOCUMENT. SHOULD THE DRAWINGS NOT SHOW ALL ITEMS CONTAINED ON A SCHEDULE OR WES OTHER ITEMS, TOGETHER, THE SCHEDULE IS CONSIDERED THE COVERING DOCUMENT.

ALL CONTRACTORS SHALL PERFORM THEIR WORK WHETHER ASSIGNED OR NOT, ACCORDING TO THE APPLICABLE BUILDING CODE REQUIREMENTS AND MUNICIPAL REGULATIONS.

THE GENERAL CONTRACTOR SHALL CHECK AND VERIFY ALL DIMENSIONS AND REPORT ERRORS AND OMISSIONS TO VALECRAFT'S ARCHITECTURAL DEPARTMENT.

NO DIMENSION SHOULD BE SCALED ON DRAWINGS.

THE GENERAL CONTRACTOR OR SUB-CONTRACTORS WILL BE HELD RESPONSIBLE FOR ALL WORK DONE ON THE CONSTRUCTION SITE.

NOTES:

2012 O.B.C. DRAWINGS


REV	DESCRIPTION	DATE
REV-3	ISSUED FOR CONSTRUCTION	08/19/2021 DOYON
REV-2	ISSUED FOR TRUSSES AND JOISTS	07/29/2021 DOYON
REV-1	ISSUED FOR CONSTRUCTION	06/13/2021 DOYON
NO.	DESCRIPTION	1MM/00/0001BY


FOOTING PLAN

ADDRESS: [blank] SCALE: 1/4" = 1'-0" DATE: MM/DD/YYYY 05/10/2021

BLOCK: D
PALCE ST-THOMAS
PHASE 6


SHEET:
A.4

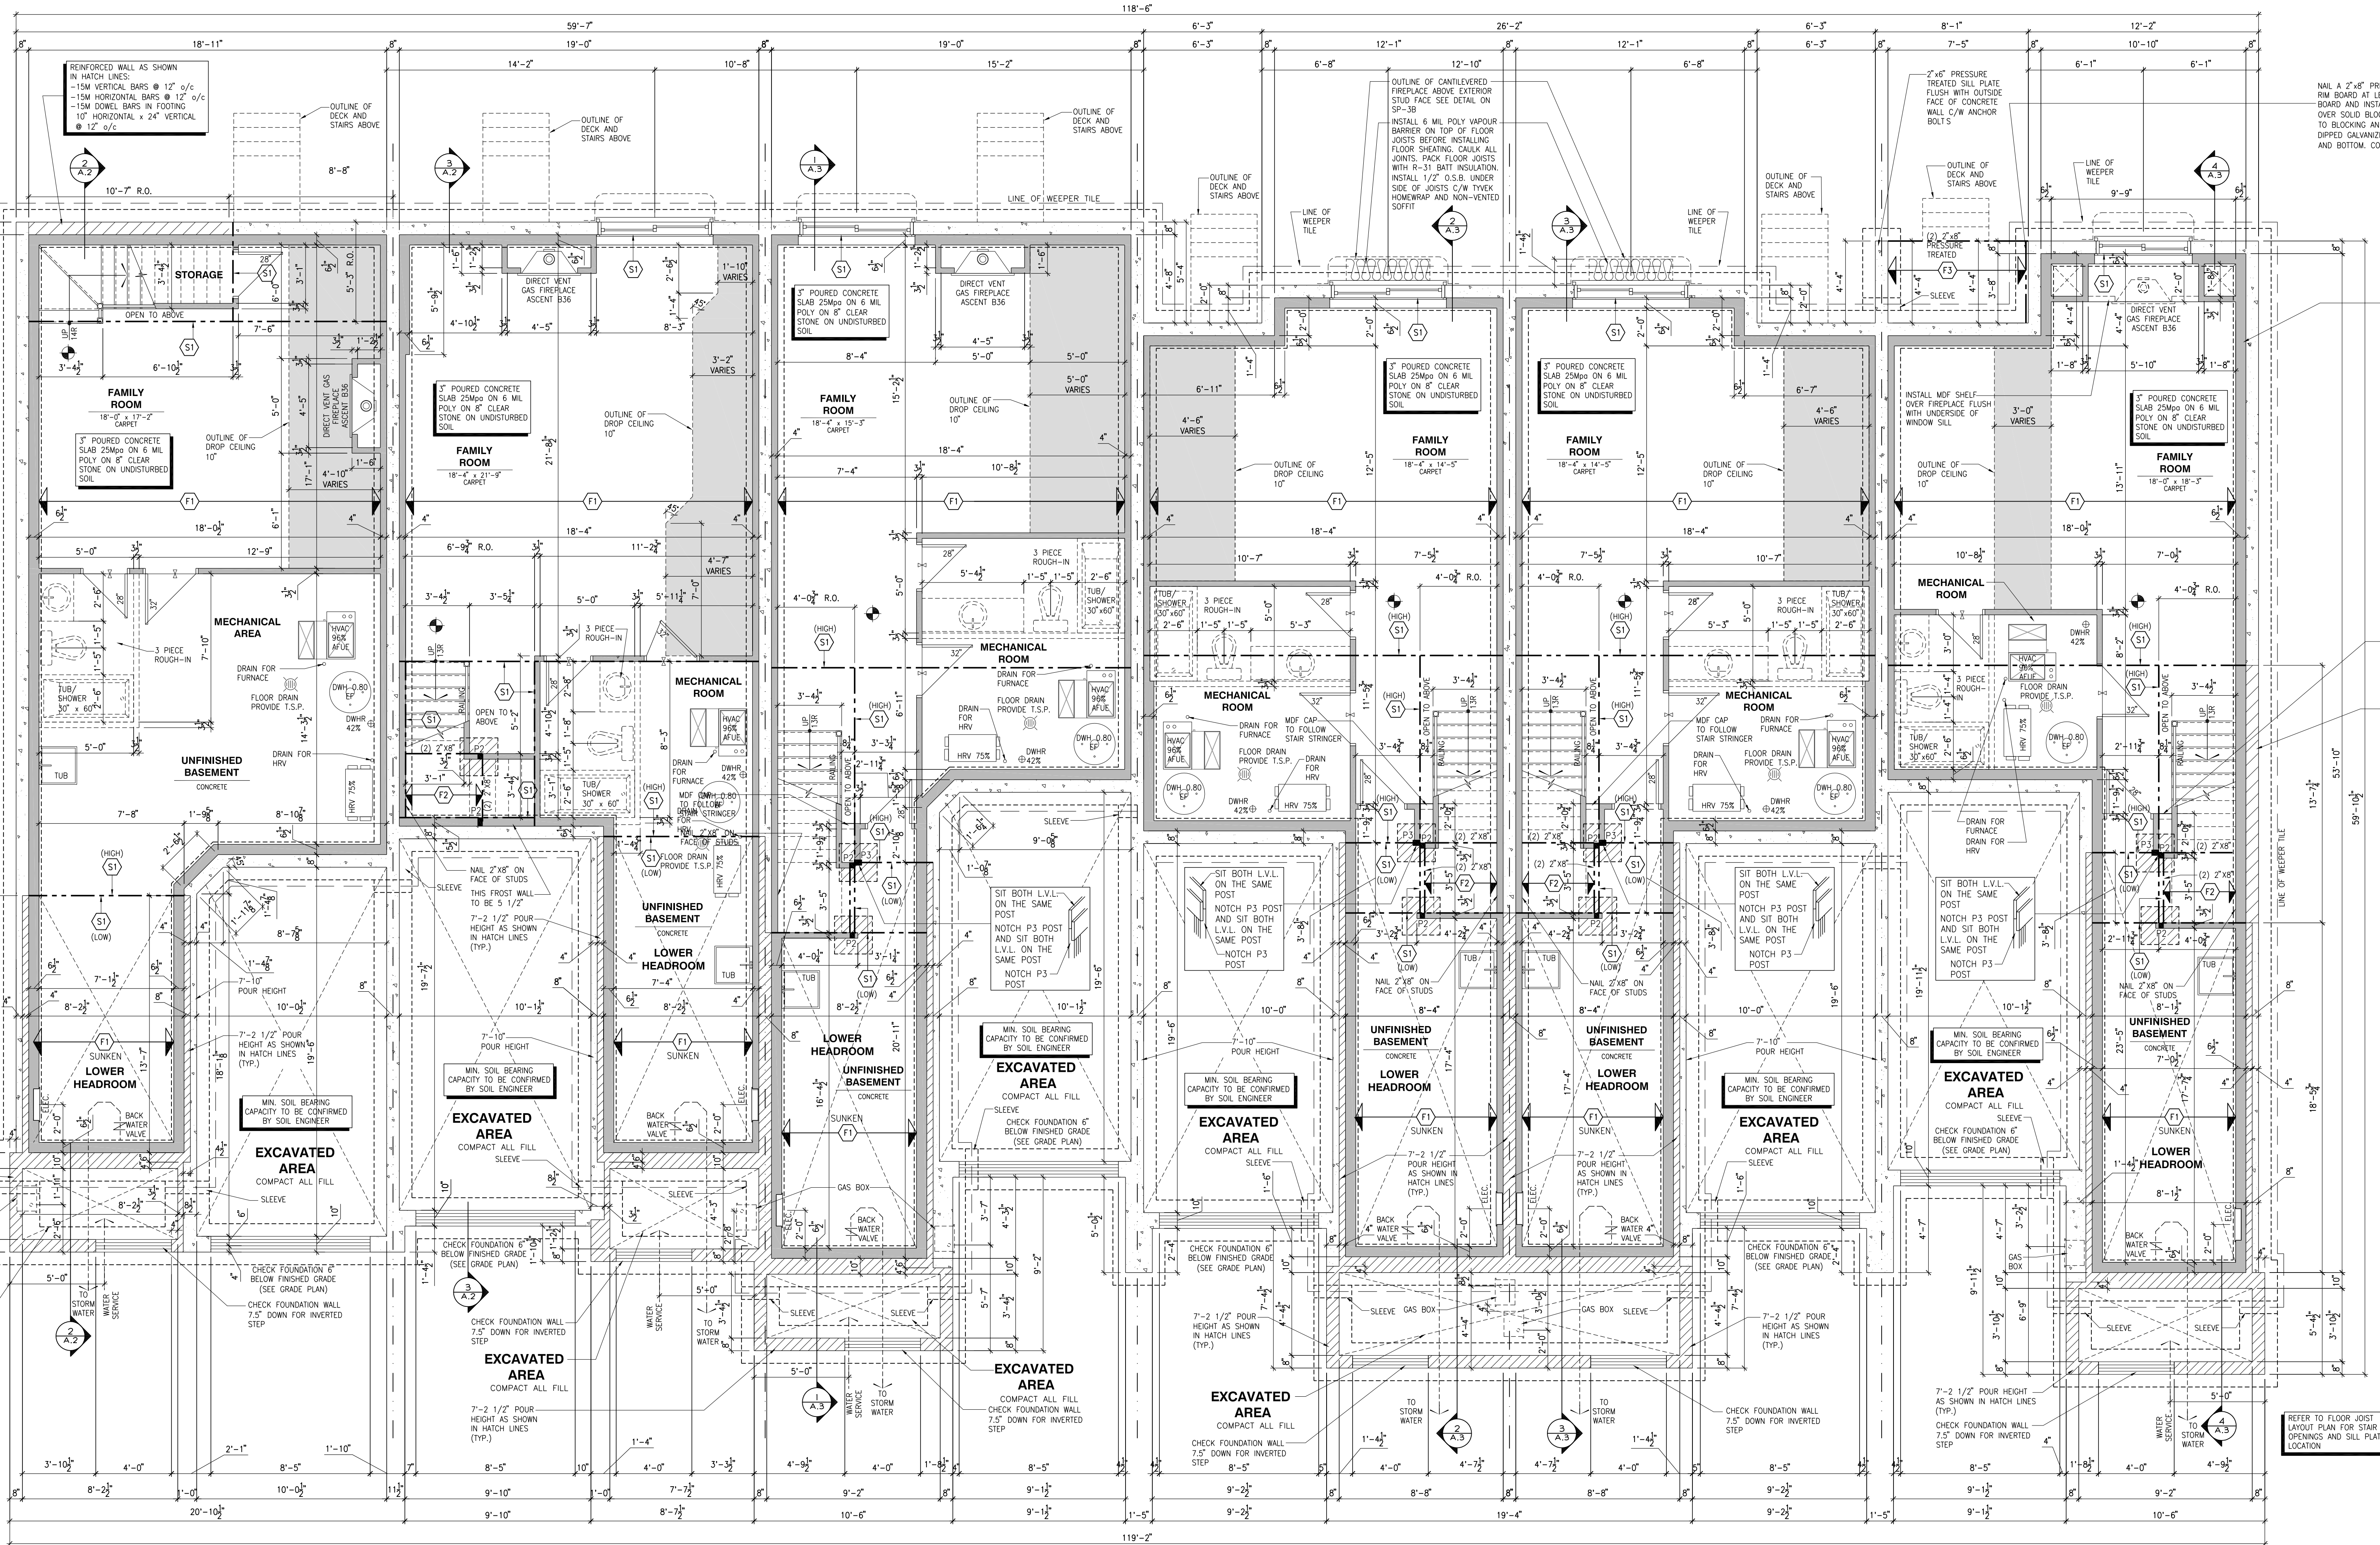

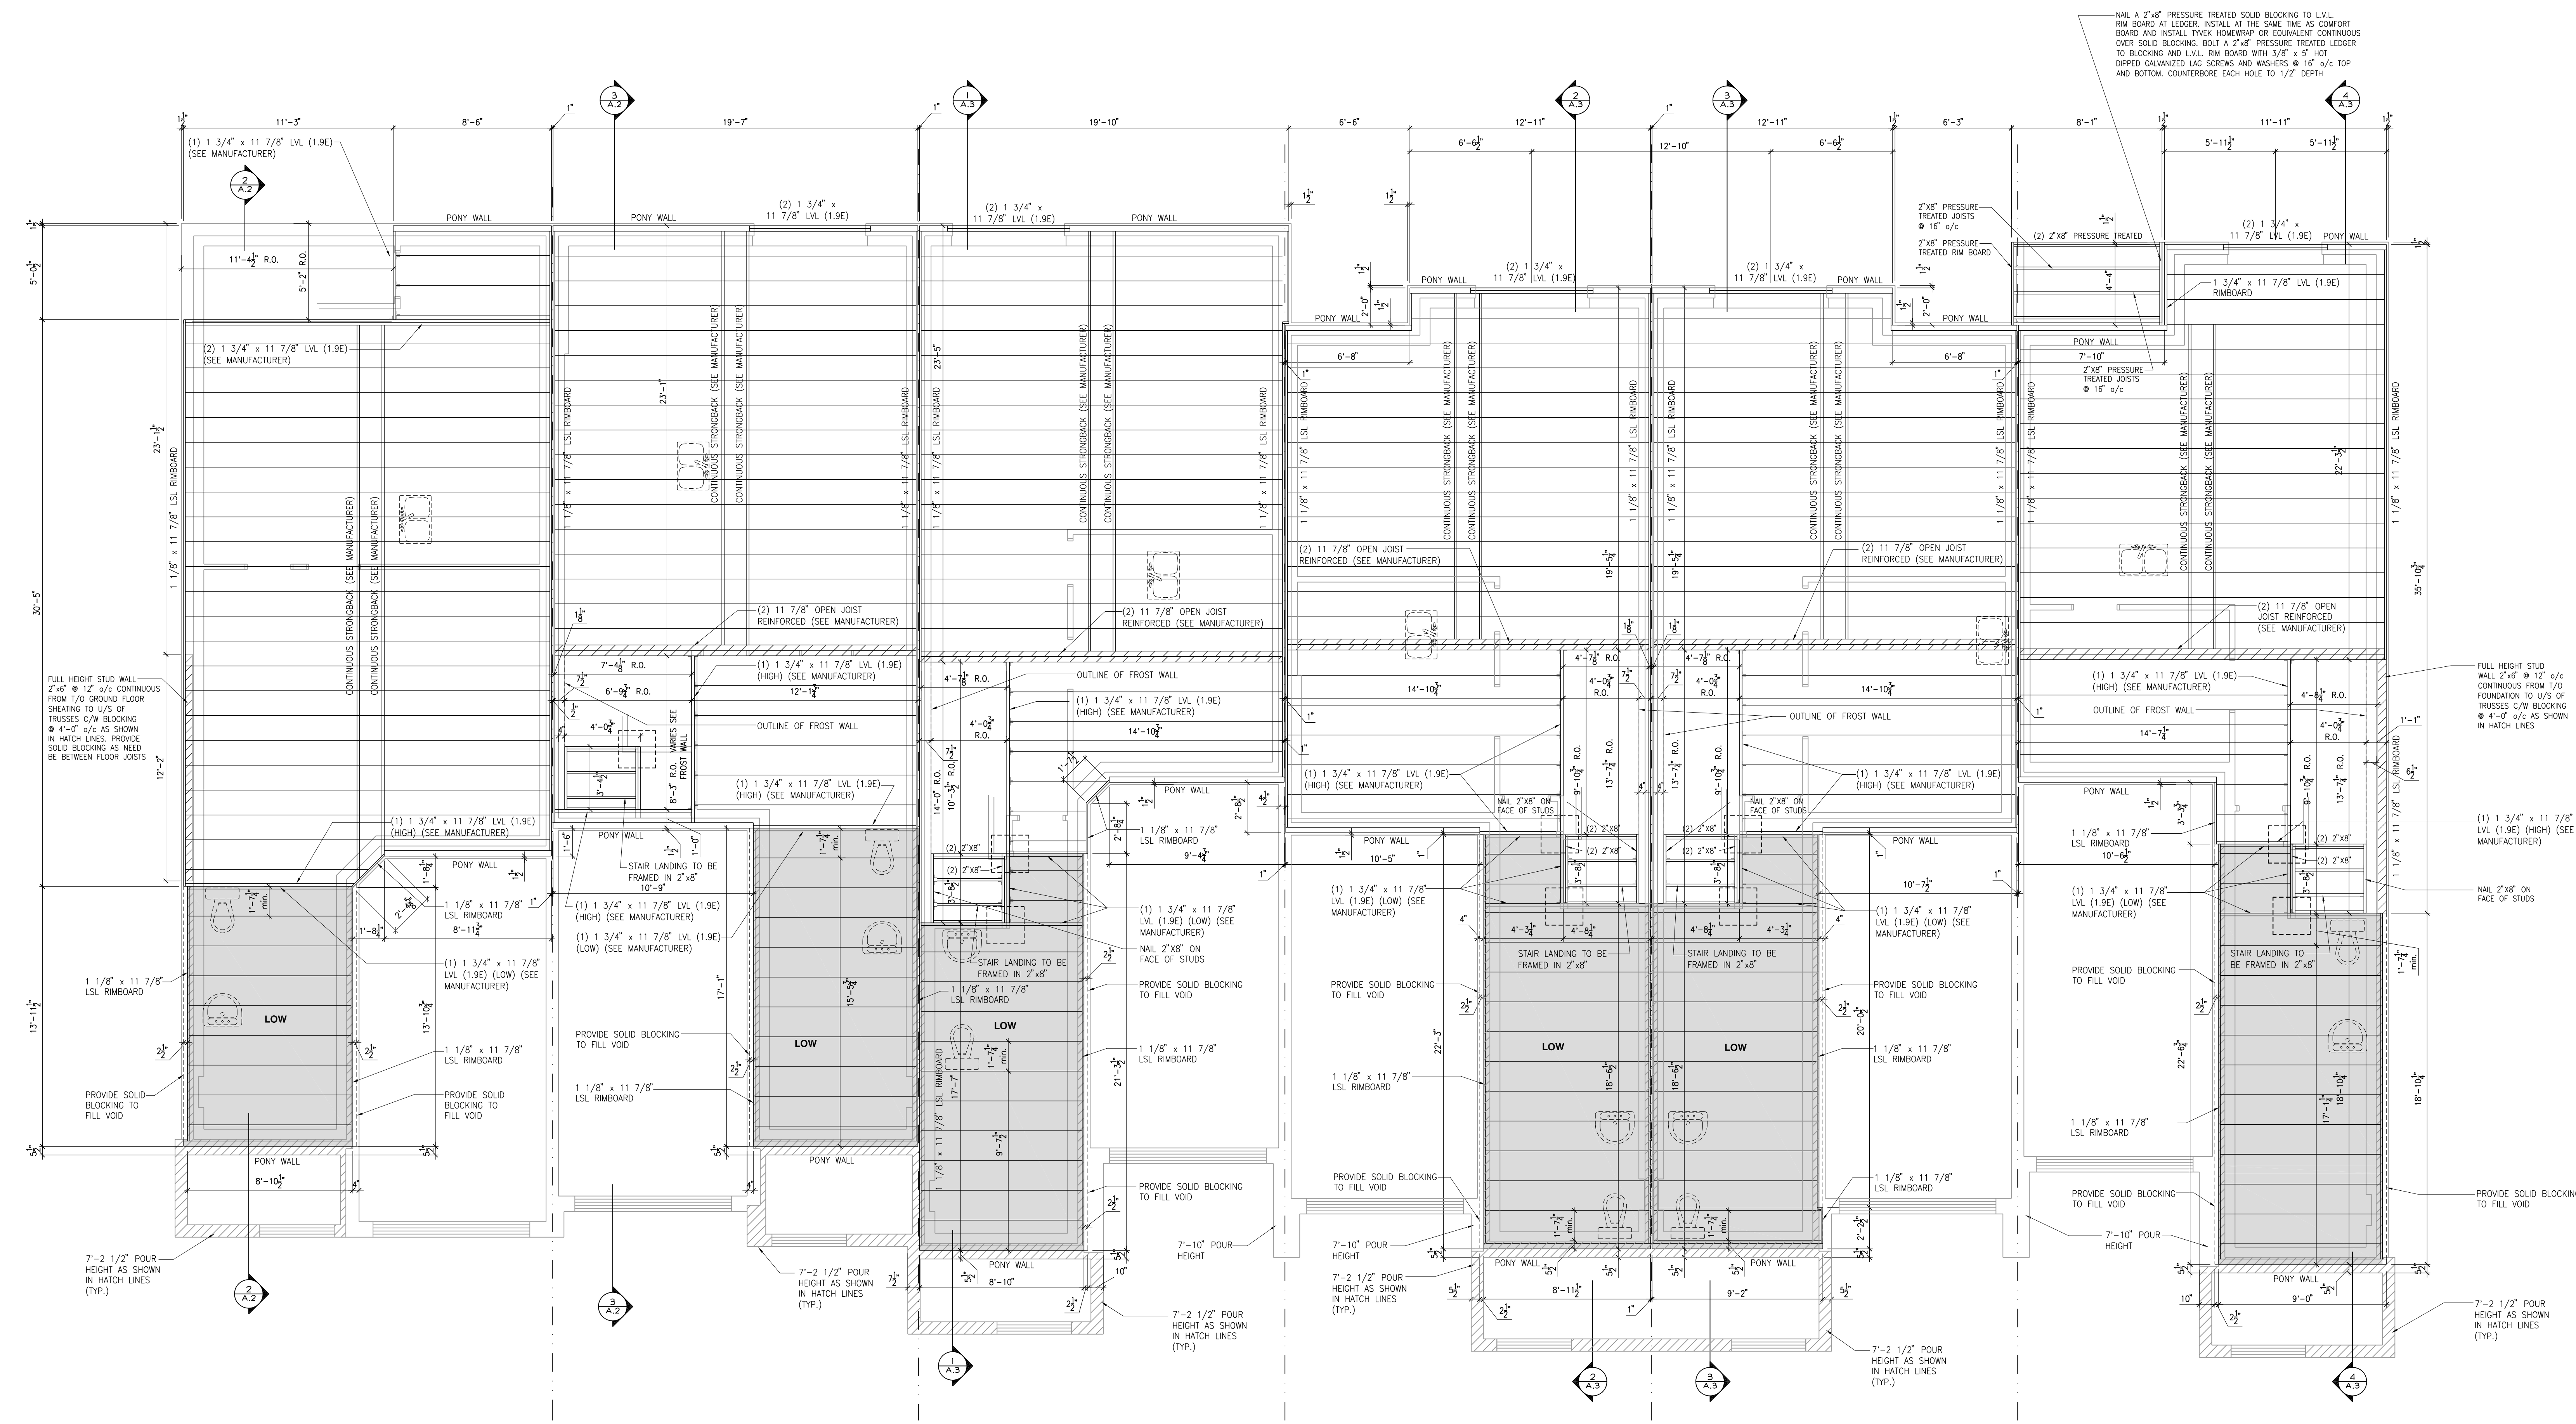

1. DANIEL GUDRIK, ARCHITECTURAL MANAGER FOR VALECRAFT HOMES LTD., HAVE REVIEWED THE FOLLOWING DOCUMENTS AND TAKE RESPONSIBILITY FOR THE DESIGN ACTIVITIES.
2. PERSONAL SIGNATURE
3. TARIOR REGISTRATION NUMBER #611
4. SEE SIGNED SCHEDULE 1: DESIGNER INFORMATION FORM
THIS DRAWING IS TO BE USED IN CONJUNCTION WITH SCHEDULE 1-1A AND ANY OTHERS AND MAY SHOW ONLY SOME OF THE CHANGES DETAILED ON THAT DOCUMENT. SHOULD THE DRAWINGS NOT SHOW ALL ITEMS CONTAINED ON A SCHEDULE OR OTHER OTHER ITEMS TOGETHER, THE SCHEDULE IS CONSIDERED THE GOVERNING DOCUMENT.
ALL CONTRACTORS SHALL PERFORM THEIR WORK WHETHER DESCRIBED OR NOT, ACCORDING TO THE APPLICABLE BUILDING CODE REQUIREMENTS AND MUNICIPAL REGULATIONS.
THE GENERAL CONTRACTOR SHALL CHECK AND VERIFY ALL DIMENSIONS AND REPORT ERRORS AND OMISSIONS TO VALECRAFT'S ARCHITECTURAL DEPARTMENT.
NO DIMENSION SHOULD BE SCALED ON DRAWINGS.
THE GENERAL CONTRACTOR OR SUB-CONTRACTORS WILL BE HELD RESPONSIBLE FOR ALL WORK DONE ON THE CONSTRUCTION SITE.
NOTES:
1. SMOKE ALARMS AS PER SECTION 9.10.19. OF THE ONTARIO BUILDING CODE:
- SHALL HAVE A VISUAL SMOKE-ALARM DEVICE;
- ARE REQUIRED IN EACH SLEEPING ROOM AND HALLWAY;
- ARE REQUIRED ON EACH FLOOR, INCLUDING BASEMENT;
- ARE REQUIRED TO BE PROVIDED WITH BATTERY AS AN ALTERNATE POWER SUPPLY CAPABLE OF PROVIDING POWER FOR AT LEAST 7 DAYS IN NORMAL CONDITION, FOLLOWED BY 3 MINUTES OF ALARM AND
- CARBON MONOXIDE ALARM ARE ALSO REQUIRED ADJACENT TO EACH SLEEPING AREA.
2. PROVIDE MECHANICAL EXHAUST TO OUTSIDE

STEEL LINTEL:
S1 = 1.50x90x8
S2 = 1.50x90x8
S3 = 1.50x90x8
S4 = 1.25x90x8
S5 = 1.25x90x8
S6 = 1.25x90x8
S702 = 1.25x90x8
S703 = 1

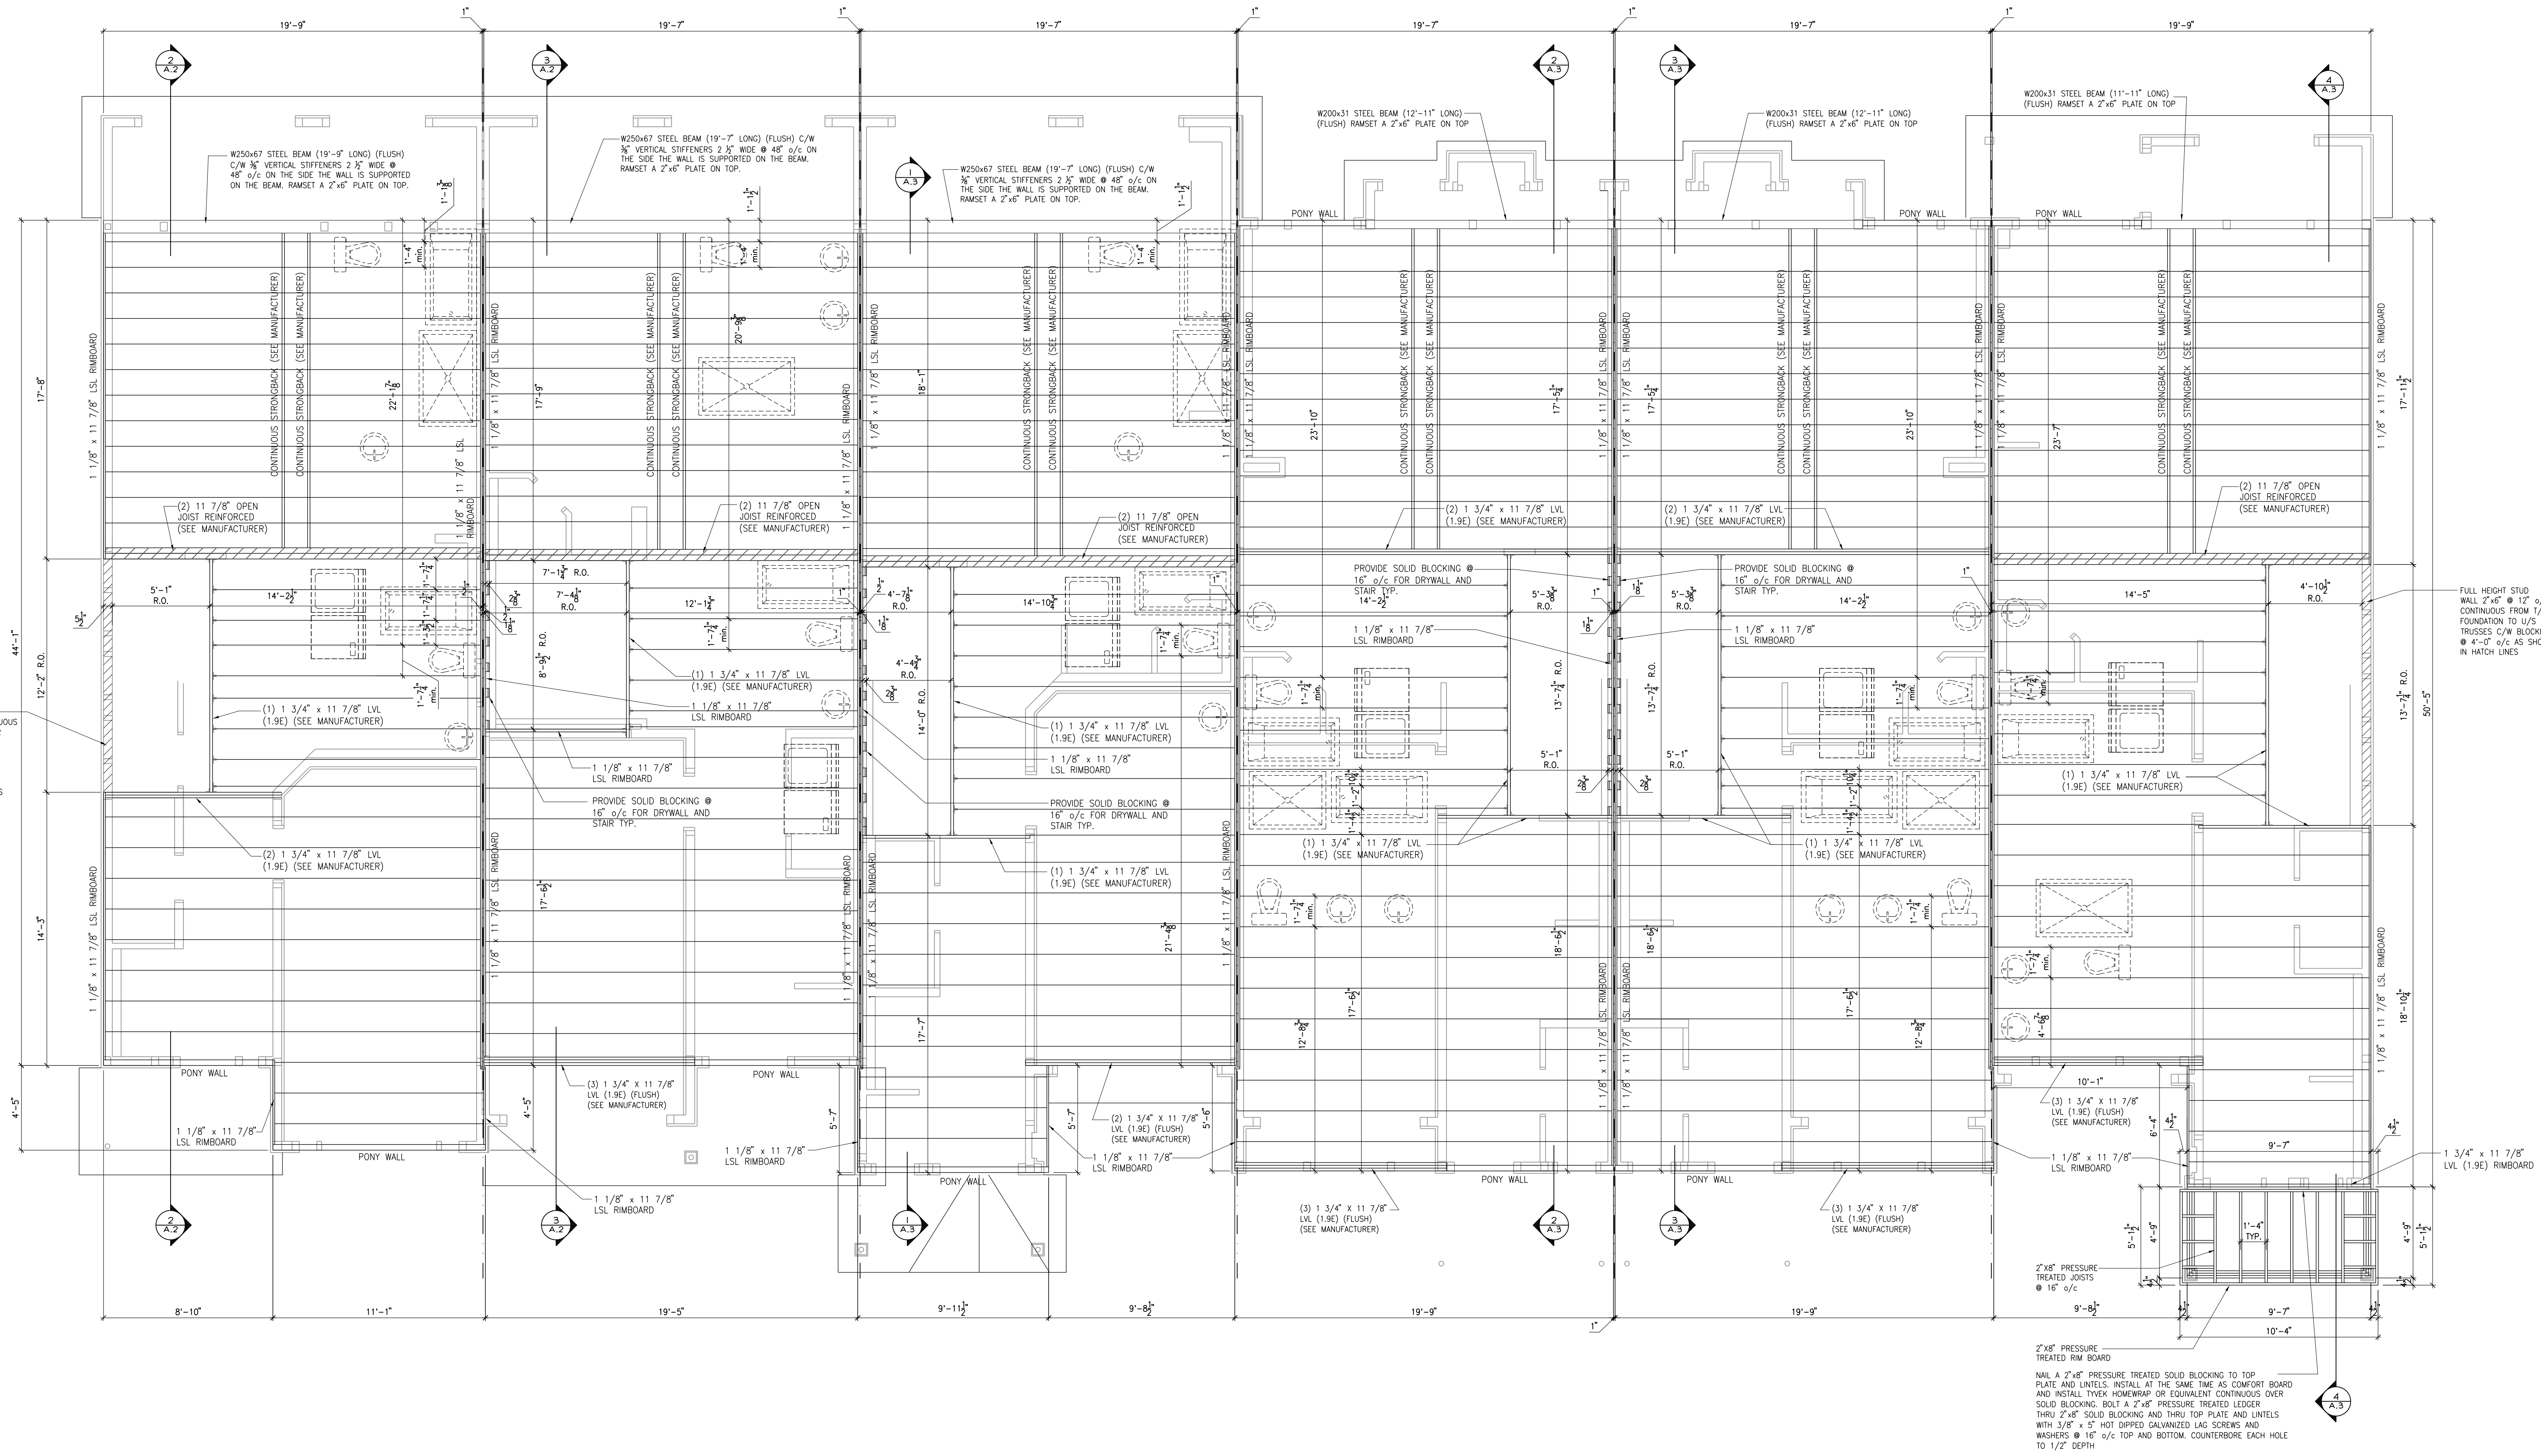

PLACE ST-THOMAS - PHASE 6
MODEL: 110 THE THOMAS
BLOCK: D
LOT: 21
ADDRESS: 737 NAMUR STREET

PLACE ST-THOMAS - PHASE 6
MODEL: 140 THE GREEN (REV)
BLOCK: D
LOT: 20
ADDRESS: 739 NAMUR STREET

PLACE ST-THOMAS - PHASE 6
MODEL: 120 THE HUNTLEY
BLOCK: D
LOT: 19
ADDRESS: 741 NAMUR STREET

PLACE ST-THOMAS - PHASE 6
MODEL: 160-2 THE STANLEY 2 (REV)
BLOCK: D
LOT: 18
ADDRESS: 743 NAMUR STREET

PLACE ST-THOMAS - PHASE 6
MODEL: 160-2 THE STANLEY 2
BLOCK: D
LOT: 17
ADDRESS: 745 NAMUR STREET

PLACE ST-THOMAS - PHASE 6
MODEL: 130 THE LEWIS (REV)
BLOCK: D
LOT: 16
ADDRESS: 747 NAMUR STREET

ALL CONTRACTORS SHALL PERFORM THEIR WORK WHETHER DESCRIBED OR NOT, ACCORDING TO THE APPLICABLE BUILDING CODE REQUIREMENTS AND MUNICIPAL REGULATIONS.
THE GENERAL CONTRACTOR OR SUB-CONTRACTORS WILL BE HELD RESPONSIBLE FOR ALL WORK DONE ON THE CONSTRUCTION SITE.
NOTES:
1. SMOKE ALARMS AS PER SECTION 9.10.10. OF THE ONTARIO BUILDING CODE:
- SHALL HAVE A VISUAL SMOKE-DETECTING DEVICE;
- ARE REQUIRED IN EACH SLEEPING ROOM AND HALLWAY;
- ARE REQUIRED ON EACH LEVEL OF THE BUILDING;
- ARE REQUIRED TO BE PROVIDED WITH BATTERY AS AN ALTERNATIVE POWER SOURCE IN THE EVENT OF A POWER OUTAGE FOR AT LEAST 7 DAYS IN NORMAL CONDITION, FOLLOWED BY 4 MINUTES OF ALARM AND
- CARBON MONOXIDE ALARM ARE ALSO REQUIRED ADJACENT TO EACH SLEEPING AREA.
2. PROVIDE MECHANICAL EXHAUST TO OUTSIDE

STEEL LUTEL:
L1 = 1.50x90x8
L2 = 1.50x90x8
L3 = 1.50x90x8
L704 = 1.50x90x8
L705 = 1.50x

